 
 



Luminaire Schedule: FRANCO'S WAREHOUSE - SITE\_REV 2 POMPANO BEACH, FL 10/26/2021

Symbol	Qty	Label	Arrangement	Manufacturer	Catalog Number	Mounting	LLF	Luminaire Lumens	Luminaire Watts	Arrangement Watts
	1	SA	Single	U.S. Architectural Lighting	RZR-M/PLED-IV-FT/48LED-525mA/NW/HS-PLED	POLE MOUNT A.F.G.	0.903	7978	79	79
	4	SW	Single	Lithonia Lighting	WDGE1 LED P1 40K 80CRI VF	WALL MOUNT A.F.F.	0.903	1227	10.0002	10.0002

Calculation Summary: FRANCO'S WAREHOUSE - SITE\_REV 2 POMPANO BEACH, FL 10/26/2021

Label	Calc Type	Units	Avg	Max	Min	Avg/Min	Max/Min
BOTTOM AREA	Illuminance	Fc	1.65	3.5	0.5	3.30	7.00
PARKING SPACES	Illuminance	Fc	2.96	6.1	1.2	2.47	5.08
SPILL	Illuminance	Fc	0.15	0.5	0.0	N.A.	N.A.

B6 LIGHT POLE DETAIL  
1/4" = 1'-0"

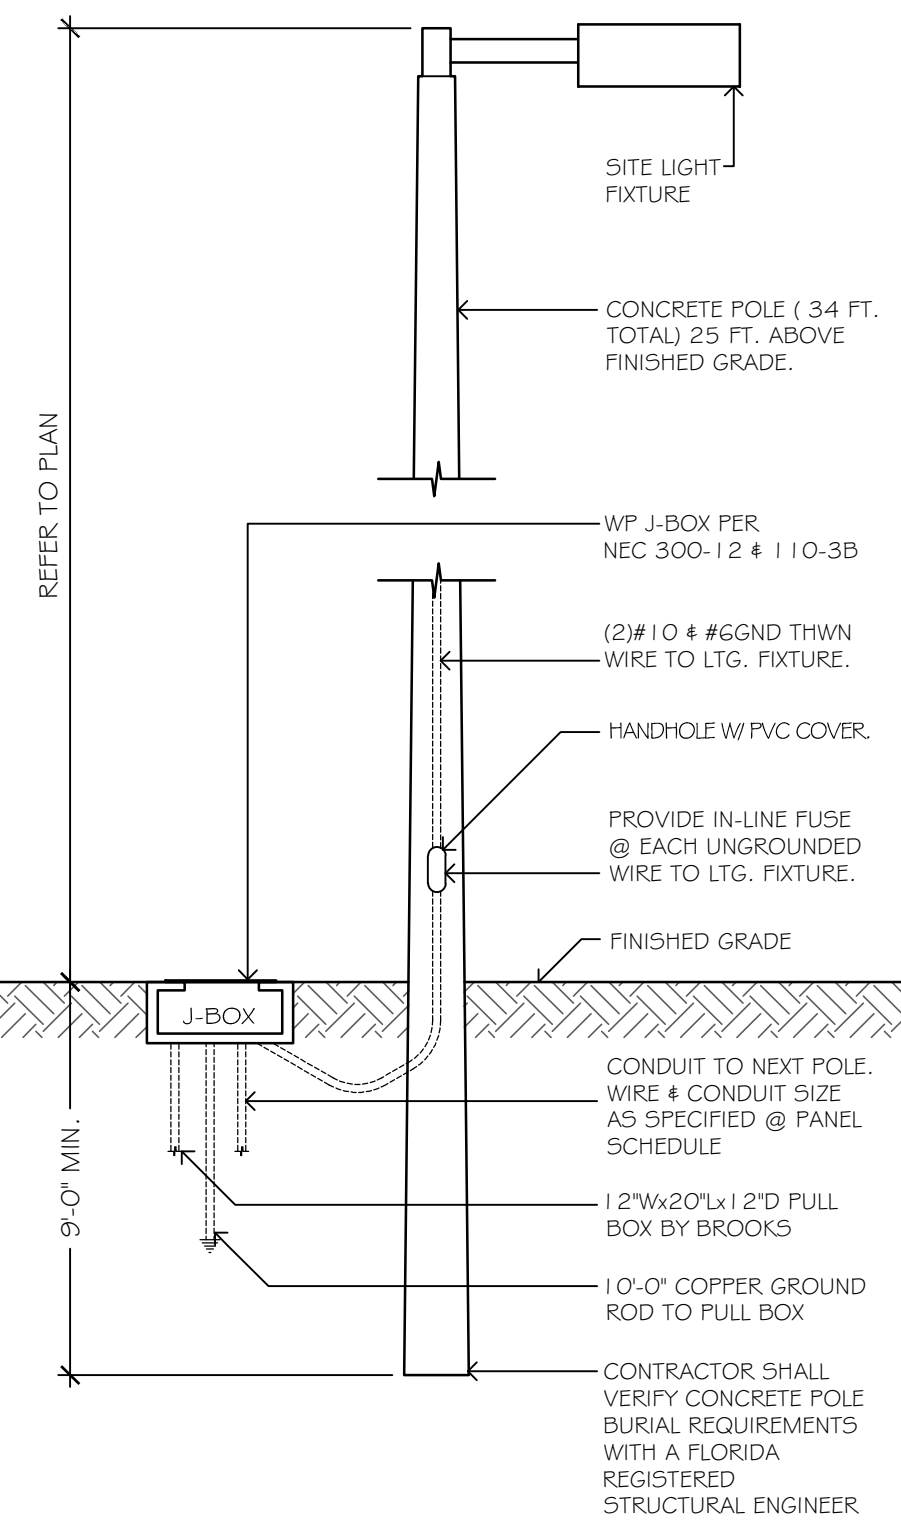

E6 NOT USED

DESIGNED  
JPB

DRAWN  
GC

CHECKED  
JPB

DATE:  
8.17.21

COMM:  
210511


REVISIONS

PHOTOMETRIC PLAN

SITE PLAN APPROVAL

AS-103

SITE IMPROVEMENTS & NEW BUILDING FOR:  
FRANCO'S WAREHOUSE

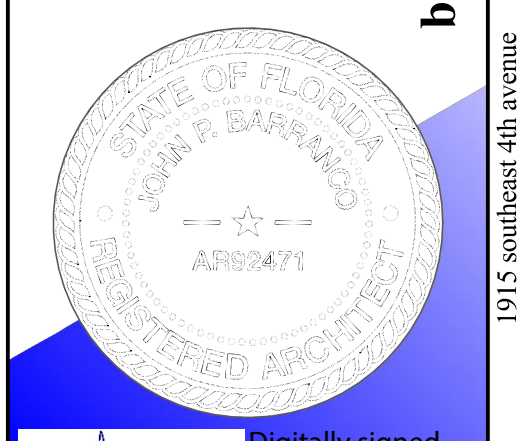

Digitally signed  
by John Barranco  
Date: 2022.04.19  
12:58:50 -0400

