



AREA CALCULATION: B	
1st FLOOR - A/C	1,040 S.F.
2nd FLOOR - A/C	1,146 S.F.
3rd FLOOR - A/C	584 S.F.
TOTAL - A/C:	2,770 S.F.
GARAGE	216 S.F.
ENTRY	40 S.F.
PATIO	64 S.F.
BALCONY 1	41 S.F.
BALCONY 2	64 S.F.
BALCONY 3	64 S.F.
UPPER DECK	777 S.F.
ROOF	584 S.F.
SUB-TOTAL:	1,786 S.F.
GRAND TOTAL:	4,456 S.F.

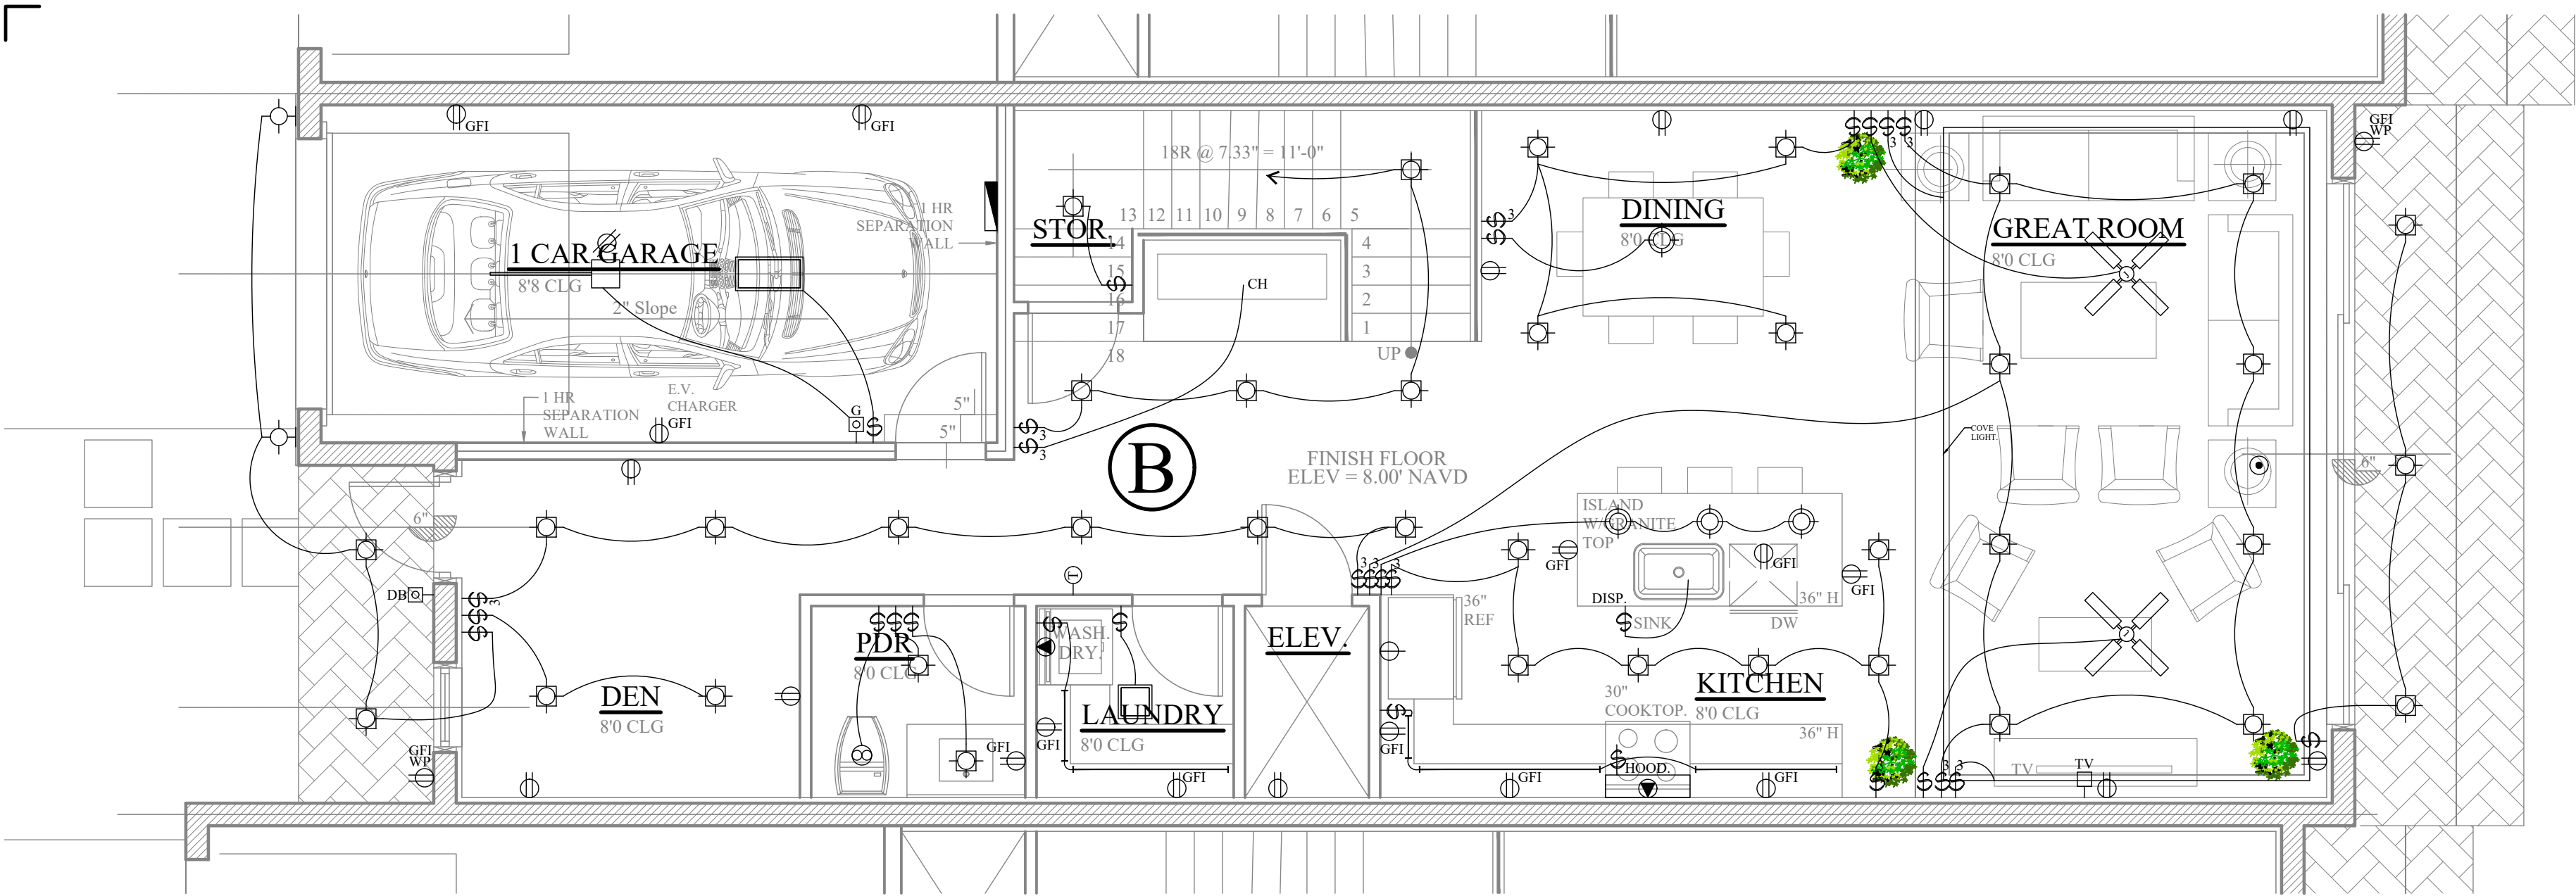


UNT-B 1st. FLOOR ELECTRICAL PLAN

SCALE: 1/4" = 1'-0"

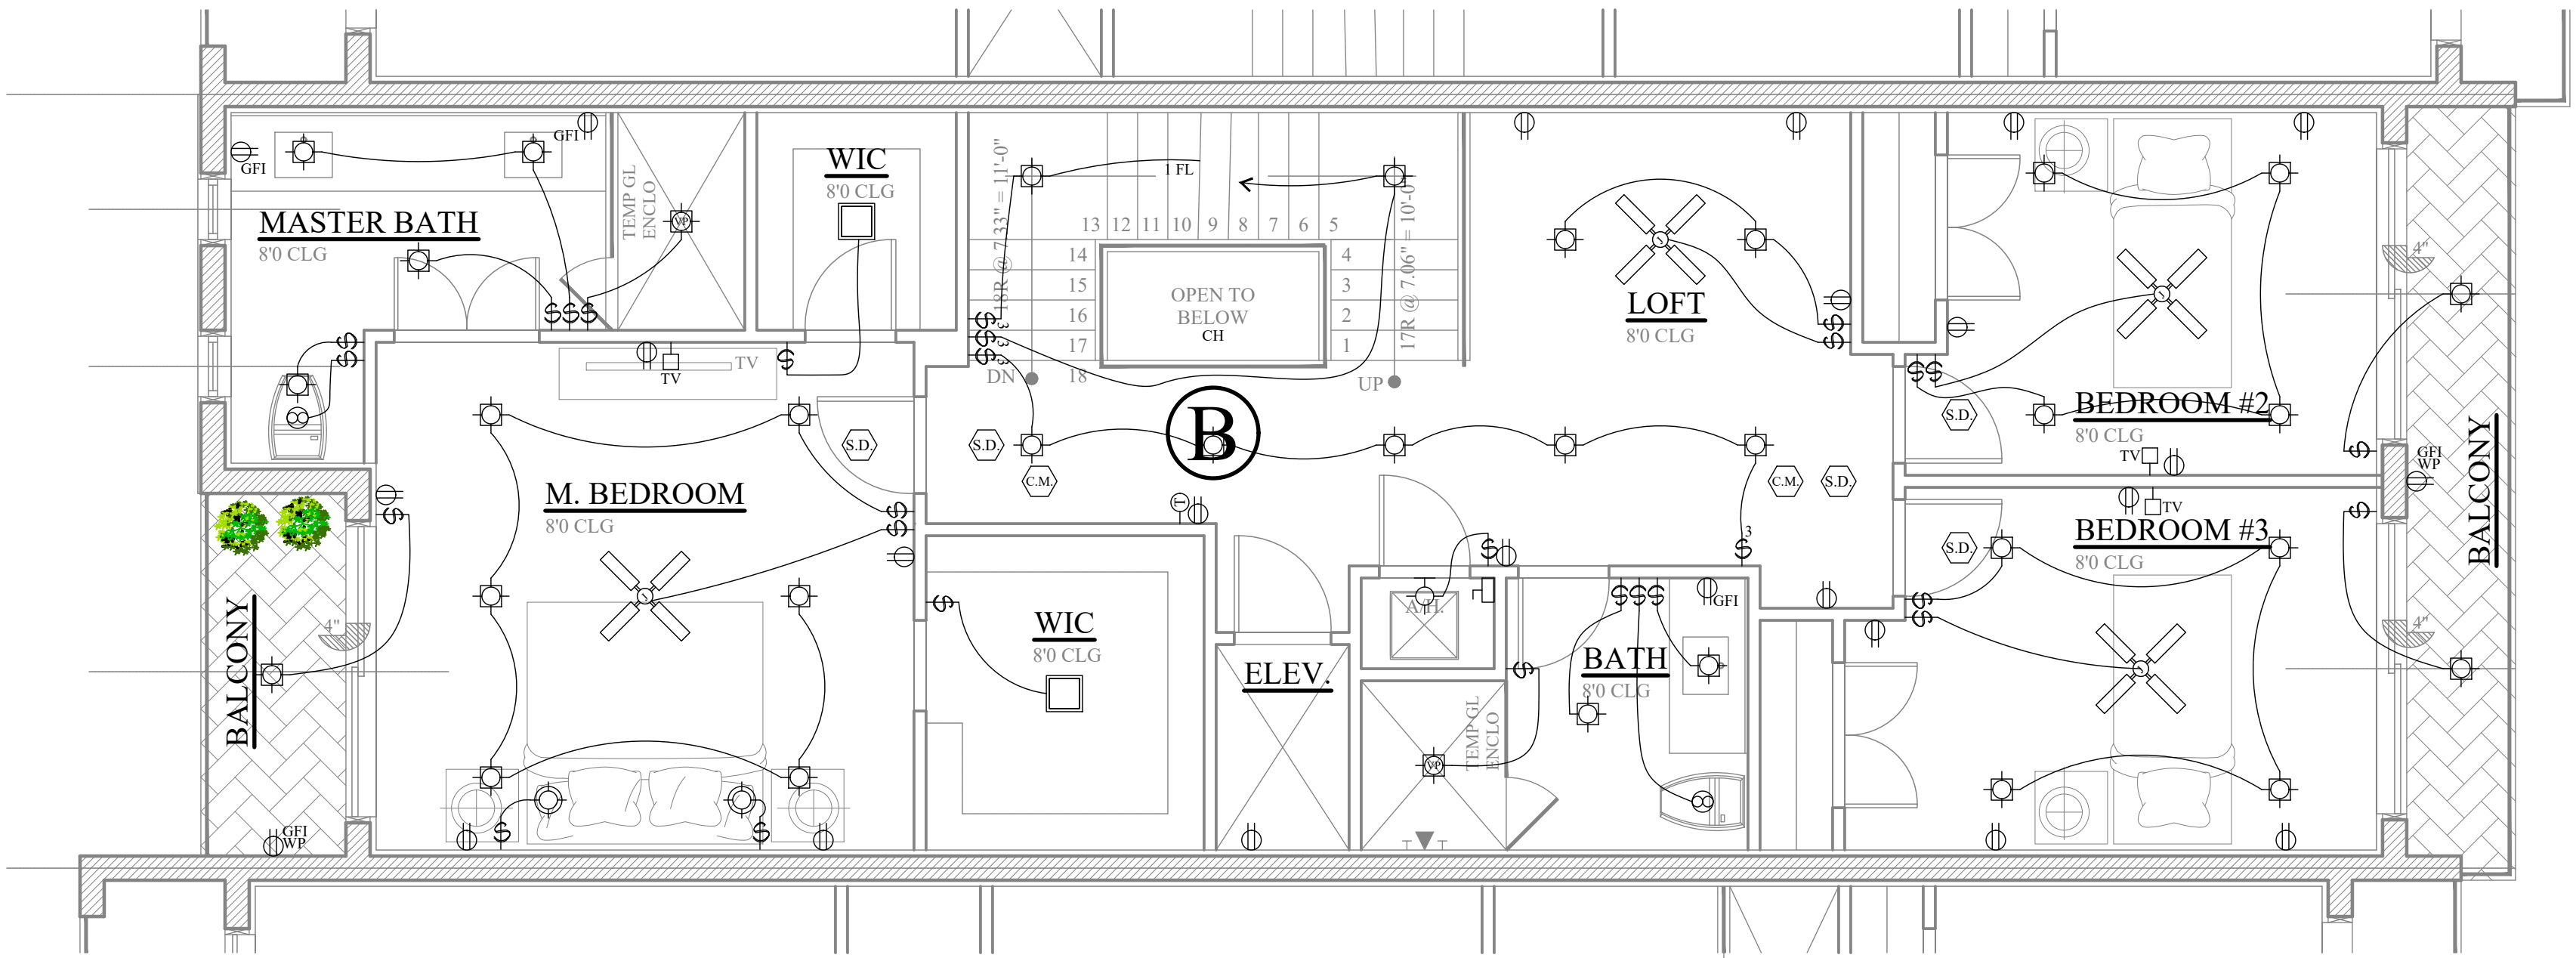

UNT-B 2dn. FLOOR ELECTRICAL PLAN

SCALE: 1/4" = 1'-0"

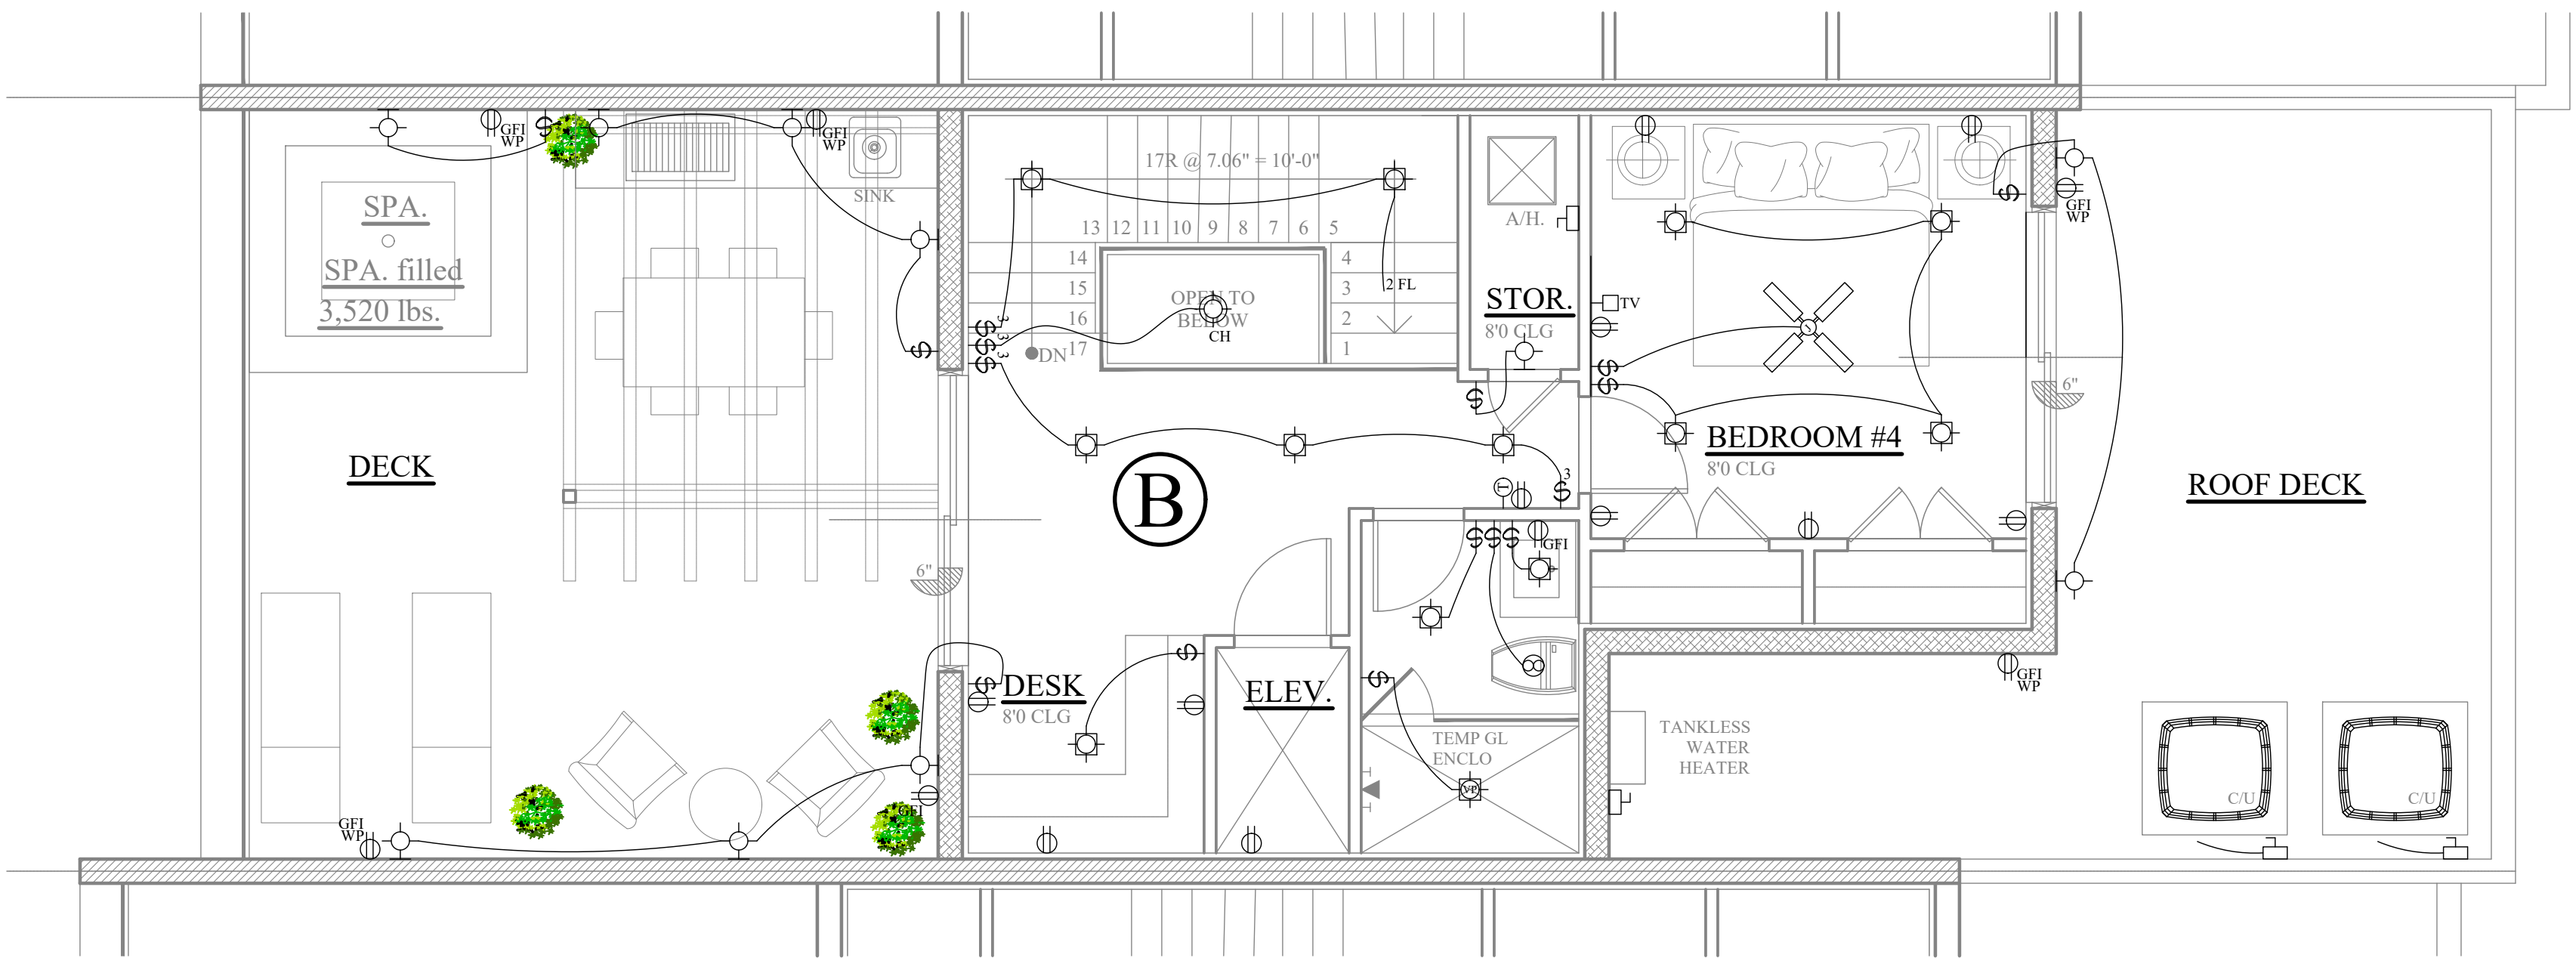

UNT-B 3rd. FLOOR ELECTRICAL PLAN

SCALE: 1/4" = 1'-0"