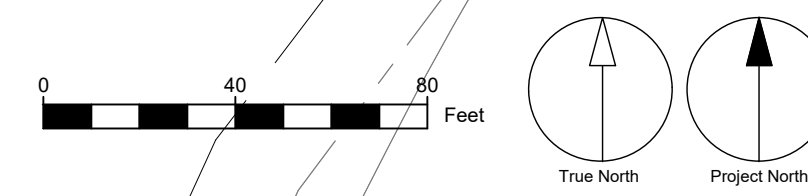


DRC

PZ25-12000042
12/17/2025

CLIENT
BROWARD COUNTY
Transit
1 N University Dr, Plantation, FL, 33324


COPYRIGHT
This drawing has been prepared solely for the intended use, thus any reproduction or distribution for any purpose other than authorized by Arcadis is forbidden. Written dimensions shall have precedence over scaled dimensions. Contractors shall verify and be responsible for all dimensions and conditions on the job, and Arcadis shall be informed of any variations from the dimensions and conditions shown on the drawing. Shop drawings shall be submitted to Arcadis for general conformance before proceeding with fabrication.

Arcadis Professional Services (USA) Inc.

ISSUES		
No.	DESCRIPTION	DATE
A	SCHEMATIC DESIGN	2023-08-31
B	DD RELEASE	2024-03-29
C	DRC RELEASE	2024-05-29
D	50% CD PRICING RELEASE	2024-07-17
E	80% CD RELEASE	2024-10-14
F	DRC #3 RESUBMITTAL	2024-11-13
G	100% CD RELEASE	2024-12-16
H	ISSUED FOR SPA - MOD	2025-11-12

NOT FOR CONSTRUCTION

KEYPLANS

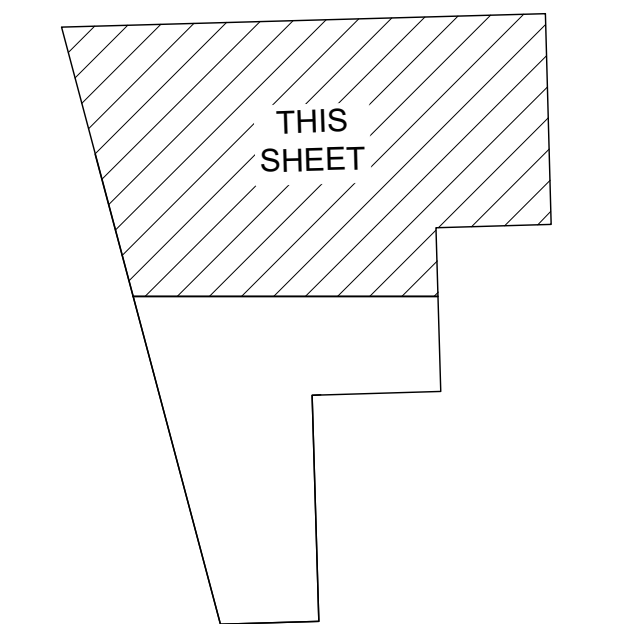

CONSULTANTS

ARCADIS
ARCADIS
7000 N FEDERAL HWY - 2ND FLOOR
BOCA RATON, FL 33497
(561) 996-2000
CONTACT: PATRICIA F. RAMUDO
email: patricia.ramudo@arcadis.com

ARCADIS
ARCADIS
421 FAVETTESVILLE STREET
SUITE 1000
RALEIGH, NC 27601
(919) 854-2111
CONTACT: KEVIN SCHAEFER
email: kevin.schaefer@arcadis.com

JEZERNAC GROUP
1615 FORUM PL, 3A
WEST PALM BEACH, FL 33411
(561) 323-7229
CONTACT: RILEY RAUOLA
email: riley@jezernacgroup.com

SMITH ENGINEERING CONSULTANTS
2181 PALM BEACH LAKES BLVD
SUITE 310
WEST PALM BEACH, FL 33411
(561) 616-2611
CONTACT: STEVE P. WICKHAM
email: steve@smithengineeringconsultants.com

SEAL

NOT TO BE FILED FOR RECORD UNLESS SIGNED AND DATED WITH THE ORIGINAL SEAL OF PATRICIA F. RAMUDO, FLORIDA P.E. #35798 FOR THE FIRM.

PRIME CONSULTANT

ARCADIS

7000 N Federal Highway
Boca Raton, FL 33487 USA
tel: 561 333 6555
www.arcadis.com

PROJECT
COPANS TRANSIT OPERATIONS FACILITY
3201 W Copans Road
Pompano Beach, FL

PROJECT NO:
136677
DRAWN BY:
CMP/JAR
CHECKED BY:
PFR
SCALE:
1" = 40'
APPROVED BY:
PFR

SHEET TITLE

SITE PLAN

SHEET NUMBER
MSP1.1
ISSUE
H

PATRICIA F. RAMUDO, State of Florida, Professional Engineer, License No. 35798

This item has been digitally signed and sealed by PATRICIA F. RAMUDO on the date indicated here.

Printed copies of this document are not considered signed and sealed and the signature must be verified on any electronic copies.

MATCHLINE SHEET MSP1.2