


PATRICIA F. RAMUDO, State of Florida, Professional Engineer, License No. 35798

This item has been digitally signed and sealed by PATRICIA F. RAMUDO on the date indicated here.

Printed copies of this document are not considered signed and sealed and the signature must be verified on any electronic copies.

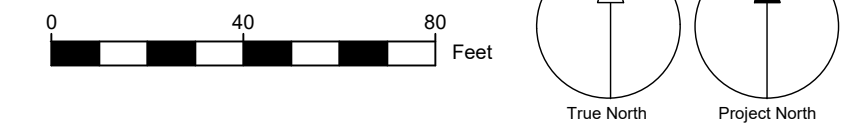

CLIENT 

1 N University Dr, Plantation, FL, 33324

**COPYRIGHT**


This drawing has been prepared solely for the intended use, thus any reproduction or distribution for any purpose other than authorized by Arcadis is forbidden. Written dimensions shall have precedence over scaled dimensions. Contractors shall verify and be responsible for all dimensions and conditions on the job, and Arcadis shall be informed of any variations from the dimensions and conditions shown on the drawing. Shop drawings shall be submitted to Arcadis for general conformance before proceeding with fabrication.

**Arcadis Professional Services (USA) Inc.**

ISSUES		
No.	DESCRIPTION	DATE
A	SCHEMATIC DESIGN	2023-08-31
B	DD RELEASE	2024-03-29
C	DRC RELEASE	2024-05-29
D	50% CD PRICING RELEASE	2024-07-17
E	80% CD RELEASE	2024-10-14
F	DRC #3 RESUBMITTAL	2024-11-13
G	100% CD RELEASE	2024-12-16
H	ISSUED FOR SPA - MOD	2025-11-12

**NOT FOR CONSTRUCTION**

## KEYPLANS

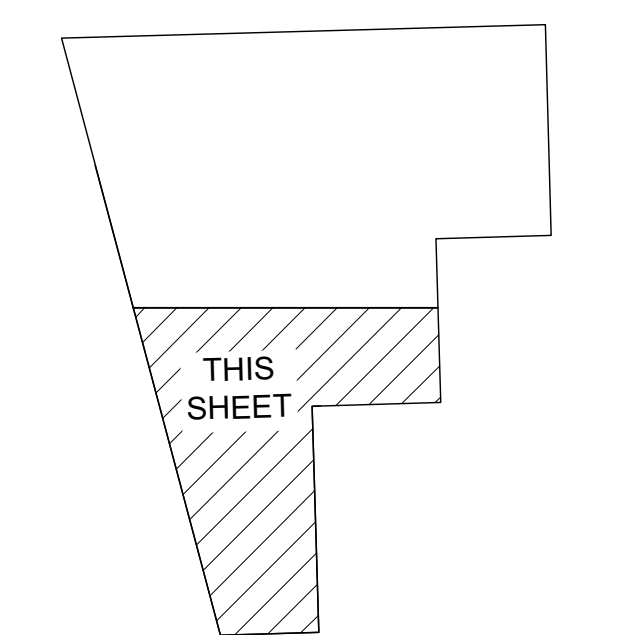

## CONSULTANTS

<u>ARCHITECT:</u>	<u>CIVIL ENGINEER:</u>
 <b>ARCADIS</b>	 <b>ARCADIS</b>
<b>ARCADIS</b> 7000 N FEDERAL HWY - 2ND FLOOR BUCKLE RATION, FL 33487 (248) 936-8000 contact: JAY KELLY email: jay.kelly@arcadis.com	<b>ARCADIS</b> 7000 N FEDERAL HWY - 2ND FLOOR BUCKLE RATION, FL 33487 (248) 936-8000 contact: PATRICIA RAMUJO email: patricia.ramudo@arcadis.com

**LANDSCAPE:  
PLACEMAKING:**

 

**ARCADIS**

**ARCADIS**  
21 CUSTOM HOUSE ST - 3RD FLOOR  
BOSTON, MA 02110  
(617) 896-2510  
contact: PHIL COLLERAN  
email: phil.colleran@arcadis.com

**SITE ELECTRICAL:**

**ARCADIS**

**ARCADIS**  
41 FAYETTEVILLE STREET  
SUITE 1609  
RALEIGH, NC 27601  
(919) 851-4211  
contact: KEVIN SCHAEFER  
email: kevin.schaefer@arcadis.com

<p><b>STRUCTURAL ENGINEER FOR BILDING 2</b></p>  <p><b>JEZERINAC</b> GROUP</p> <p><b>JEZERINAC GROUP</b> 1615 FORUM PL. 3A, WEST PALM BEACH, FL 33401 TEL: (561) 323-7222 CONTACT: BILLY RAVIOLA email: braviola@jezerinacgroup.com</p>	<p><b>STRUCTURAL ENGINEER FOR CAMPUIS</b></p>  <p><b>LAKDAS/O'HALEEM ENGINEERING INC.</b> 2211 N 54TH STREET FORT LAUDERDALE, FL 33308 (954) 777-6570 CONTACT: LAKDAS NANAYAKKARA EMAIL: LYE@LYENGINEERING.COM</p>
--	---

MEPPF:  
 Smith Engineering  
 Consultants, Inc.  
 SMITH ENGINEERING CONSULTANTS  
 2161 PALM BEACH LAKES BLVD  
 SUITE 312  
 WEST PALM BEACH, FL 33403  
 (561) 616-3911  
 contact: STEVE P. HOCKMAN  
[steve@smithengineeringconsultants.com](mailto:steve@smithengineeringconsultants.com)

SEAL

NOT TO BE FILED FOR RECORD UNLESS SIGNED AND DATED  
WITH THE ORIGINAL SEAL OF PATRICIA F. RAMUDO,  
FLORIDA P.E. #35798 FOR THE FIRM.

PRIME CONSULTANT



7000 N Federal Highway  
Boca Raton FL 33487 USA  
tel 561 393 6555  
[www.arcadis.com](http://www.arcadis.com)

PROJECT  
COPANS TRANSIT  
OPERATIONS FACILITY  
3201 W Copans Road  
Pompano Beach, FL

PROJECT NO:  
136677

DRAWN BY: CMP/JAR	CHECKED BY: PFR
SCALE: 1" = 40'	APPROVED BY: PFR

SHEET TITLE

## SITE PLAN

SHEET NUMBER	ISSUE
MSP1.2	H

File Location: C:\Users\pencecd\38\ARCAD\SI\136677 Copans Transit Operations Facility - Internal Documents\17.03\_Production\17.03\_Design\04\_Civil\Sheets\136677-SP.dwg Last Saved: November 13, 2025, by pencecd0408 Plotted: Thursday, November 13, 2025 9:41:56 AM by Pence, Chris