

 

 


 

 











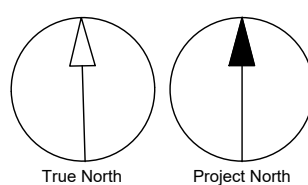


LEGEND

	PEDESTRIAN WOOD DECKING		PROPOSED ASPHALT
	PEDESTRIAN CONCRETE TYPE 1		EXISTING ASPHALT
	PEDESTRIAN CONCRETE TYPE 2		PROPOSED CONCRETE PVM
	PEDESTRIAN BRICK TYPE 1		EXISTING CONCRETE PVM
	STONE AGGREGATE SURFACE		FITNESS SURFACE B
	EXISTING SEWER PIPE		FUTURE PARCEL
	EXISTING WATER PIPE		PROPOSED SEWER PIPE
	EXISTING STORM PIPE		PROPOSED WATER PIPE
	EXISTING SEWER FORCE MAIN		PROPOSED STORM PIPE
	EXISTING BUILDING FOOTPRINT (TO BE DEMOLISHED)		PROPOSED EXFIL TRENCH W/ 24" SLOTTED RCP (SRCP)
	50' OFFSET (EXISTING BUILDING FOOTPRINT)		



CLIENT  **BROWARD**
COUNTY
Transit

1 N University Dr, Plantation, FL, 33324

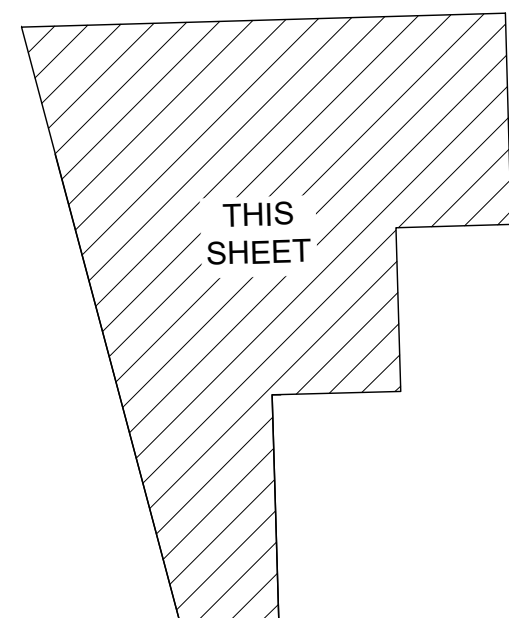
COPYRIGHT

This drawing has been prepared solely for the intended use, thus any reproduction or distribution for any purpose other than authorized by Arcadis is forbidden. Written dimensions shall have precedence over scaled dimensions. Contractors shall verify and be responsible for all dimensions and conditions on the job, and Arcadis shall be informed of any variations from the dimensions and conditions shown on the drawing. Shop drawings shall be submitted to Arcadis for general conformance before proceeding with fabrication.

Arcadis Professional Services (USA) Inc.

ISSUES		
No.	DESCRIPTION	DATE
A	SCHEMATIC DESIGN	2023-08-31
B	DD RELEASE	2024-03-29
C	DR RELEASE	2024-05-29
D	50% CD PRICING RELEASE	2024-07-17
E	80% CD RELEASE	2024-10-14
F	DRC #3 RESUBMITTAL	2024-11-13
G	100% CD RELEASE	2024-12-16
H	ISSUED FOR SPA - MOD	2025-11-12

KEYPLANS



CONSULTANTS

ARCHITECT:

ARCADIS

7000 N FEDERAL HWY - 2ND FLOOR
BOCA RATON, FL 33487
(561) 394-8000
email: jenny.kelly@arcadis.com

LANDSCAPE ARCHITECT:

CLACKMAN

ARCADIS
21 CUSTOM HOUSE ST - 3RD FLOOR
RALEIGH, NC 27601
(919) 896-2000
email: phil.coleman@arcadis.com
phil.coleman@arcadis.com

STRUCTURAL ENGINEER FOR BUILDINGS:

JEEZERING

2100 N. UNIVERSITY BLVD
WEST PALM BEACH, FL 33411
(561) 325-7270
CONTACT: BILLY RALPH

CIVIL ENGINEER:

ARCADIS

7000 N FEDERAL HWY - 2ND FLOOR
BOCA RATON, FL 33487
(561) 394-8000
email: patricia.ramirez@arcadis.com
patricia.ramirez@arcadis.com

SITE ELECTRICAL:

CLACKMAN

ARCADIS
421 FAYETTEVILLE STREET
RALEIGH, NC 27601
(919) 896-2000
CONTACT: NIKKI SCHAFER
nikki.schaffer@arcadis.com

STRUCTURAL ENGINEER FOR CIVIL:

JEEZERING

2100 N. UNIVERSITY BLVD
WEST PALM BEACH, FL 33411
CONTACT: LAJANDRA M. FL3308
LAJANDRA@JEEZERING.COM
CONTACT: LAJANDRA M. FL3308
LAJANDRA@JEEZERING.COM

SEAL

NOT TO BE FILED FOR RECORD UNLESS SIGNED AND DATED
WITH THE ORIGINAL SEAL OF PATRICIA F. RAMUDO,
FLORIDA P.E. #35798 FOR THE FIRM.

PRIME CONSULTANT



7000 N Federal Highway
Boca Raton FL 33487 US
tel 561 393 6555
www.arcadis.com

**TRANSIT
FACILITY**
ns Road
ach, FL

PROJECT NO
136677

DRAWN BY
CMP/JAR

SCALE:
1" = 80'

SHEET TITLE

100

P,

&

SHEET NUM

100

MASTER PLAN, GRADING, DRAINAGE PLAN

C4.0

H

FILE LOCATION: J:\1365677 Copiers Trans\7 0 Production\7 03 Design\04 Civil\Sheet\1365677-PCP.dwg Last Saved: November 13, 2025 by pence0438 Plotted: Thursday, November 13, 2025 9:43:02 AM by Pence Chris