

DRC

PZ25- 12000042
12/17/2025

MATCHLINE SHEET PS1.2

MATCHLINE SHEET PS1.1

TRINPIKE

BUILDING

EXISTING
WASH
BUILDING

DOWNLINE AREA
(APPROXIMATE LIMITS)

TREE LEGEND

LARGE PALMS

Phoenix dactylifera "Medjool" /
Medjool Date Palm

Roystonea regia /
Royal Palm

MEDIUM PALMS

Sabal palmetto /
Cabbage Palm

Veitchia montgomeryana
/ Montgomery Palm

SMALL PALMS

Thryxax radiata /
Florida Thatch Palm

TREE LEGEND

LARGE CANOPY TREES

Delonix regia /
Royal Poinciana

Bursera simaruba /
Gumbo Limbo

Quercus virginiana /
Live Oak

Tabebuia heterophylla /
Pink Tabebuia

Tabebuia heterophylla /
Pink Tabebuia

Taxodium distichum /
Bald Cypress

Preserved Tree

MEDIUM TREES

Chrysophyllum oliviforme /
Starfruit

Conocarpus erectus /
Green Buttonwood

Clusia rosea /
Pitch Apple

Tabebuia caribaea /
Yellow Tabebuia

Conocarpus erectus "Sericeus" /
Silver Buttonwood

Myrsine fragrans /
Simpson Stopper

PUBLIC SAFETY AND
SECURITY LEGEND:



CODE BLUE
EMERGENCY TOWER

CLIENT

BROWARD
COUNTY
Transit

1 N University Dr, Plantation, FL, 33324

COPYRIGHT


This drawing has been prepared solely for the intended use, thus any reproduction or distribution for any purpose other than authorized by Arcadis is forbidden. Written dimensions shall have precedence over scaled dimensions. Contractors shall verify and be responsible for all dimensions and conditions on the job, and Arcadis shall be informed of any variations from the dimensions and conditions shown on the drawing. Shop drawings shall be submitted to Arcadis for general conformance before proceeding with fabrication.

Arcadis Professional Services (USA) Inc.

ISSUES

No.	DESCRIPTION	DATE
B	DD RELEASE	2024-03-29
C	DRC RELEASE	2024-05-29
E	80% CD RELEASE	2024-10-14
G	100% CD RELEASE	2024-12-16
H	QA/QC-2 RELEASE	2025-10-17
I	ISSUE FOR SPA-MOD	2025-11-12

KEYPLANS

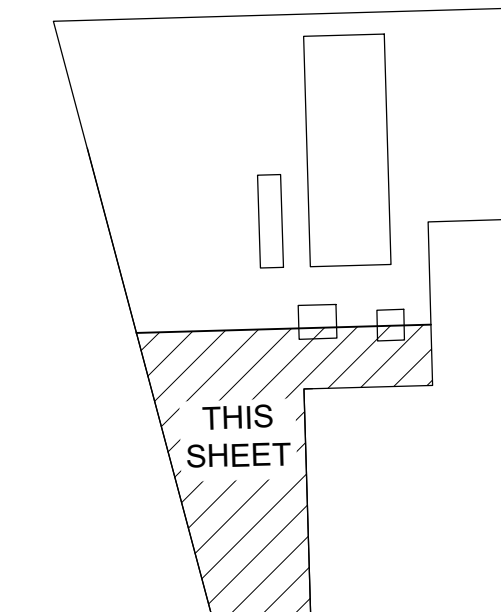

CONSULTANTS

ARCADIS ARCADIS INC. 7000 N FEDERAL HWY - 2ND FLOOR BOCA RATON, FL 33487 (561) 996-8000 www.arcadis.com contact: JORGE GARCIA email: jorge.garcia@arcadis.com	ARCADIS ARCADIS INC. 7000 N FEDERAL HWY - 2ND FLOOR BOCA RATON, FL 33487 (561) 996-8000 www.arcadis.com contact: PATRICIA RAMILLO email: patricia.ramill@arcadis.com
ARCADIS ARCADIS INC. 21 CUSTOM HOUSE ST - 3RD FLOOR BOSTON, MA 02110 (617) 885-2000 www.arcadis.com contact: FRANK COLLIERAN email: frank.collieran@arcadis.com	ARCADIS ARCADIS INC. 421 FAIRVIEW ST - 3RD FLOOR SUITE 310 RALEIGH, NC 27601 (919) 851-3411 www.arcadis.com contact: KEVIN SCHAFER email: kevin.schaf@arcadis.com

STRUCTURAL ENGINEER

SMITH ENGINEERING CONSULTANTS SMITH ENGINEERING CONSULTANTS 2161 PALM BEACH LAKES BLVD SUITE 310 WEST PALM BEACH, FL 33403 (561) 835-3011 www.smitheng.com contact: STEVE P. HODGMAN email: steve@smitheng.com	SMITH ENGINEERING CONSULTANTS SMITH ENGINEERING CONSULTANTS 2161 PALM BEACH LAKES BLVD SUITE 310 WEST PALM BEACH, FL 33403 (561) 835-3011 www.smitheng.com contact: STEVE P. HODGMAN email: steve@smitheng.com
---	---

SEAL

NOT TO BE FILED FOR RECORD UNLESS SIGNED AND DATED
WITH THE ORIGINAL SEAL OF DESPRA L. HERNANDEZ,
FLORIDA L.A. #6666975 FOR THE FIRM

PRIME CONSULTANT

ARCADIS
7000 N Federal Highway
Boca Raton FL 33487 USA
tel 561 333 6555
www.arcadis.com
ENGINEERS CERT. OF AUTH. 0008
LANDSCAPE LC #0000070

PROJECT
COPANS TRANSIT
OPERATIONS FACILITY
3201 W Copans Road
Pompano Beach, FL

PROJECT NO:
136677

DRAWN BY:
DLH

PROJECT MGR:
1" = 30'

SHEET TITLE
PUBLIC SAFETY AND
SECURITY PLAN S

SHEET NUMBER
PS1.3

ISSUE
1

CONFIDENTIAL

