 



PZ26-12000009
07/15/2026




2371 NW 2ND ST,
POMPANO BEACH,
FL 33069.

Consultant
Address
Address
Phone
Fax
e-mail

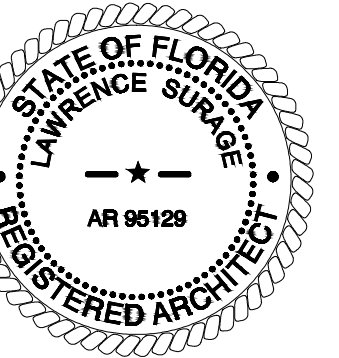

Consultant
Address
Address
Phone
Fax
e-mail

Consultant
Address
Address
Phone
Fax
e-mail

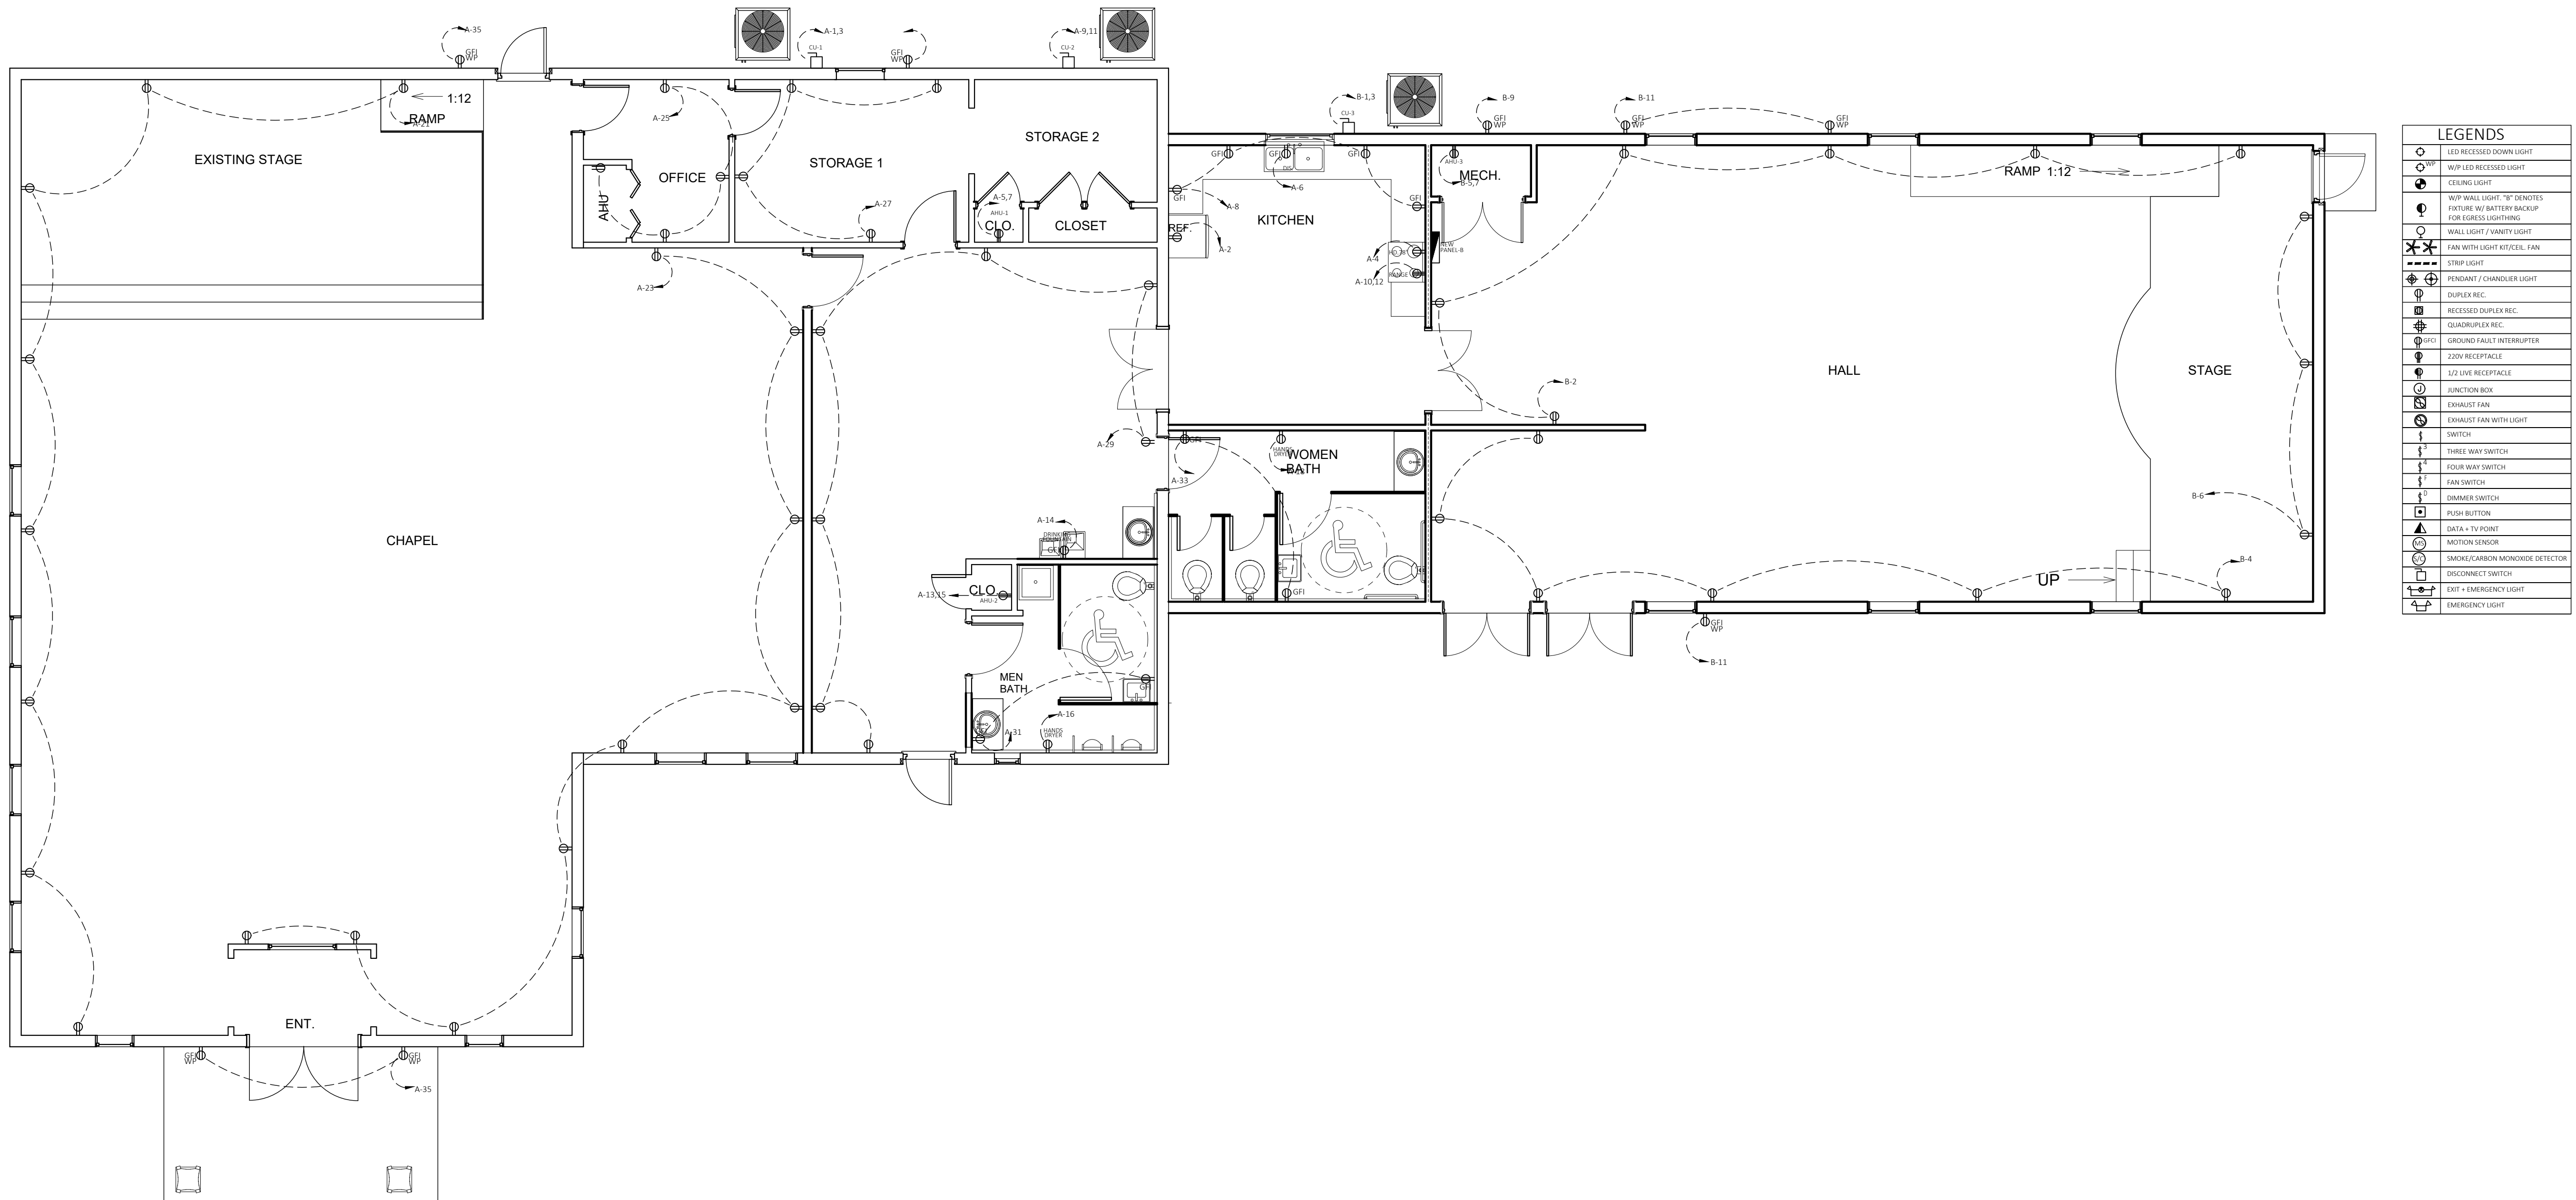

 ELECTRICAL POWER PLAN
SCALE: 3/16"=1'

[illegible]

HOUSE OF GOD

ELECTRICAL POWER PLAN

Project number	P-78482
Date	10-23-2025
Drawn by	DONDIEGO MAURICE
Checked by	

E-101

Scale 1/8" = 1'-0"