
 
 
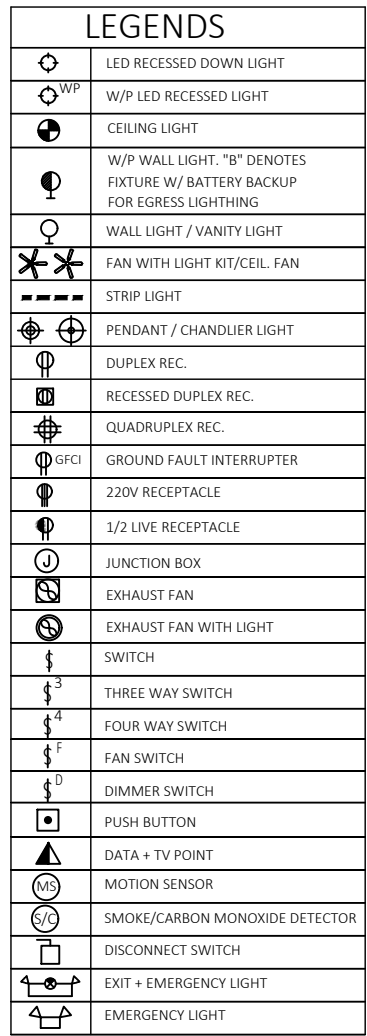




SCALE: 3/16"=1'



2371 NW 2ND ST,
POMPANO BEACH,
FL 33069.

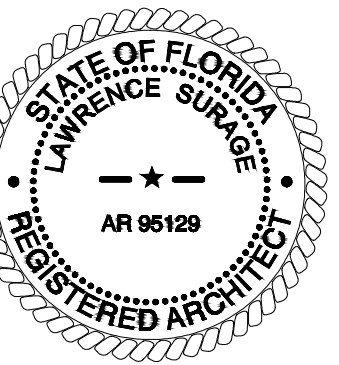

Consultant
Address
Address
Phone
Fax
e-mail

Consultant
Address
Address
Phone
Fax
e-mail

Consultant
Address
Address
Phone
Fax
e-mail

[illegible]

ELECTRICAL LIGHTING PLAN

Project number	P-78482
Date	10-23-2025
Drawn by	DONDIEGO MAURICE
Checked by	

E-102

Scale $1/8" = 1'-0"$