 



PZ26-12000009
07/15/2026



RENOVATION

 

2371 NW 2ND ST,
POMPANO BEACH,
FL 33069.

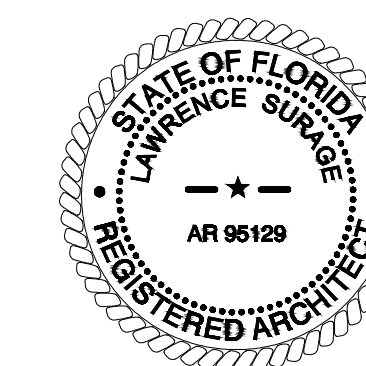

Consultant
Address
Address
Phone
Fax
e-mail

Consultant
Address
Address
Phone
Fax
e-mail

Consultant
Address
Address
Phone
Fax
e-mail

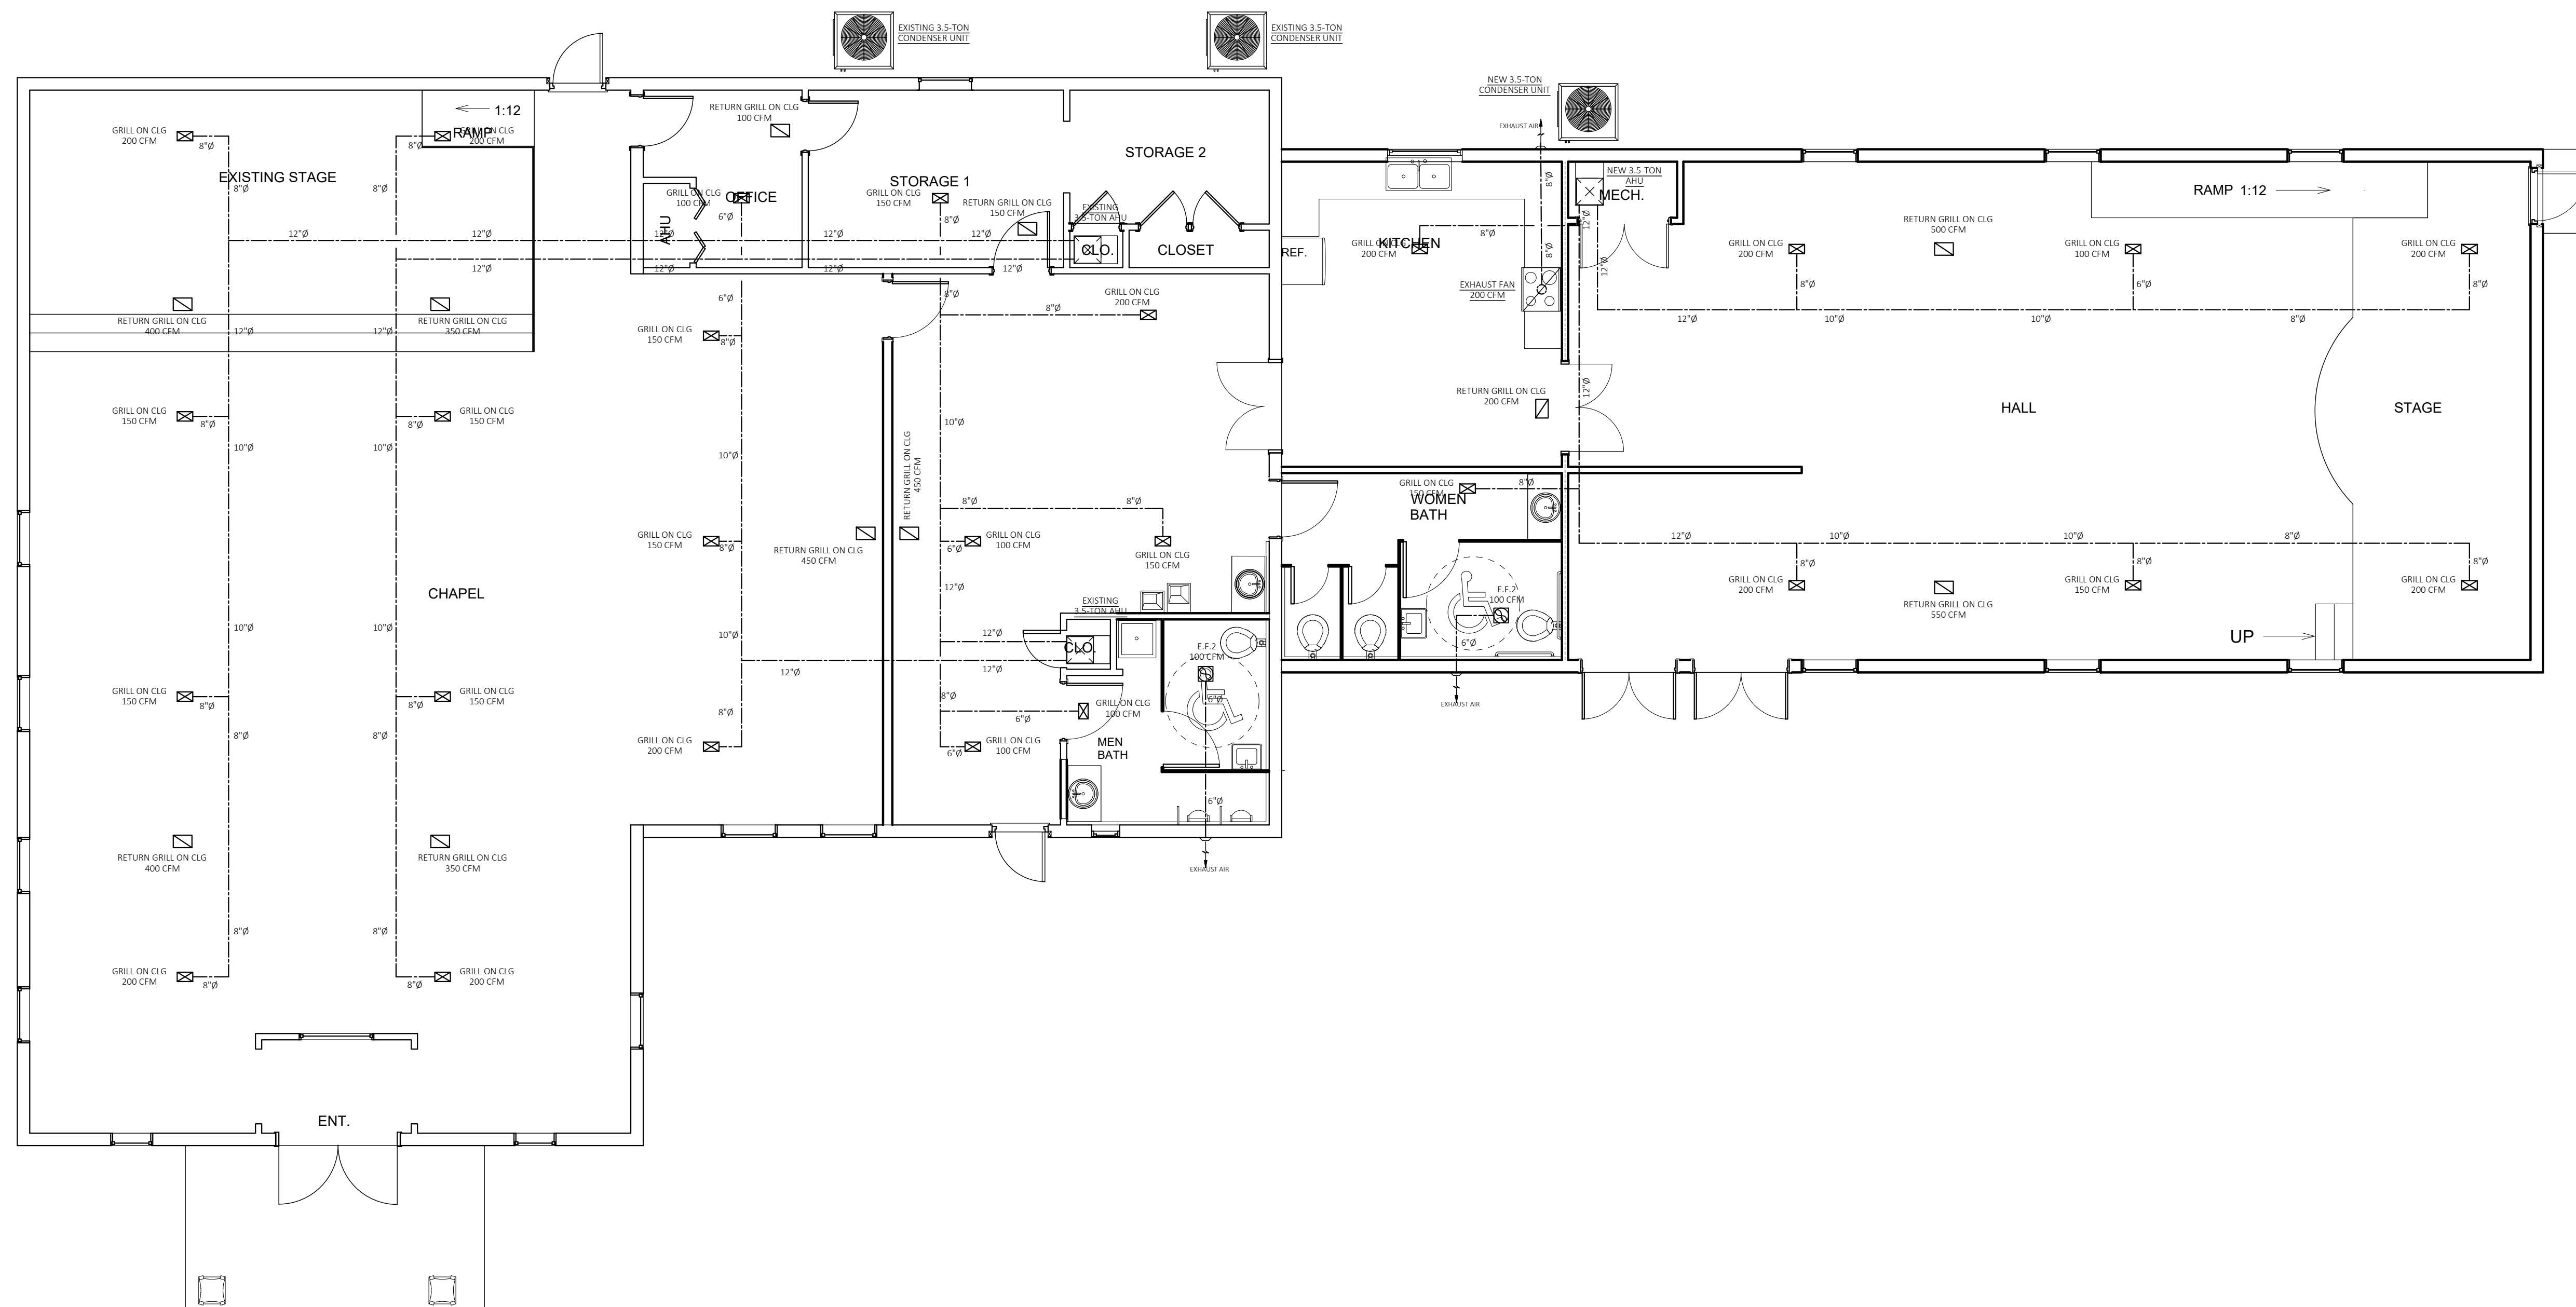

MECHANICAL PLAN

SCALE: 3/16"=1'

[illegible]

HOUSE OF GOD

MECHANICAL PLAN

Project number	P-78482
----------------	---------

Date	10-23-2025
------	------------

Date	10-20-2020
Drawn by	DONDIEGO MAURICE

Checked by	
------------	--

M-101

Scale 1/8" = 1'-0"