 



PZ26-12000009
07/15/2026




RENOVATION

2371 NW 2ND ST,
POMPANO BEACH,
FL 33069.

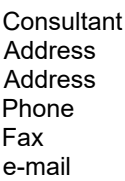

Consultant
Address
Address
Phone
Fax
e-mail

Consultant
Address
Address
Phone
Fax
e-mail

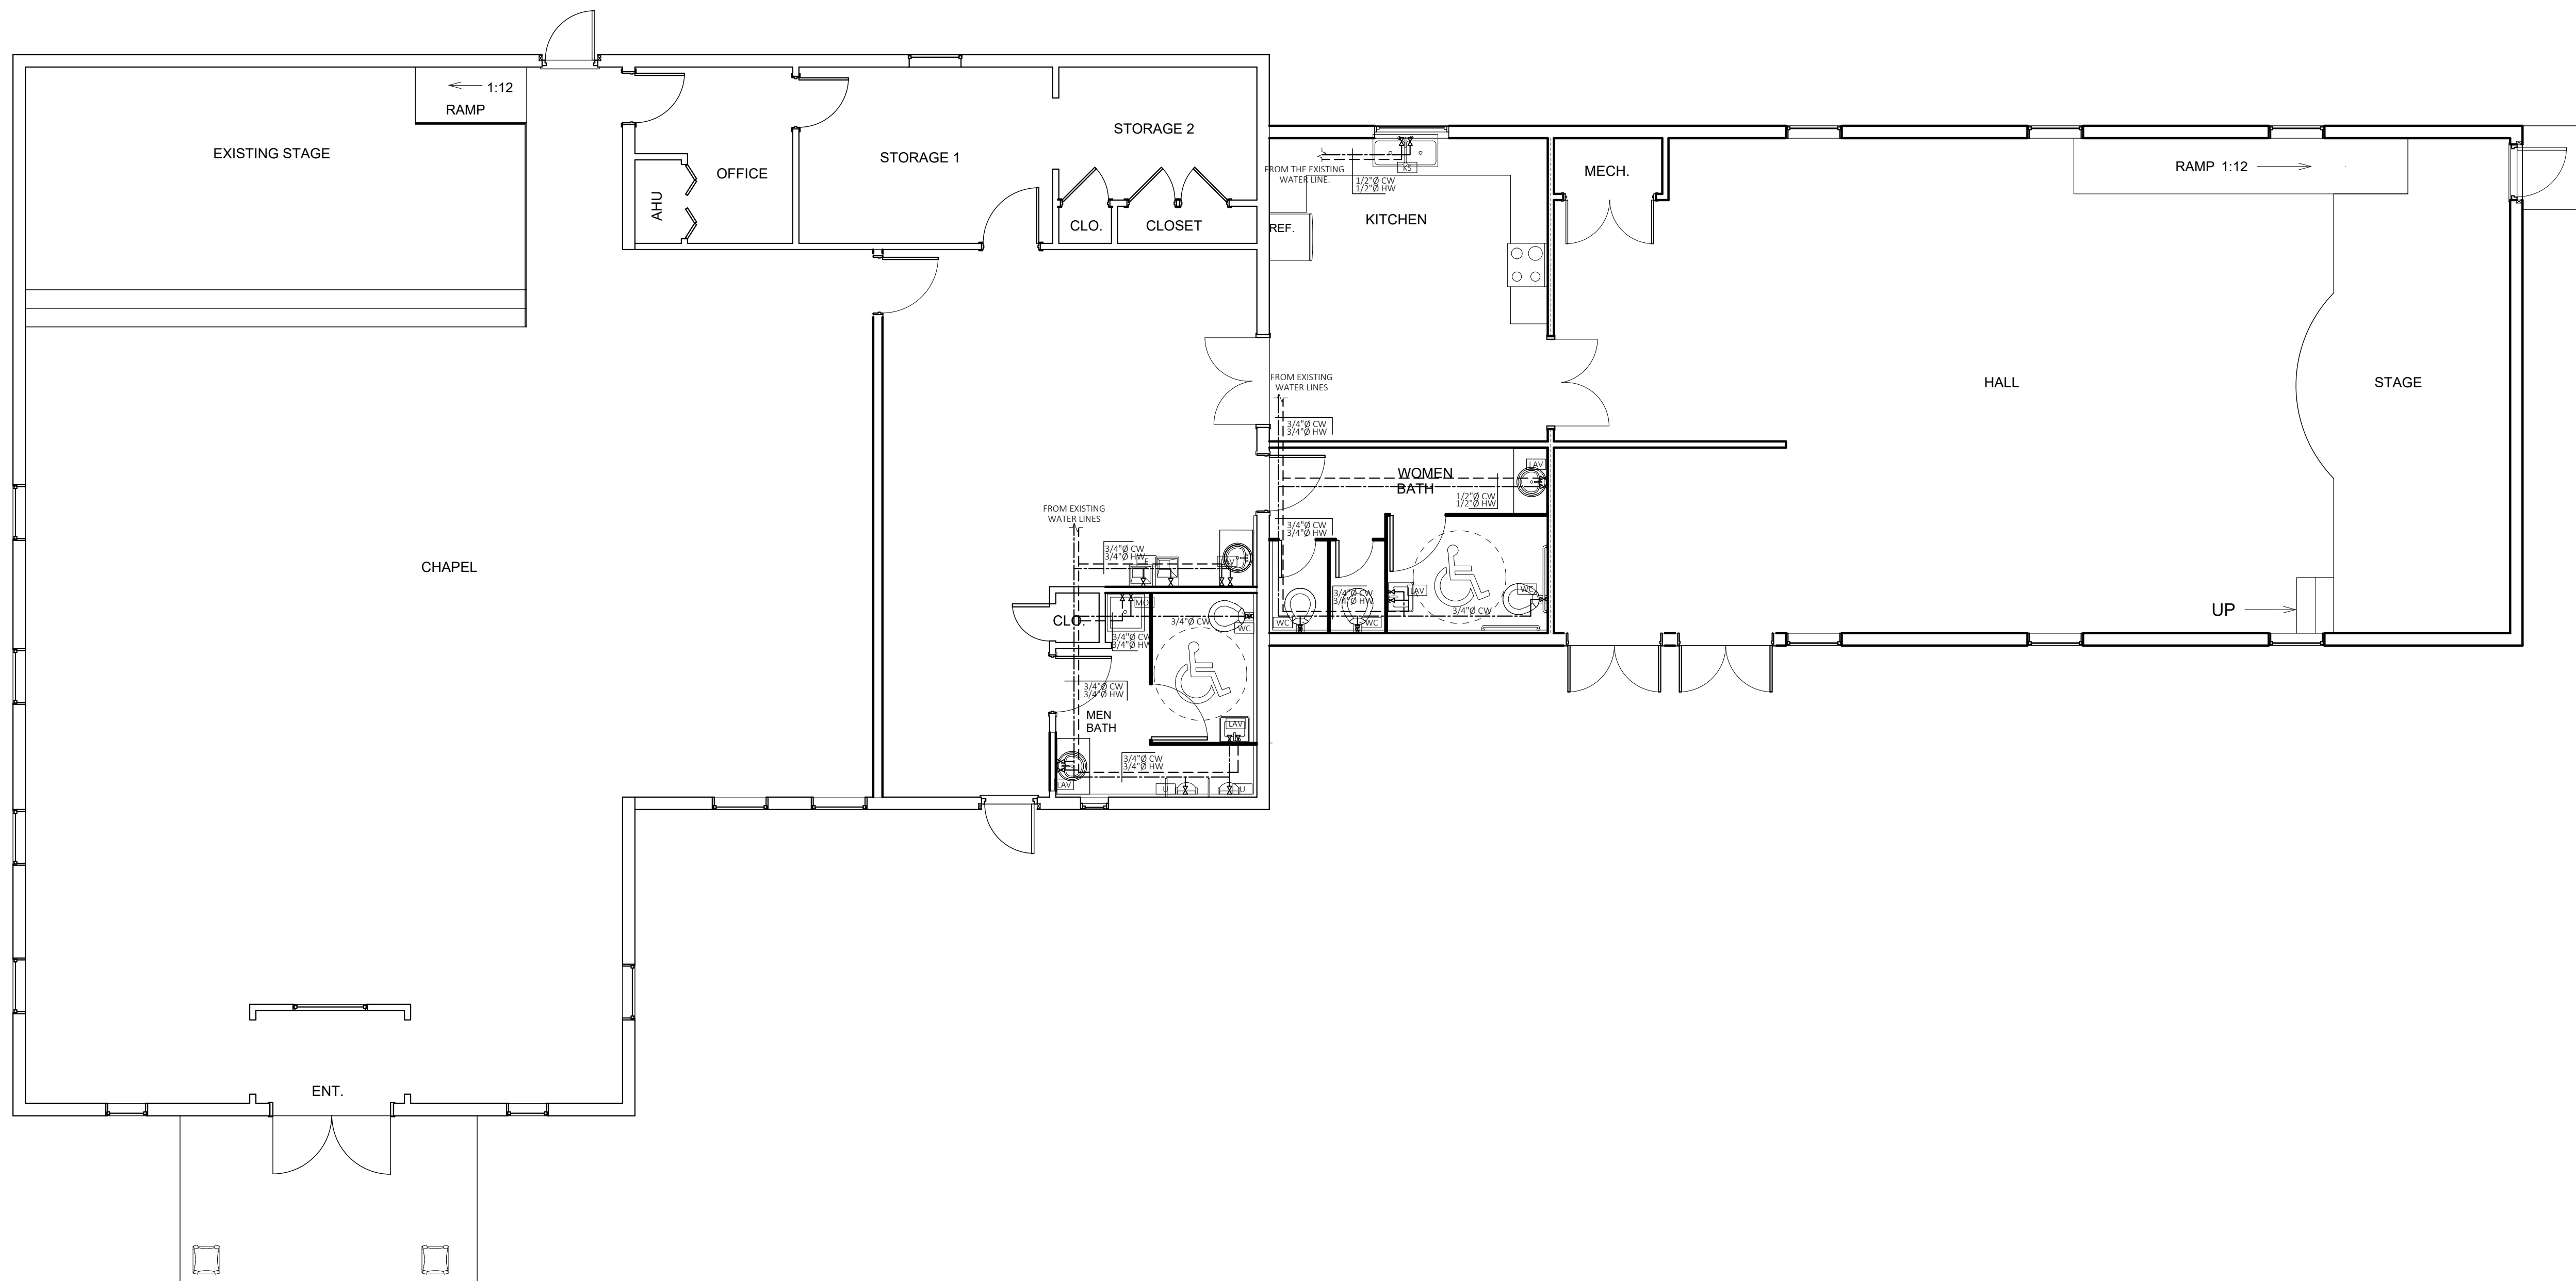

PLUMBING LEGEND & ABB.	
SYMBOL	DESCRIPTION
	COLD WATER (CW)
	HOT WATER (HW)
	HOT WATER RETURN (HWR)
	SANITARY SEWER LINE (S)
	VENT LINE (V)
	GAS (GAS LINE) (GS)
	GATE VALVE (G.V.)
	BALANCE VALVE (B.V.)
	CHECK VALVE (C.V.)
	SHUT OFF VALVE (S.O.V.)
	GAS VALVE (GAS V.)
	UNION
	NOSE BIBB (N.B.)
	BACKFLOW PREVENTER (B.F.P.)
	DRAIN DRAIN (F.D.)
	P-TRAP
	CLEANOUT
	DOUBLE CLEANOUT
	FLOOR CLEANOUT
	WALL CLEANOUT
	CLEANOUT TO GRADE
	PRESSURE RELIEF VALVE
	VACUUM RELIEF VALVE
	AUTOMATIC AIR VENT
	AUTOMATIC AIR VENT
	VENT THROUGH ROOF
	WATER HEATER
	WATER METER
	RECALCULATION PUMP
	PIN TO ALLOW
	PIN TO ALLOW
	TO BELOW
	TO ABOVE
	FROM BELOW
	FROM ABOVE
	HIGH LEVEL
	LOW LEVEL

[illegible]

HOUSE OF GOD

PLUMBING WATER PLAN

Project number	P-78482
----------------	---------


Date 10-23-2025

Drawn by **DONDIEGO MAURICE**

Checked by

P-101

 Scale 1/8" = 1'-0"



PLUMBING WATER PLAN

SCALE: $3/16"=1$