 



PZ26-12000009
07/15/2026



2371 NW 2ND ST,
POMPANO BEACH,
FL 33069.

Consultant
Address
Address
Phone
Fax
e-mail

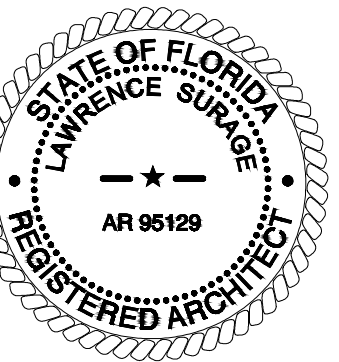

Consultant
Address
Address
Phone
Fax
e-mail

Consultant
Address
Address
Phone
Fax
e-mail


[illegible]

PLUMBING SANITARY PLAN


Project number	P-78482
Date	10-23-2025
Drawn by	DONDIEGO MAURICE
Checked by	

P-102

Scale $1/8" = 1'-0"$

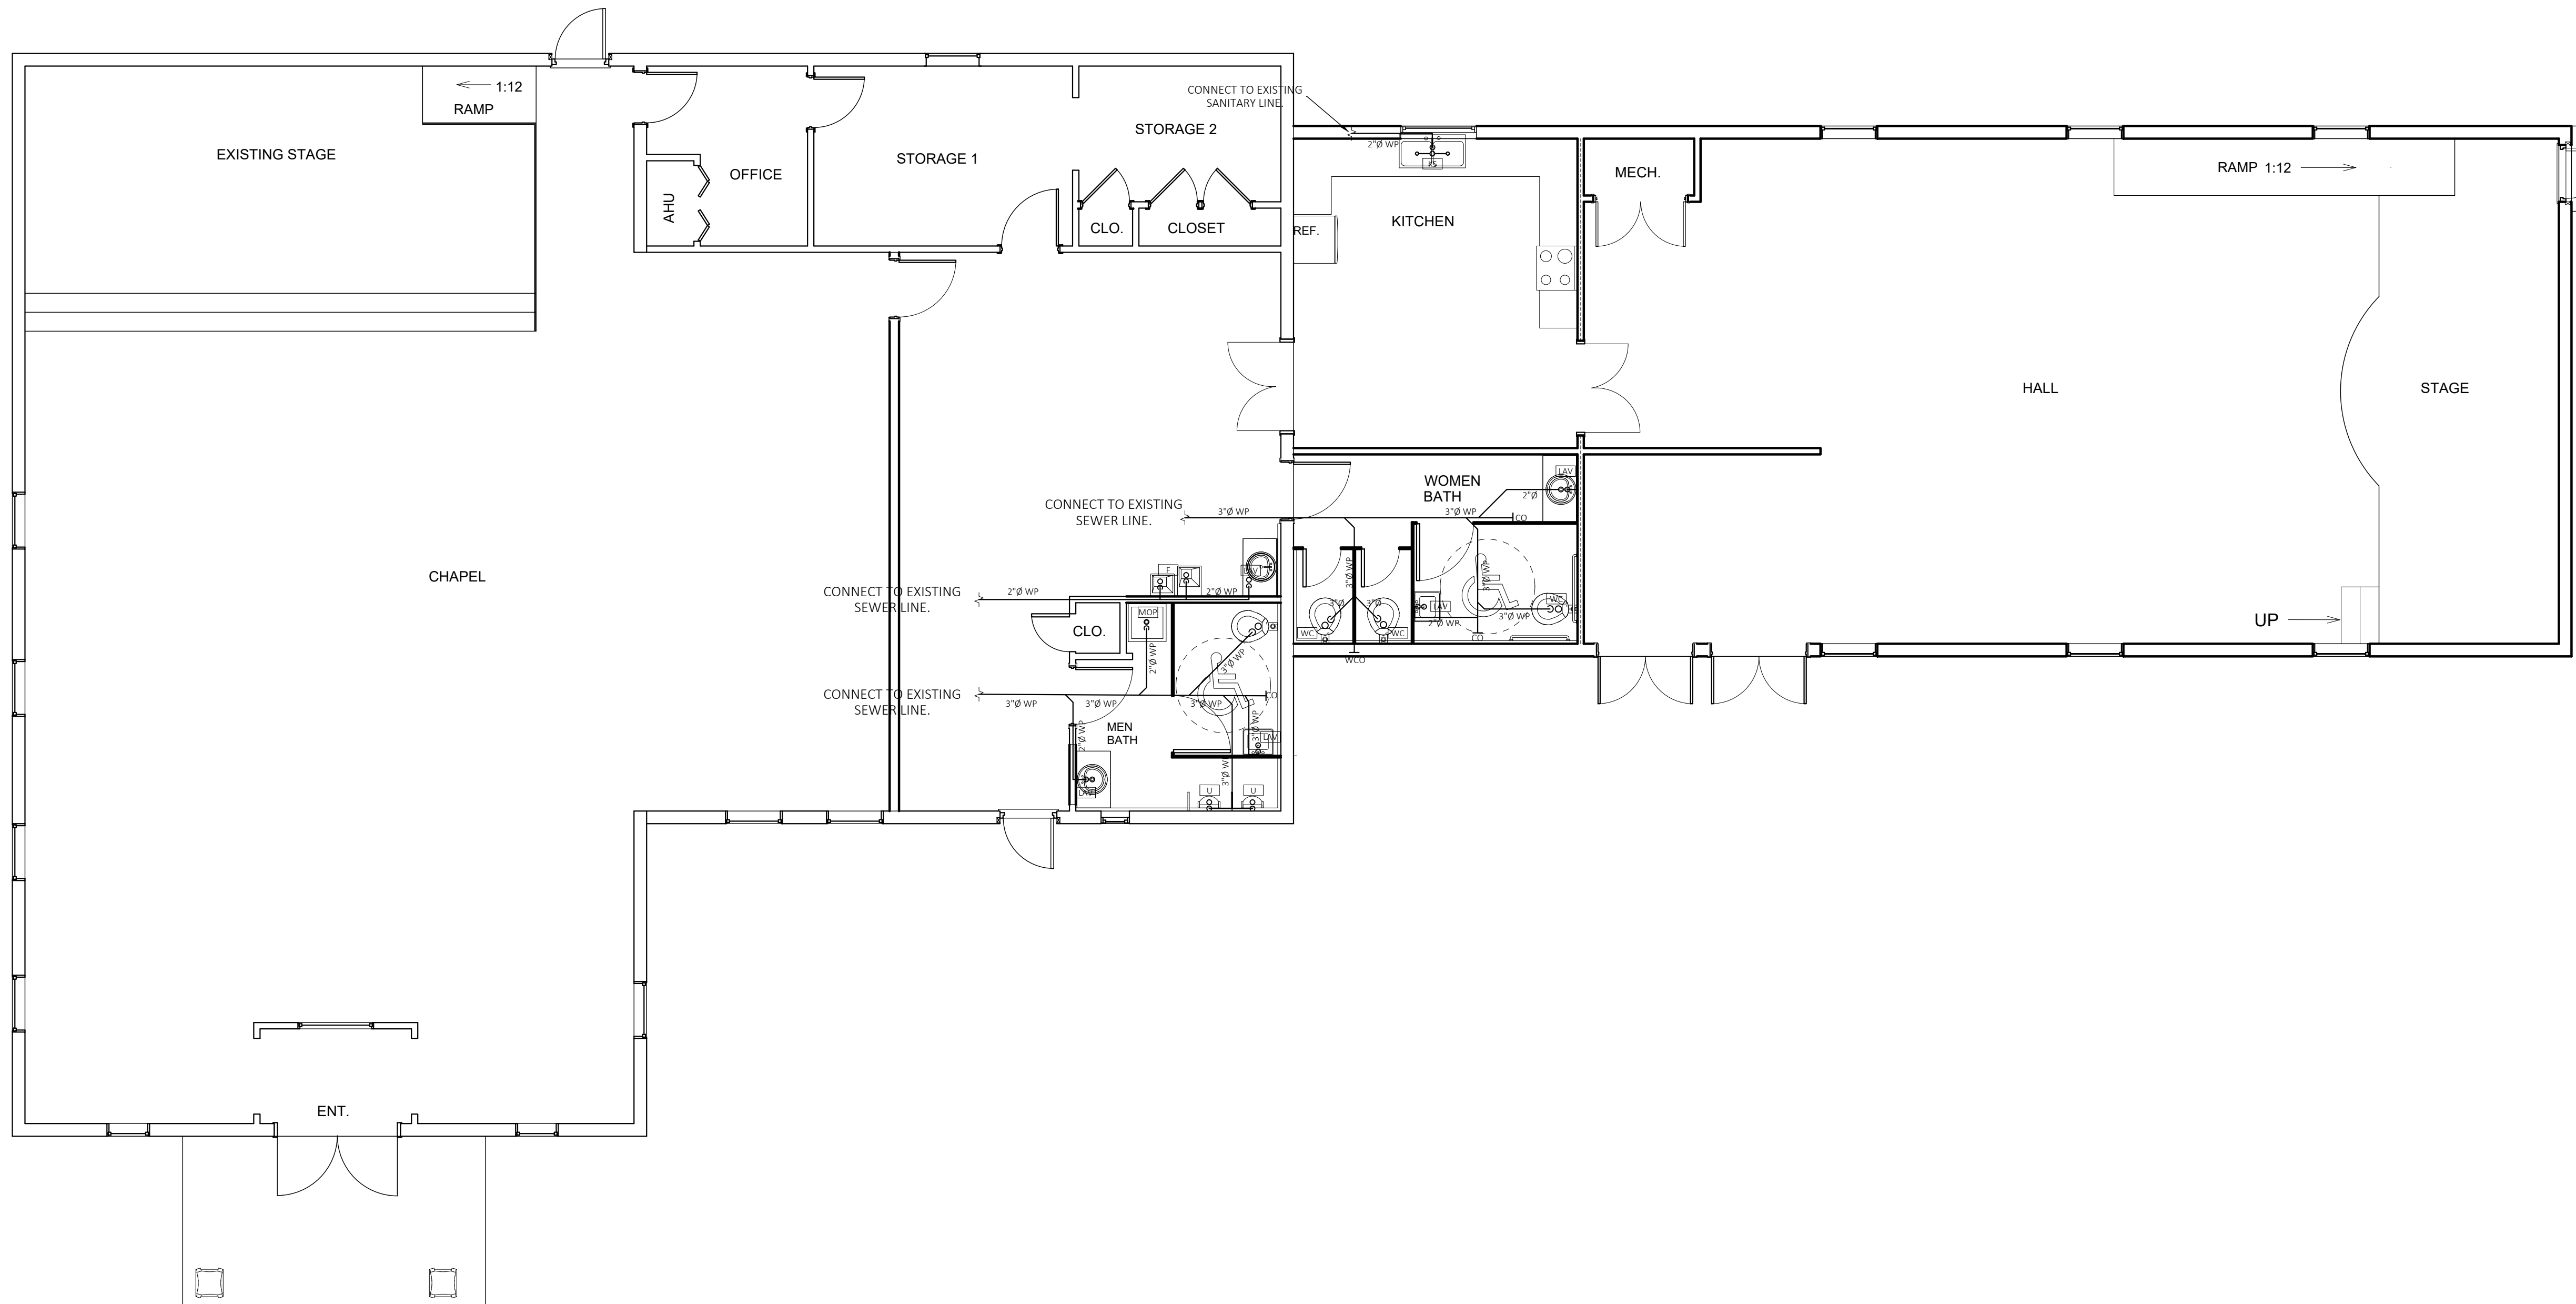

PLUMBING LEGEND & ABB.	
SYMBOL	DESCRIPTION
	COLD WATER (CW)
	HOT WATER (HW)
	HOT WATER RETURN (HWR)
	SEWERY SEWER LINE (S)
	VENT LINE (V)
	GAS LINE (GAS)
	GATE VALVE (GV)
	BALANCE VALVE (B.V.)
	CHECK VALVE (V.)
	SHUT OFF VALVE (S.O.V.)
	GAS VALVE (GAS.V.)
	UNION
	HOSE BIBB (H.B.)
	BACKFLOW PREVENTER (B.F.P.)
	FLOOR DRAIN (FD)
	P-TRAP
	CLEANOUT
	DOUBLE CLEANOUT
	FLOOR CLEANOUT
	WALL CLEANOUT
	CLEANOUT TO GRADE
	PRESSURE RELIEF VALVE
	VACUUM RELIEF VALVE
	AUTOMATIC AIR VENT
	AUTOMATIC AIR VENT
	VENT THROUGH ROOF
	WATER HEATER
	WATER METER
	RECALCULATION PUMP
	PIPE TO ABOVE
	PIPE TO BELOW
	TO ABOVE
	TO BELOW
	FROM ABOVE
	FROM BELOW
	HIGH LEVEL
	LOW LEVEL

 

PLUMBING SANITARY PLAN

SCALE: 3/16"=1'

PLUMBING SANITARY PLAN

Project number	P-78482
Date	10-23-2025
Drawn by	DONDIEGO MAURICE
Checked by	

P-102

Scale $1/8" = 1'-0"$