


# GROUND LEVEL PHOTOMETRICS

SCALE: 1/16" = 1'-0"

1  
PH-1

| Luminaire Schedule  |     |       |             |             |       |                 |             |
|---|-----|-------|-------------|-------------|-------|-----------------|-------------|
| Project: 10_3_2023 911 E. ATLANTIC, POMPAHO BCH - GND FLR |     |       |             |             |       |                 |             |
| Symbol  | Qty | Label | Arrangement | Lum. Lumens | LLD   | Luminaire Watts | Total Watts |
|   | 13  | G     | Single      | 4153        | 0.900 | 36              | 468         |
|   | 12  | GE    | Single      | 4153        | 0.900 | 36              | 432         |
|   | 1   | W     | Single      | 1567        | 0.900 | 12              | 12          |
| Description   |     |       |             |             |       |                 |             |

| Calculation Summary                                       |             |       |      |     |     |         |         |
|---|-------------|-------|------|-----|-----|---------|---------|
| Project: 10_3_2023 911 E. ATLANTIC, POMPAHO BCH - GND FLR |             |       |      |     |     |         |         |
| Label   | CalcType    | Units | Avg  | Max | Min | Avg/Min | Max/Min |
| OPEN ENTRANCE   | Illuminance | Fc    | 3.08 | 5.3 | 1.5 | 2.05    | 3.53    |
| PG - GND LVL  | Illuminance | Fc    | 3.63 | 5.8 | 1.2 | 3.03    | 4.83    |
| PROPERTY LINE - 5' AG                                     | Illuminance | Fc    | 0.04 | 1.2 | 0.0 | N.A.    | N.A.    |
| Grid Z  |             |       |      |     |     |         |         |

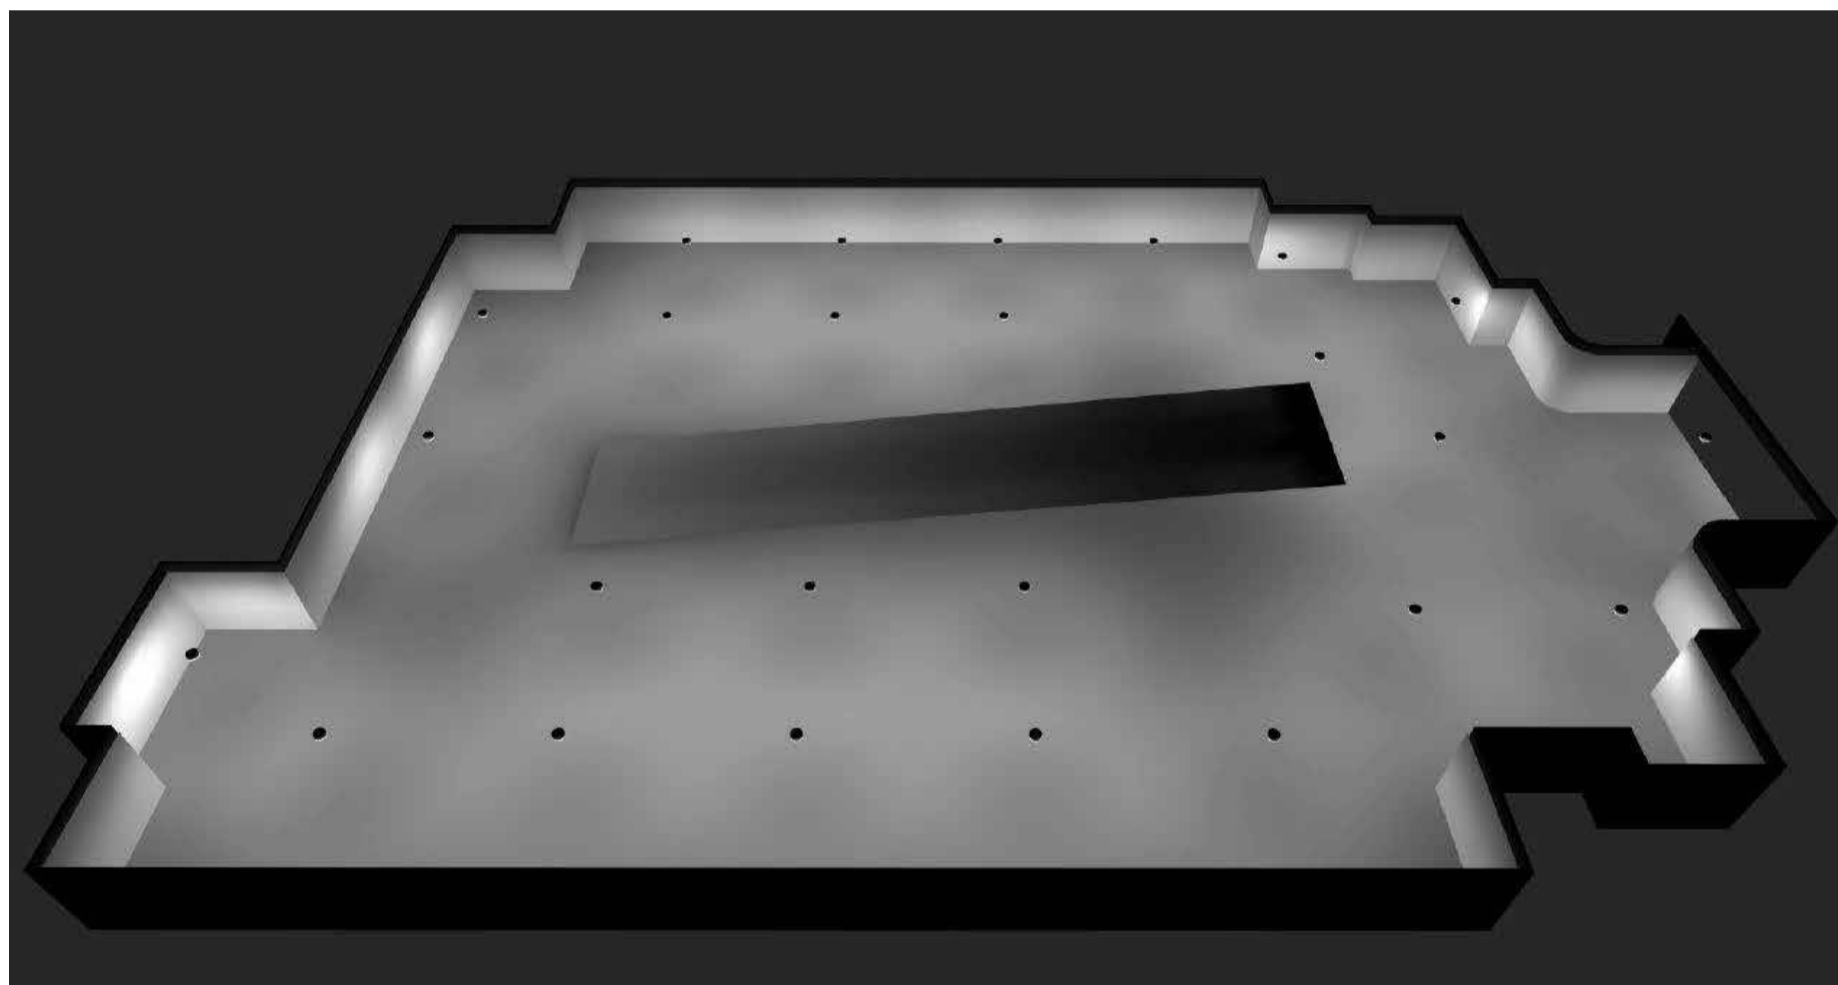

Digitally signed by Steven L. Cohen  
Date: 2024.03.05 16:52:08 -05'00'

Steven L. Cohen  
and Associates, P.A.  
Architects - Interior Designers  
5995 TOWN CENTER ROAD, SUITE 202  
BOCA RATON, FLORIDA 33486  
(954) 971-1010  
info@slcarchitects.com

PROJECT NAME:  
911 EAST ATLANTIC  
MIXED-USE PROJECT

PROJECT ADDRESS:  
911 EAST ATLANTIC BLVD, POMPAHO BEACH, FL 33060

DRAWING NAME:  
GROUND LEVEL PHOTOMETRICS

ALL LEGAL INSTRUMENTS AND PLANS INDICATED OR REPRESENTED BY THIS DRAWING ARE OWNED BY AND THE SUBMITTER TO THE OFFICE FOR APPROVAL BEFORE PROCEEDING WITH ANY CONSTRUCTION. THE SUBMITTER SHALL BE RESPONSIBLE FOR OBTAINING ALL NECESSARY PERMITS AND APPROVALS FROM THE APPROPRIATE AGENCIES. THE SUBMITTER SHALL BE RESPONSIBLE FOR OBTAINING ALL NECESSARY PERMITS AND APPROVALS FROM THE APPROPRIATE AGENCIES. THE SUBMITTER SHALL BE RESPONSIBLE FOR OBTAINING ALL NECESSARY PERMITS AND APPROVALS FROM THE APPROPRIATE AGENCIES.

Principal: SLC  
Project Manager: SDY  
Drawn by: JQ/VB

REVISIONS  
No DATE DESCRIPTION

Project No: 12622

Issue: 03/05/2024

Drawing No: PH-1

P&Z  
PZ23-12000043  
05/22/2024