
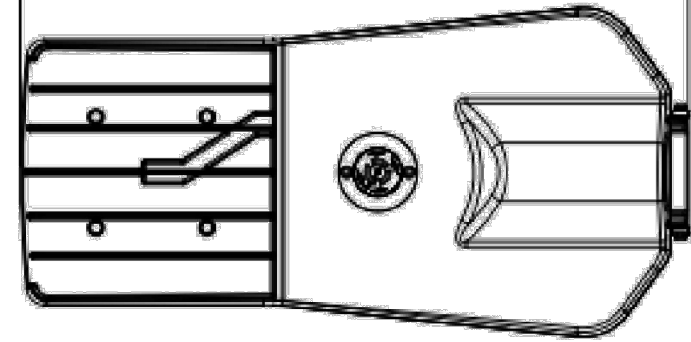



Calculation Summary							
Label	CalcType	Units	Avg	Max	Min	Avg/Min	Max/Min
PARKING LOT & DRIVEWAY	Illuminance	Fc	4.00	8.7	1.0	4.00	8.70
PROPERTY LINE	Illuminance	Fc	0.08	0.5	0.0	N.A.	N.A.
WALKWAY	Illuminance	Fc	5.83	8.5	2.0	2.92	4.25

Photometrics Calculation Software Generated Luminaire Schedule								
Symbol	Qty	Label	Arrangement	Lum. Lumens	Arr. Lum. Lumens	LLF	Lum. Watts	Arr. Watts
SA	16	SA	Single	25900	25900	0.900	189.4	189.4
SB	4	SB	Single	17830	17830	0.900	189.4	189.4

951 S ANDREWS AVE LIGHTING FIXTURE SCHEDULE										
TYPE	DESCRIPTION	MFR	CATALOG NUMBER	VOLTS	COLOR TEMP	LUMENS	LAMP S	WATTS	DIMMING	REMARKS
SA	SITE LUMINAIRE	STREETWORKS	ARCH3-190-740-U-T3-FINISH	UNV	4000K	25900	LED	189W	0-10V	NOTE 1
SB	SITE LUMINAIRE	STREETWORKS	ARCH3-190-740-U-T3-FINISH-HSS	UNV	4000K	17830	LED	189W	0-10V	NOTE 1
FIXTURE SCHEDULE NOTES										
GENERAL NOTE : ADVISE FINISH										
NOTE 1 : FIXTURES MOUNTED ON 25' CONCRETE POLE #US327II-S-8658 (TO BE CONFIRMED)										
FOR QUESTIONS PERTAINING TO THIS FIXTURE SCHEDULE PLEASE CONTACT STEVE SANDERS @ LIGHTING DYNAMICS - (954) 295-9766, SSANDERS@LIGHTINGDYNAMICS.COM										

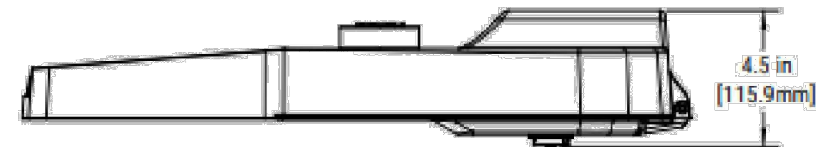


INSERT 1.75" (OD) MAST ARM  
OR 2.375" (OD) MAST ARM  
AFTER REMOVING KNOCKOUT

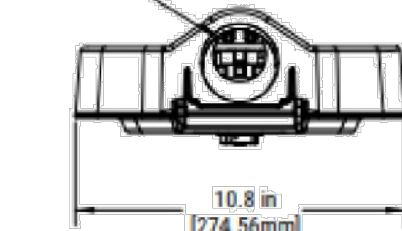

## 2 FIXTURE 'SA & SB' DETAIL

PLAN/SECTION


NOT TO SCALE

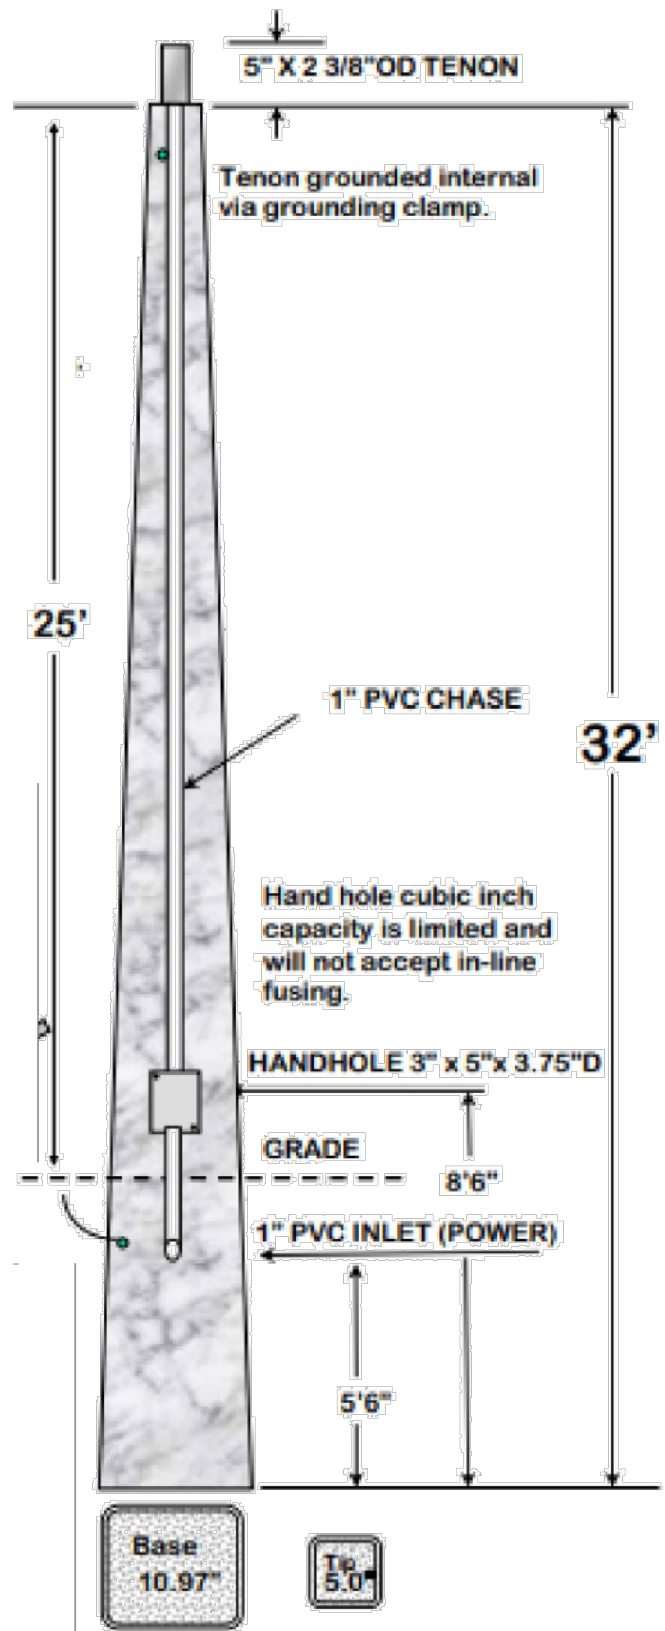


## 1 25' CONCRETE POLE

SECTION

NOT TO SCALE

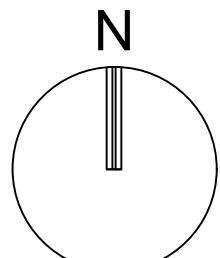

GRAPHIC SCALE

 

SCALE: 1" = 30'

NOTE: PRINTED DRAWING SIZE  
MAY HAVE CHANGED FROM  
ORIGINAL. VERIFY SCALE USING  
BAR SCALE ABOVE.



Florida Engineering Business License: CA7928  
Florida Surveyor and Mapper Business License: LB48680  
Florida Landscape Architecture Business License: LC26000457

REVISIONS		
NO.	DESCRIPTION	DATE

## PRELIMINARY PLAN NOT FOR CONSTRUCTION

THESE PLANS ARE NOT FULLY PERMITTED  
AND ARE SUBJECT TO REVISIONS MADE  
DURING THE PERMITTING PROCESS.

RESPONSIBILITY FOR THE USE OF THESE  
PLANS PRIOR TO OBTAINING PERMITS FROM  
ALL AGENCIES HAVING JURISDICTION OVER  
THE PROJECT WILL FALL SOLELY UPON THE  
USER.

ISSUE DATE: 11/12/2025

DESIGNED BY: KU, KS

DRAWN BY: KU

CHECKED BY: KU, KS

BID-CONTRACT:

PAUL H. WEINBERG, R.L.A.  
FLORIDA REG. NO. LA666804  
(FOR THE FIRM)

CLIENT

JADIAN IOS

PROJECT

951 SW 12th AVENUE  
POMPANO BEACH FL

SHEET TITLE

LIGHTING PLAN

SHEET NUMBER LL-101

PROJECT NUMBER 15427.00

STATUS: PRELIMINARY

Drawing name: H:\15427.00 - 951 S Andrews Ave - Jadian IOS\Landscape Architecture\CA015427.00 - LL-101.dwg  
Plotted by: Kurens On Wednesday, November 12, 2025 4:14:32 PM