


D

C

B

A

1 PHOTOMETRICS PLAN- GARAGE
A - 17 Scale: 1/16" = 1'-0"

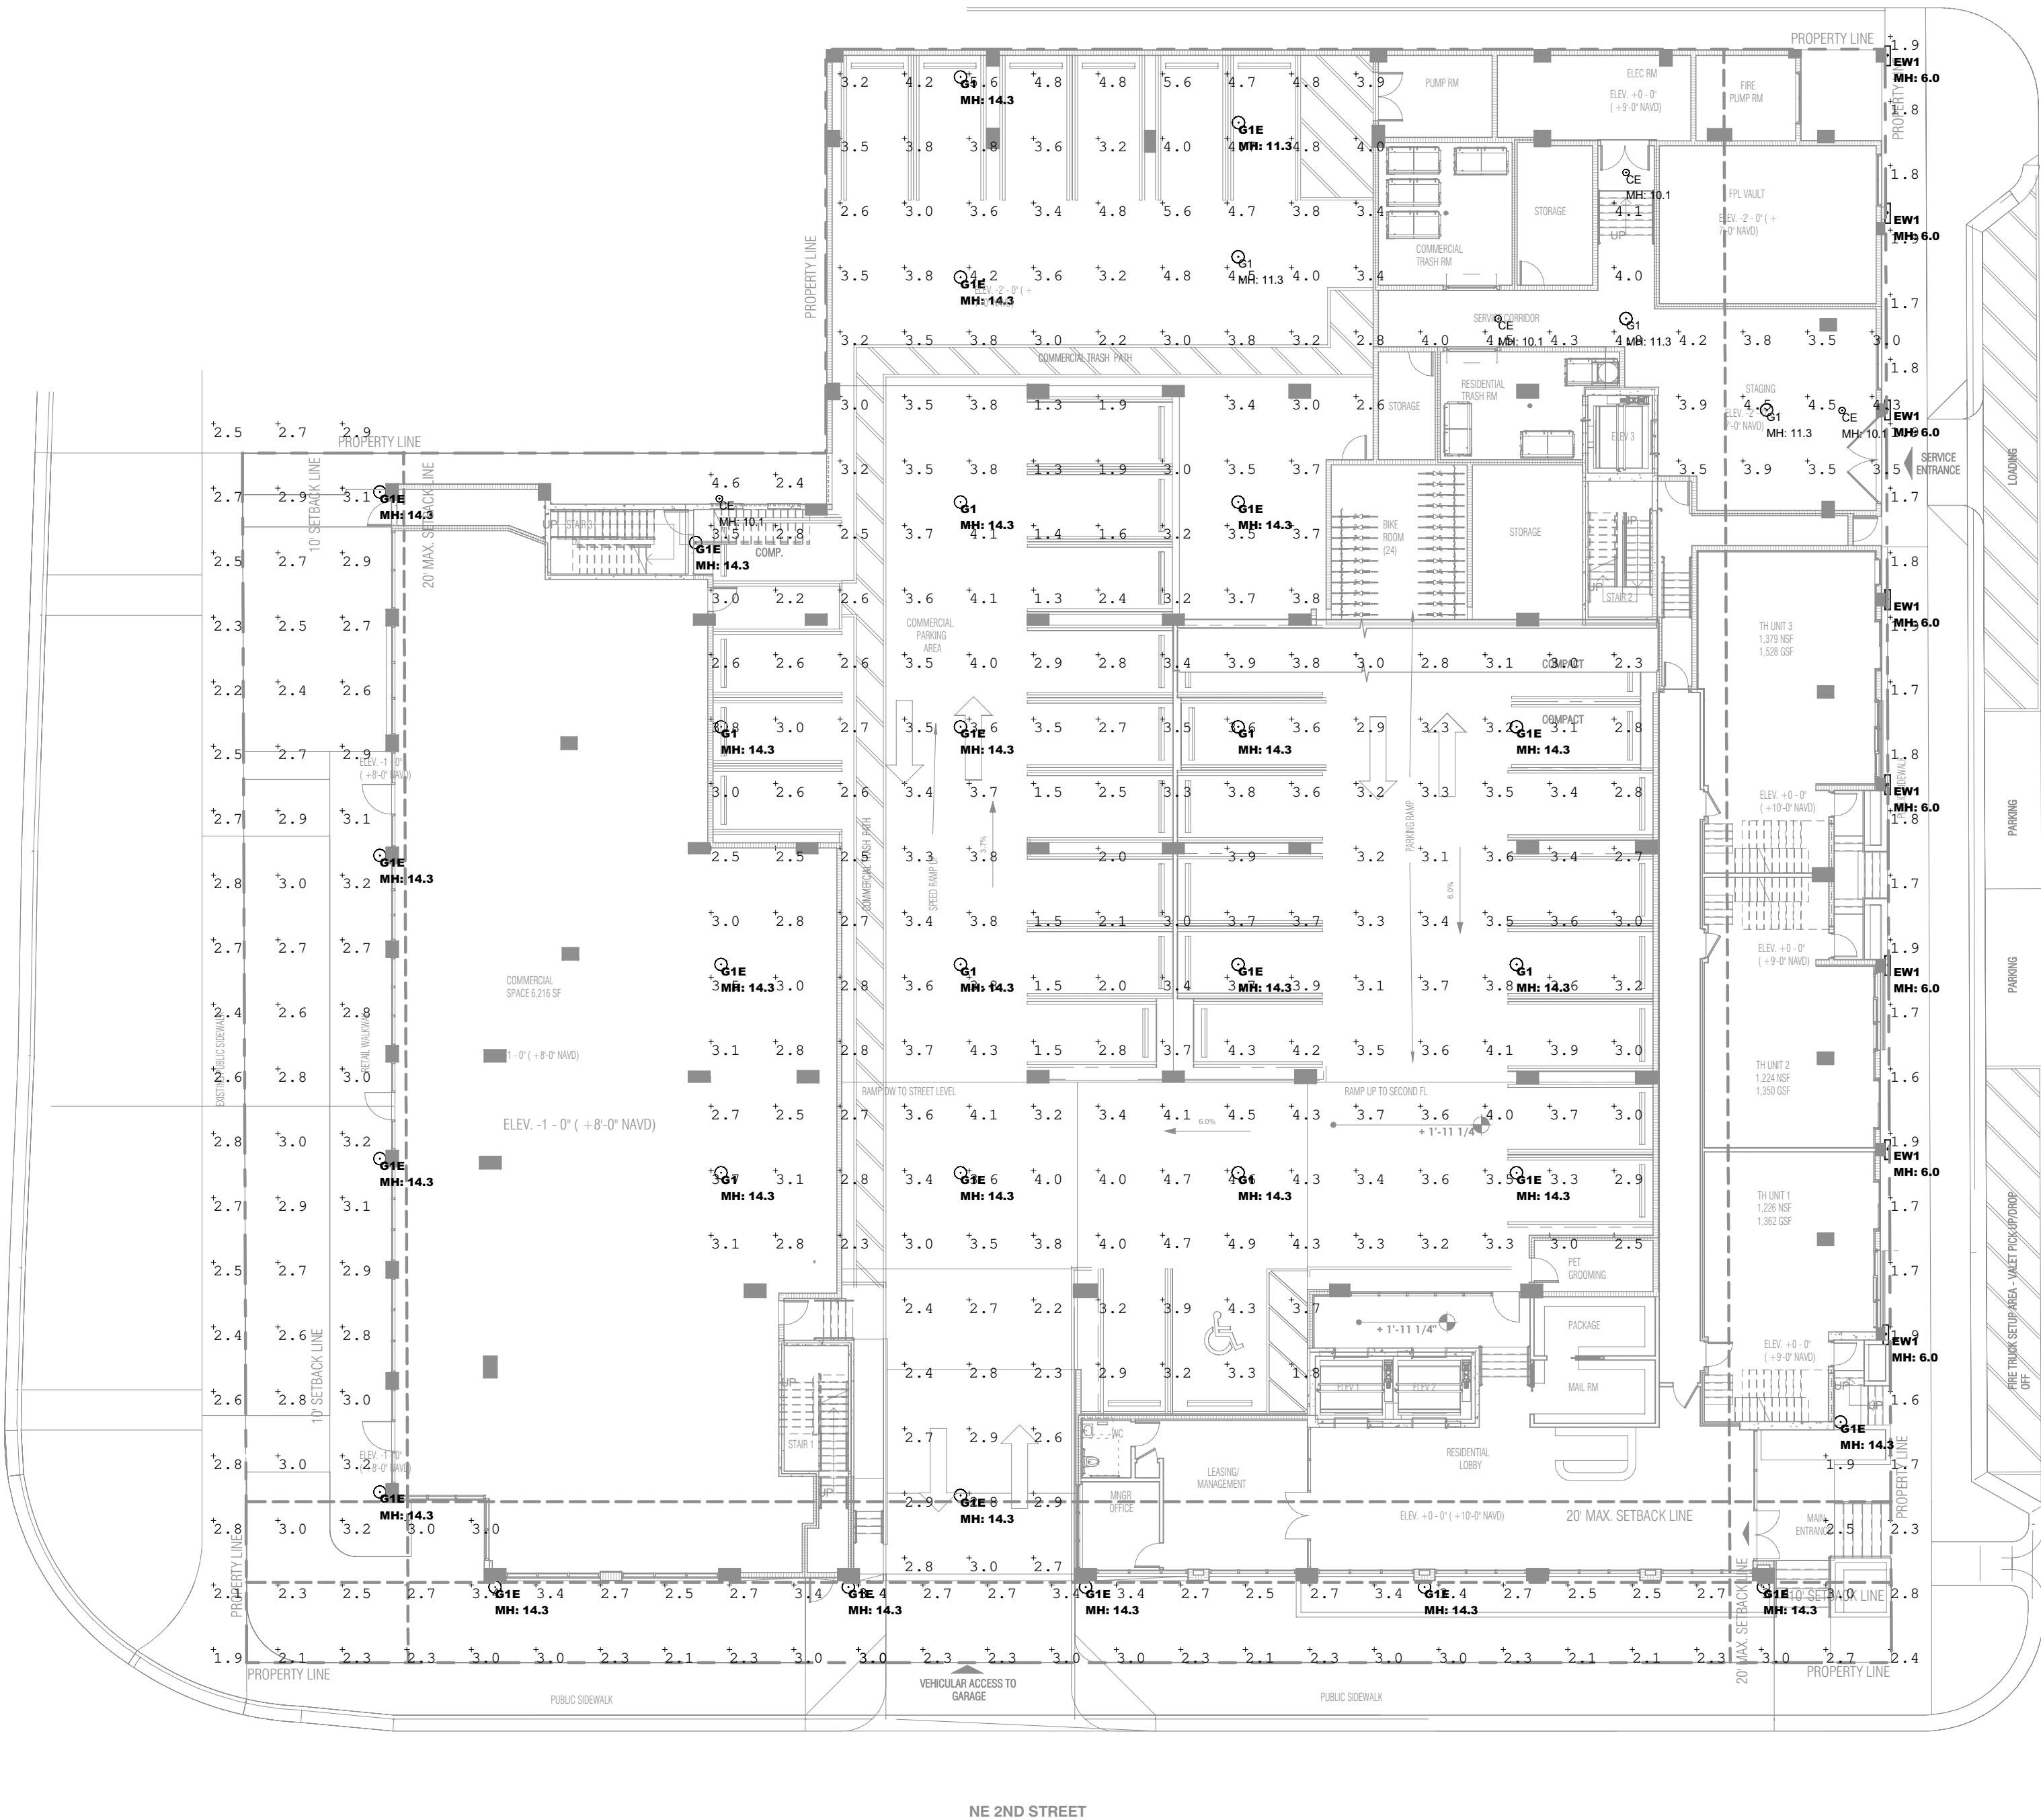

LUMINAIRE SCHEDULE									
SYMBOL	QTY	LABEL	MANUFACTURER	MANUFACTURE	DETAILS NUMBER	QUANTITY	REMARKS	SLP	LUMINAIRE LUMENS
1	1	Shop	Shop	Shop	100' 100' 100' 100' 100' 100' 100' 100' 100' 100'	100	100	100	100
2	1	Shop	Shop	Shop	100' 100' 100' 100' 100' 100' 100' 100' 100' 100'	100	100	100	100
3	1	Shop	Shop	Shop	100' 100' 100' 100' 100' 100' 100' 100' 100' 100'	100	100	100	100
4	1	Shop	Shop	Shop	100' 100' 100' 100' 100' 100' 100' 100' 100' 100'	100	100	100	100
5	1	Shop	Shop	Shop	100' 100' 100' 100' 100' 100' 100' 100' 100' 100'	100	100	100	100
6	1	Shop	Shop	Shop	100' 100' 100' 100' 100' 100' 100' 100' 100' 100'	100	100	100	100
7	1	Shop	Shop	Shop	100' 100' 100' 100' 100' 100' 100' 100' 100' 100'	100	100	100	100

CALCULATION SUMMARY									
LABEL	QTY	UNIT	SPACING (FT)	SPACING (FT)	HEIGHT (FT)	AREA	MAX	MIN	AVERAGE
RECEIVER THRESHOLD	100	sq ft	10	10	10	1000	10.0	10.0	10.0
RECEIVER THRESHOLD	100	sq ft	10	10	10	1000	10.0	10.0	10.0

LUMINAIRE POWER SUMMARY			
LABEL	QTY	POWER (W)	POWER (W)
RECEIVER THRESHOLD	100	1000	1000
RECEIVER THRESHOLD	100	1000	1000

ARCHI-ONE

200 North Federal Hwy.
Pompano Beach FL



ARCHITECT:

DEFORMA STUDIO INC.
5555 BISCAYNE BLVD., SUITE 2 SW
MIAMI, FL 33137
T: 305.639.2053
E: INFO@DEFORMASTUDIO.COM
W: WWW.DEFORMASTUDIO.COM

STRUCTURAL ENGINEER:

BCC ENGINEERING

6401 SW 87TH AVENUE SUITE 200
MIAMI, FL 33173
305.670.2350

MEP ENGINEER:

RESTEKC

18191 NW 68TH AVENUE SUITE 228
MIAMI GARDENS, FL 33015
786.803.8689

CIVIL ENGINEER:

CMPLX

2140 S. DIXIE HIGHWAY, SUITE 308
MIAMI, FL 33133
PHONE: 305.297.2602

 
LANDSCAPE ARCHITECT:

GSIA DESIGN, INC.

17070 NW 70TH AVE. SUITE 214
MIAMI, FL 33015
PHONE: 305.392.1016

INTERIOR DESIGNER:

KEY PLAN



OWNER / DEVELOPER:

ARCHI

8005 LEMON SERPENTINE LANE
DELRAY BEACH, FL 33446-2247
(561) 351-0208
WWW.ARCHI.GE



Office Registration #AA28002593


Drawn by: Author
Approved by: Approver

DESCRIPTION

DATE

Seal

PROFESSIONAL OF
RECORD STAMP

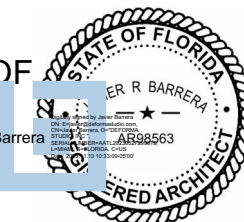

JAVIER R. BARRERA
FLORIDA REGISTERED ARCHITECT
AR No. AR58563

DESIGN
DEVELOPMENT

PHOTOMETRIC
PLAN GARAGE

P&Z
A - 17
SCALE 1/16" = 1'-0"

THE DESIGNS INDICATED IN THESE DRAWINGS ARE THE PROPERTY OF DEFORMA STUDIO. ALL COPYRIGHTS RESERVED.

P223-12000052
04/24/2024