

DESIGNED	DRAWN	CHECKED
NH	NH	JY

R E V I S I O N S

DATE:	COMM:
02.28.2024	23008

POMPANO HOTEL


101 S. OCEAN BLVD
POMPANO BEACH, FL 33062

Digitally signed
by Jiro Yates
Date:
2024.02.28
10:47:01-05'00'

PHOTOMETRIC THIRD FLOOR PLAN

DRC SET

AR-503

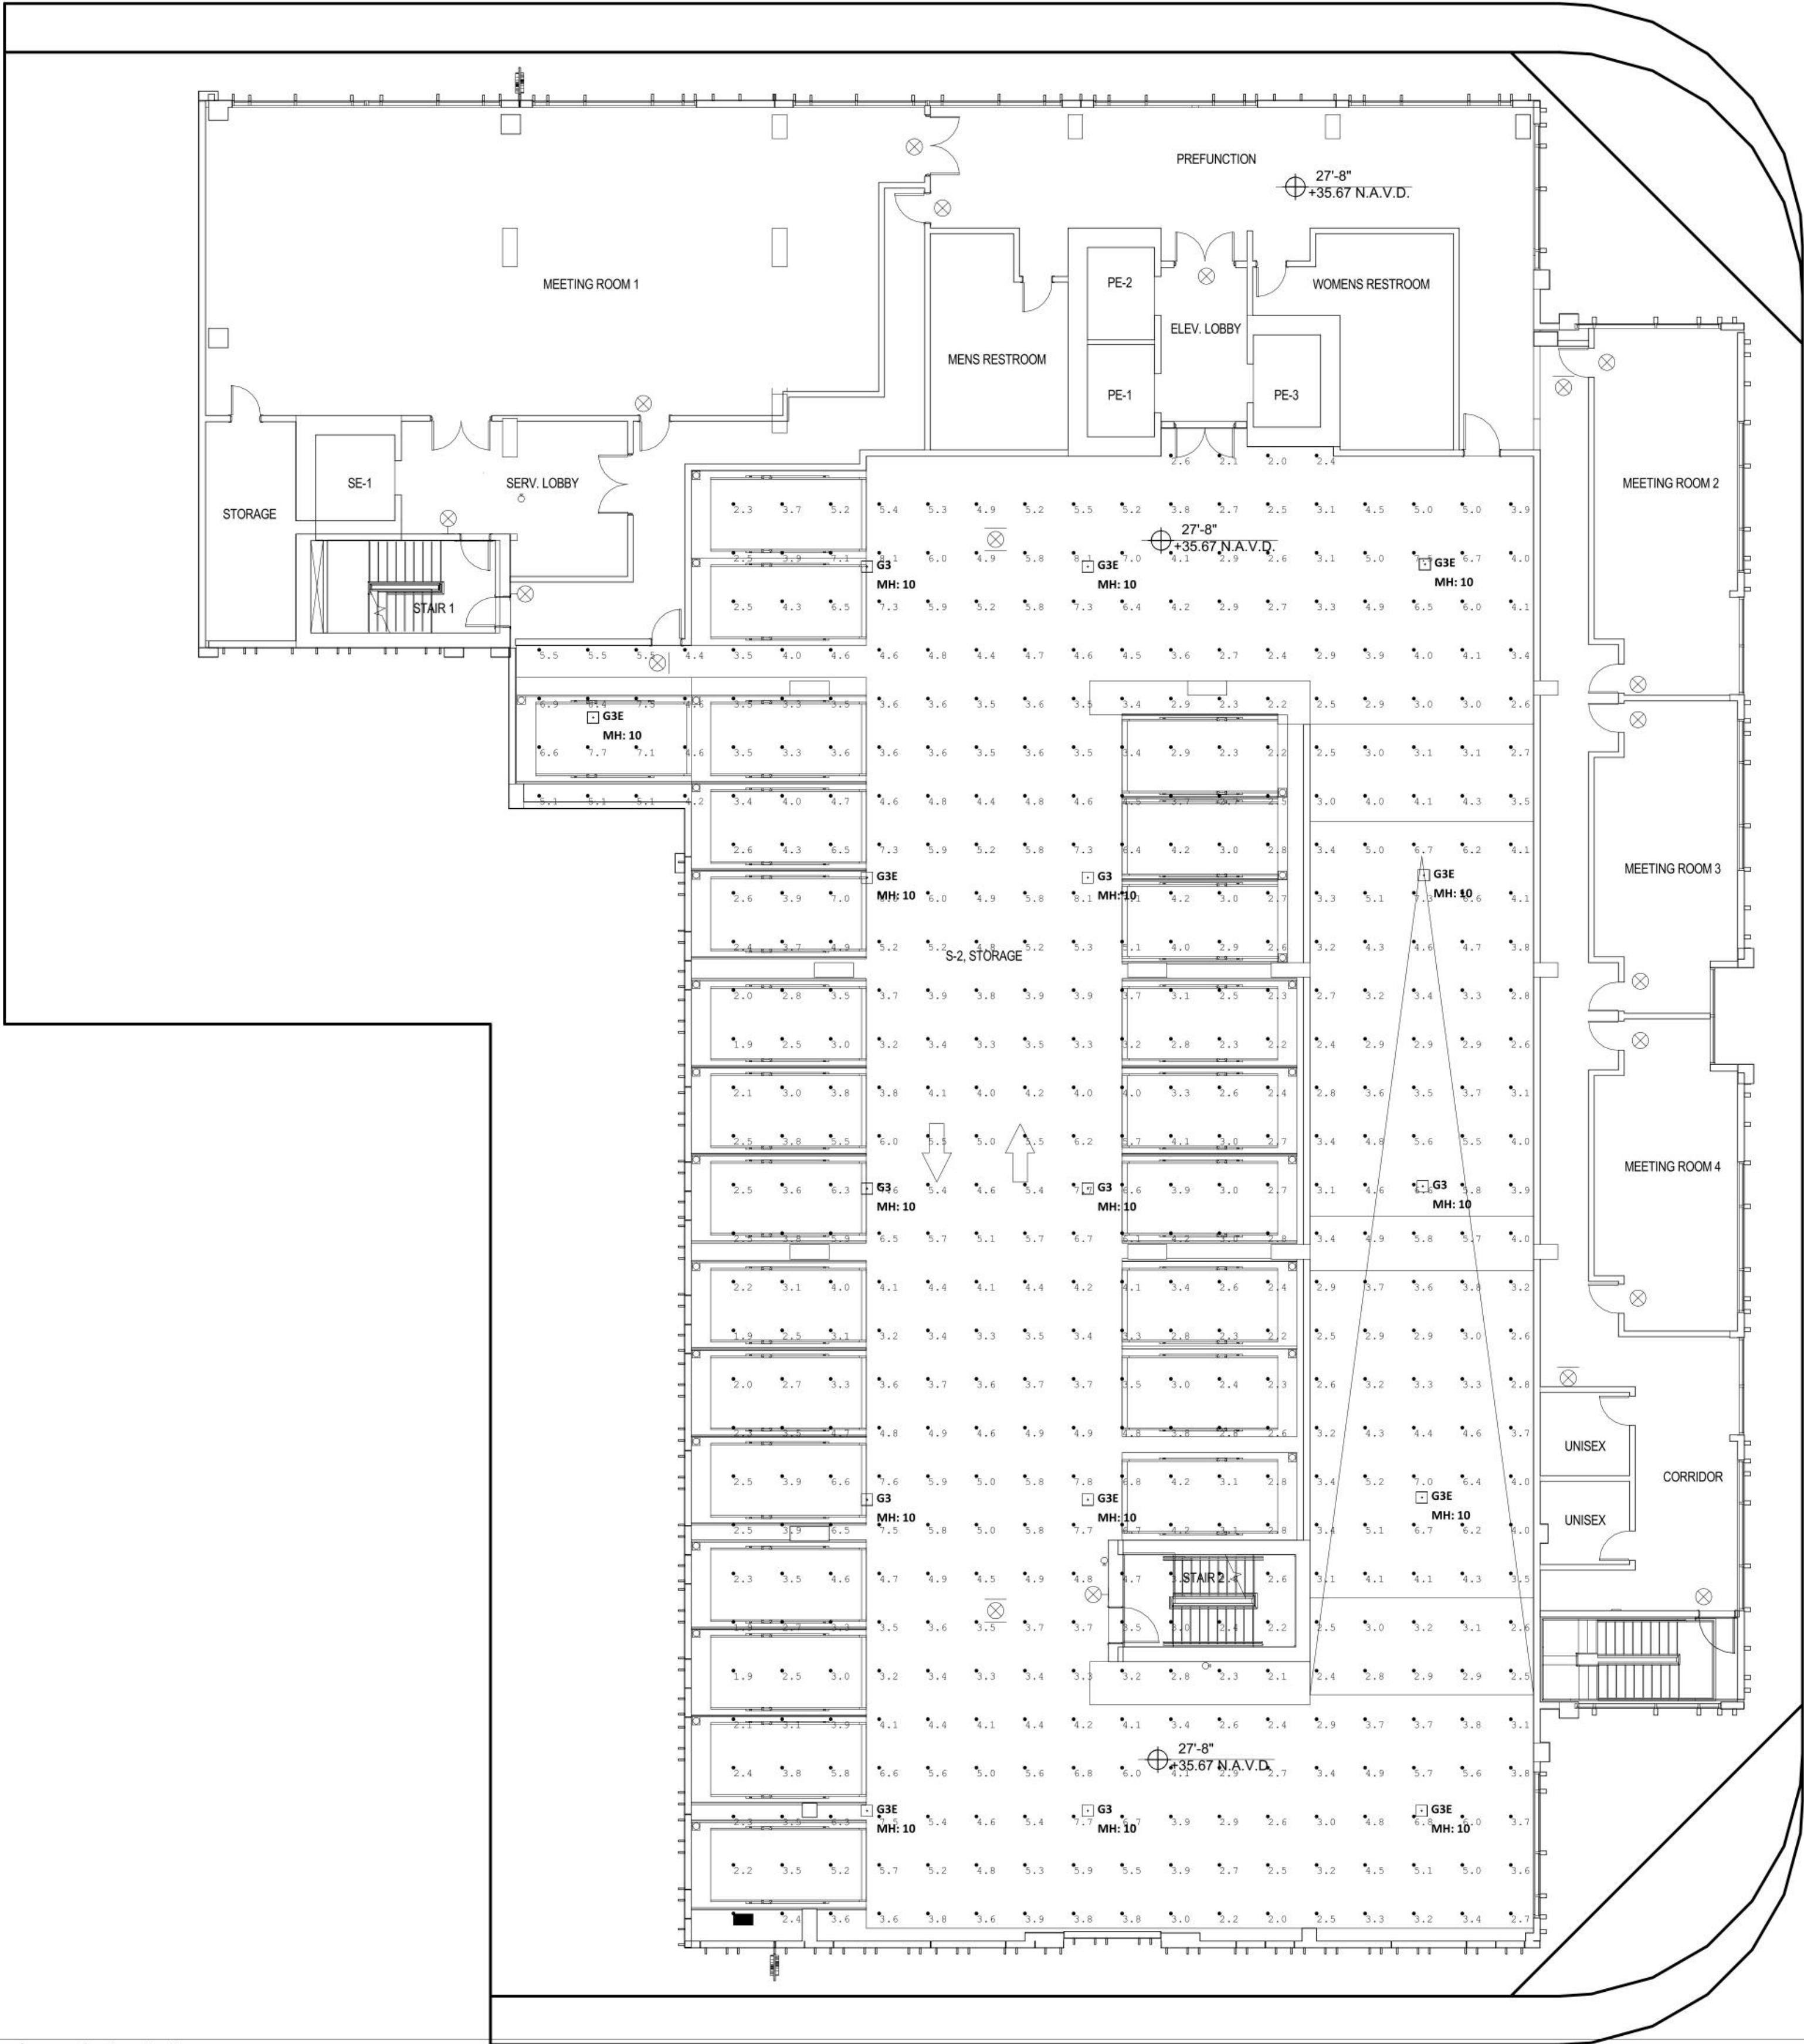

Luminaire Schedule								
Symbol	Qty	Label	Arrangement	Description	LLF	Luminaire Lumens	Luminaire Watts	Total Watts
•	7	G3	Single	Cree Lighting IG-B-NM-5S-4L-40K8-XX-WH	0.900	3860	33	231
•	9	G3E	Single	Cree Lighting IG-B-NM-5S-4L-40K8-XX-WH (Connected to Generator)	0.900	3860	35	297

Calculation Summary								
Label	CalcType	Units	Avg	Max	Min	Avg/Min	Max/Min	
Parking Garage_Floor	Illuminance	Fc	4.09	8.4	1.7	2.41	4.94	

AAC
PZ23-12000042
05/07/2024