


RENTAL APARTMENTS
FOR KAVAC MULTIFAMILY LLC
820 NW 9th AVENUE
POMPANO BEACH , FLORIDA

MARK	DATE	DESCRIPTION
------	------	-------------

PROJECT No. LB830	DATE: 5-30-19
DRAWN BY: RM	CHECKED BY: LB
LEOPOLDO BELLÓN, AIA (A6-0737)	

LEOPOLDO BELLÓN
Digitally signed by
LEOPOLDO BELLÓN
Date: 2021.05.25
11:27:24 -0400

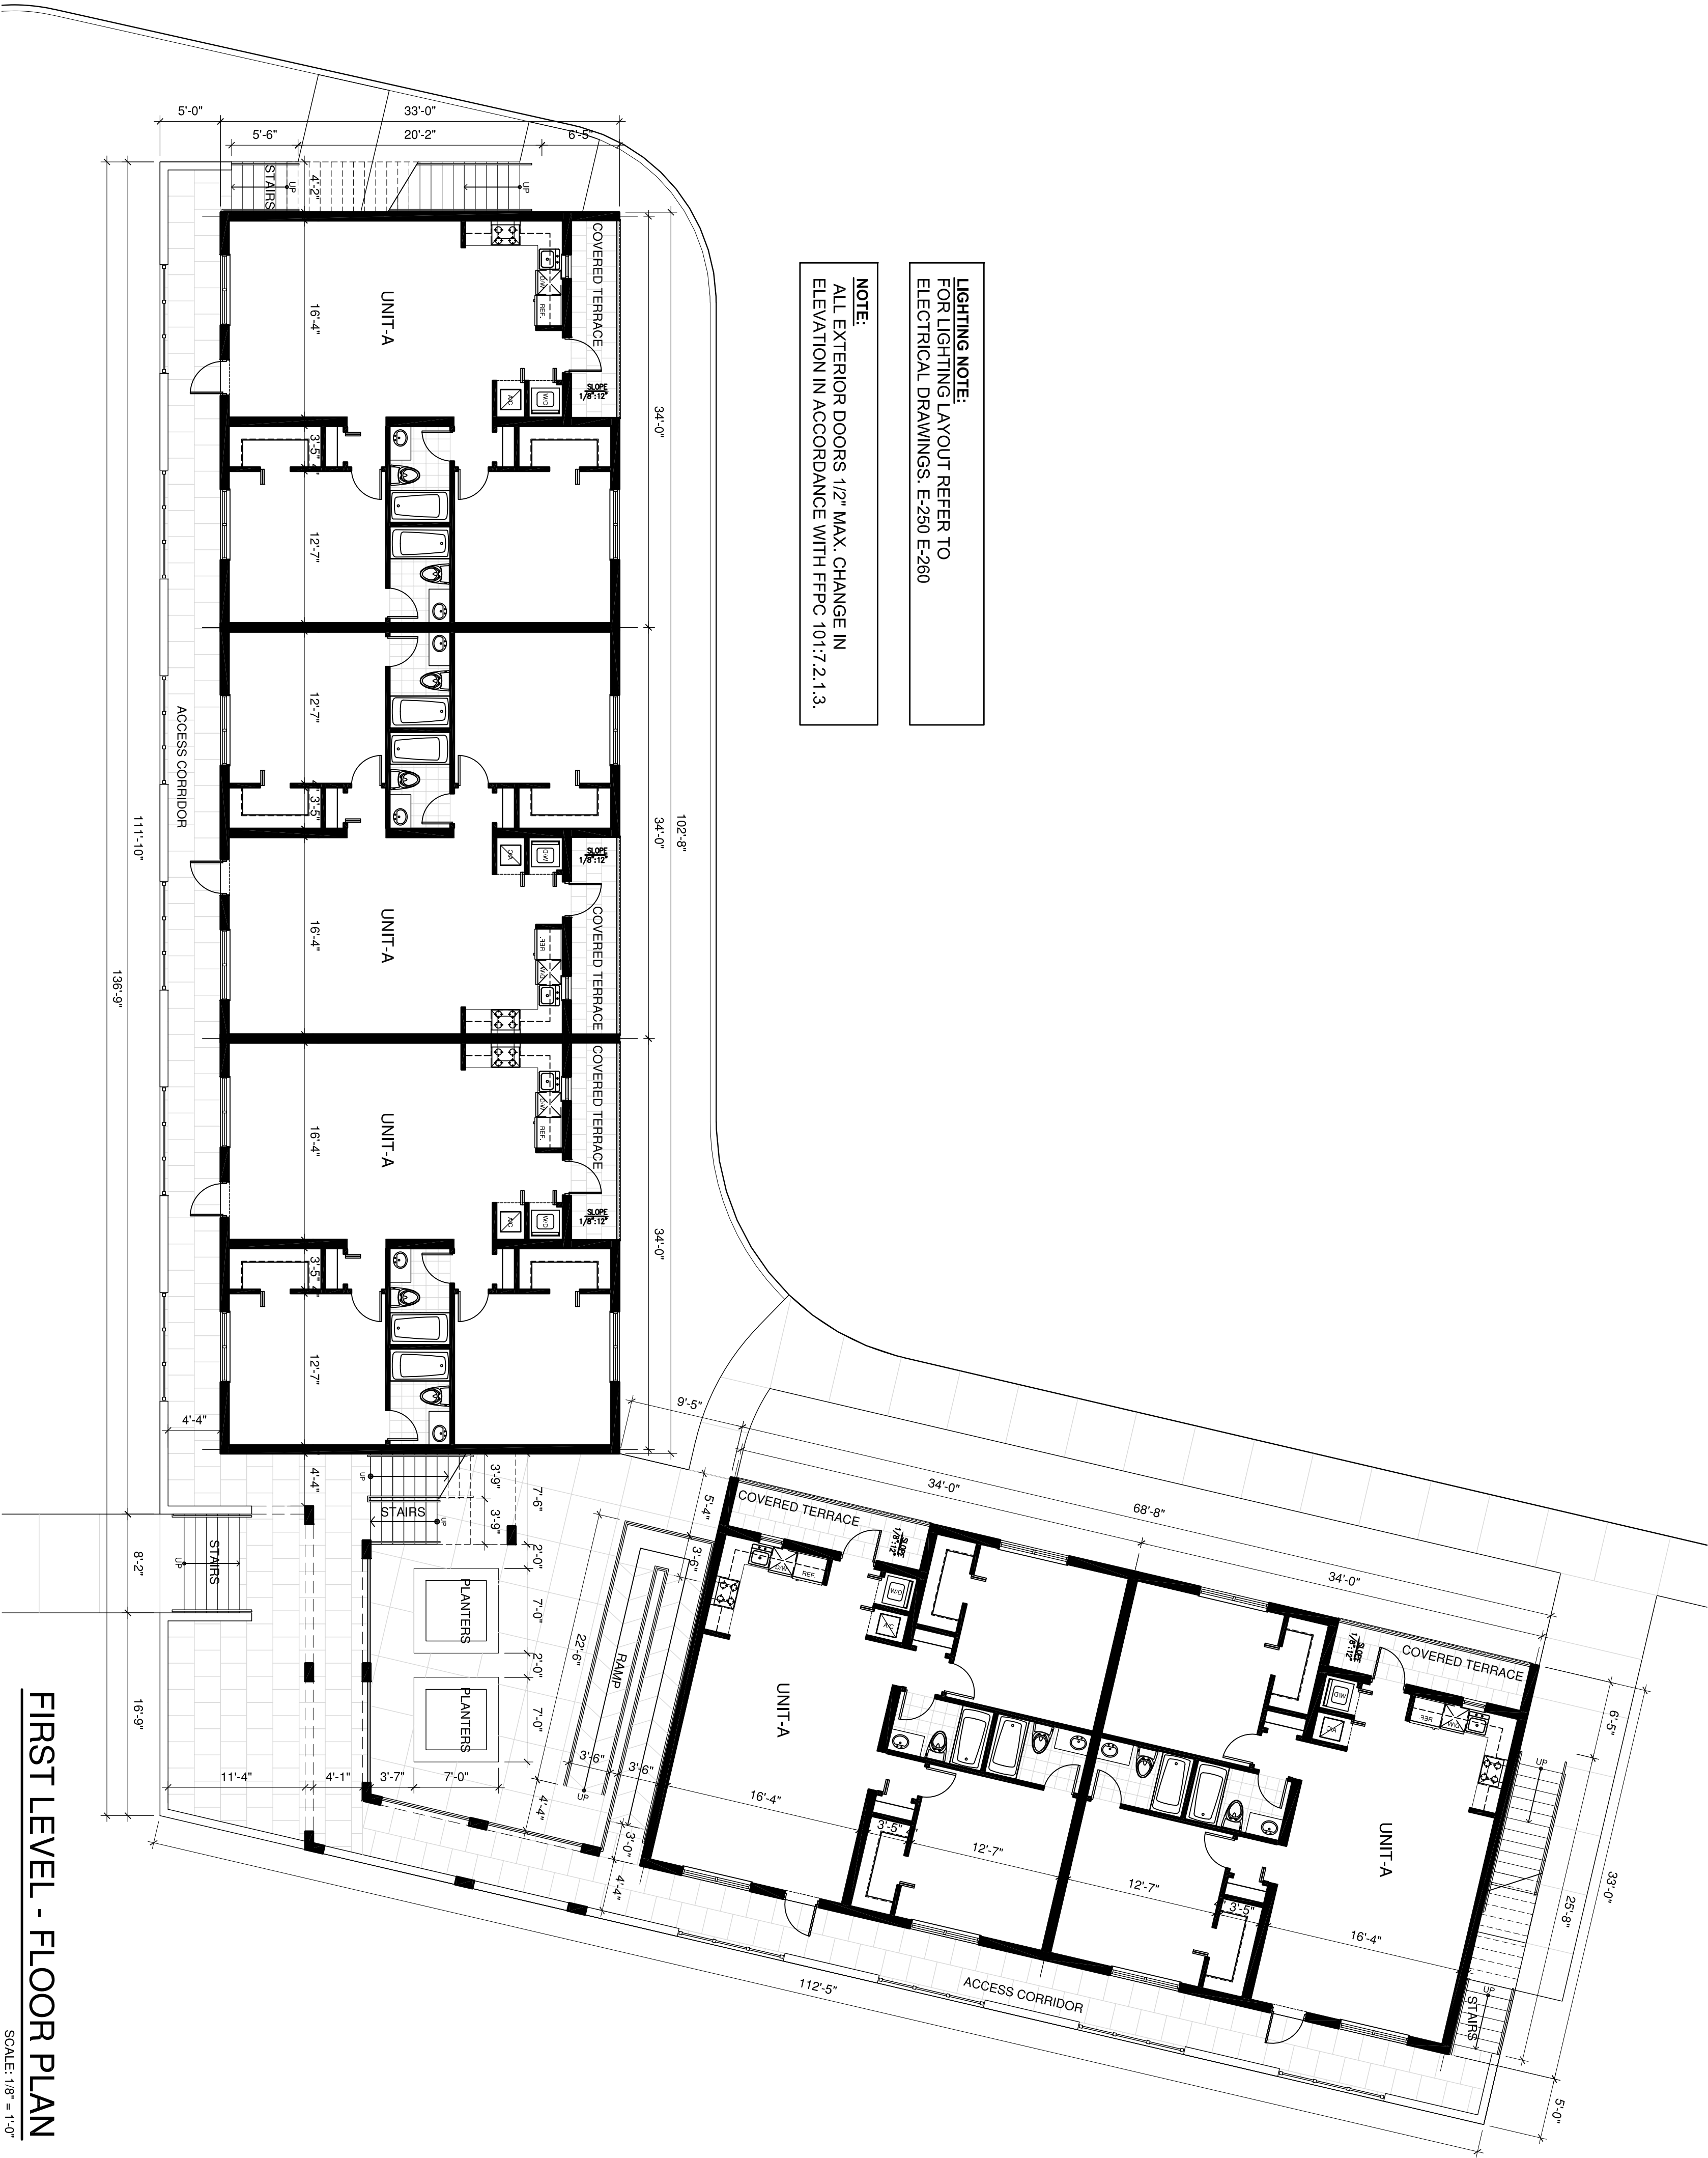

LIGHTING NOTE:
FOR LIGHTING LAYOUT REFER TO
ELECTRICAL DRAWINGS, E-250 E-260

NOTE:
ALL EXTERIOR DOORS 1/2" MAX. CHANGE IN
ELEVATION IN ACCORDANCE WITH FPPC 101.7.2.1.3.