
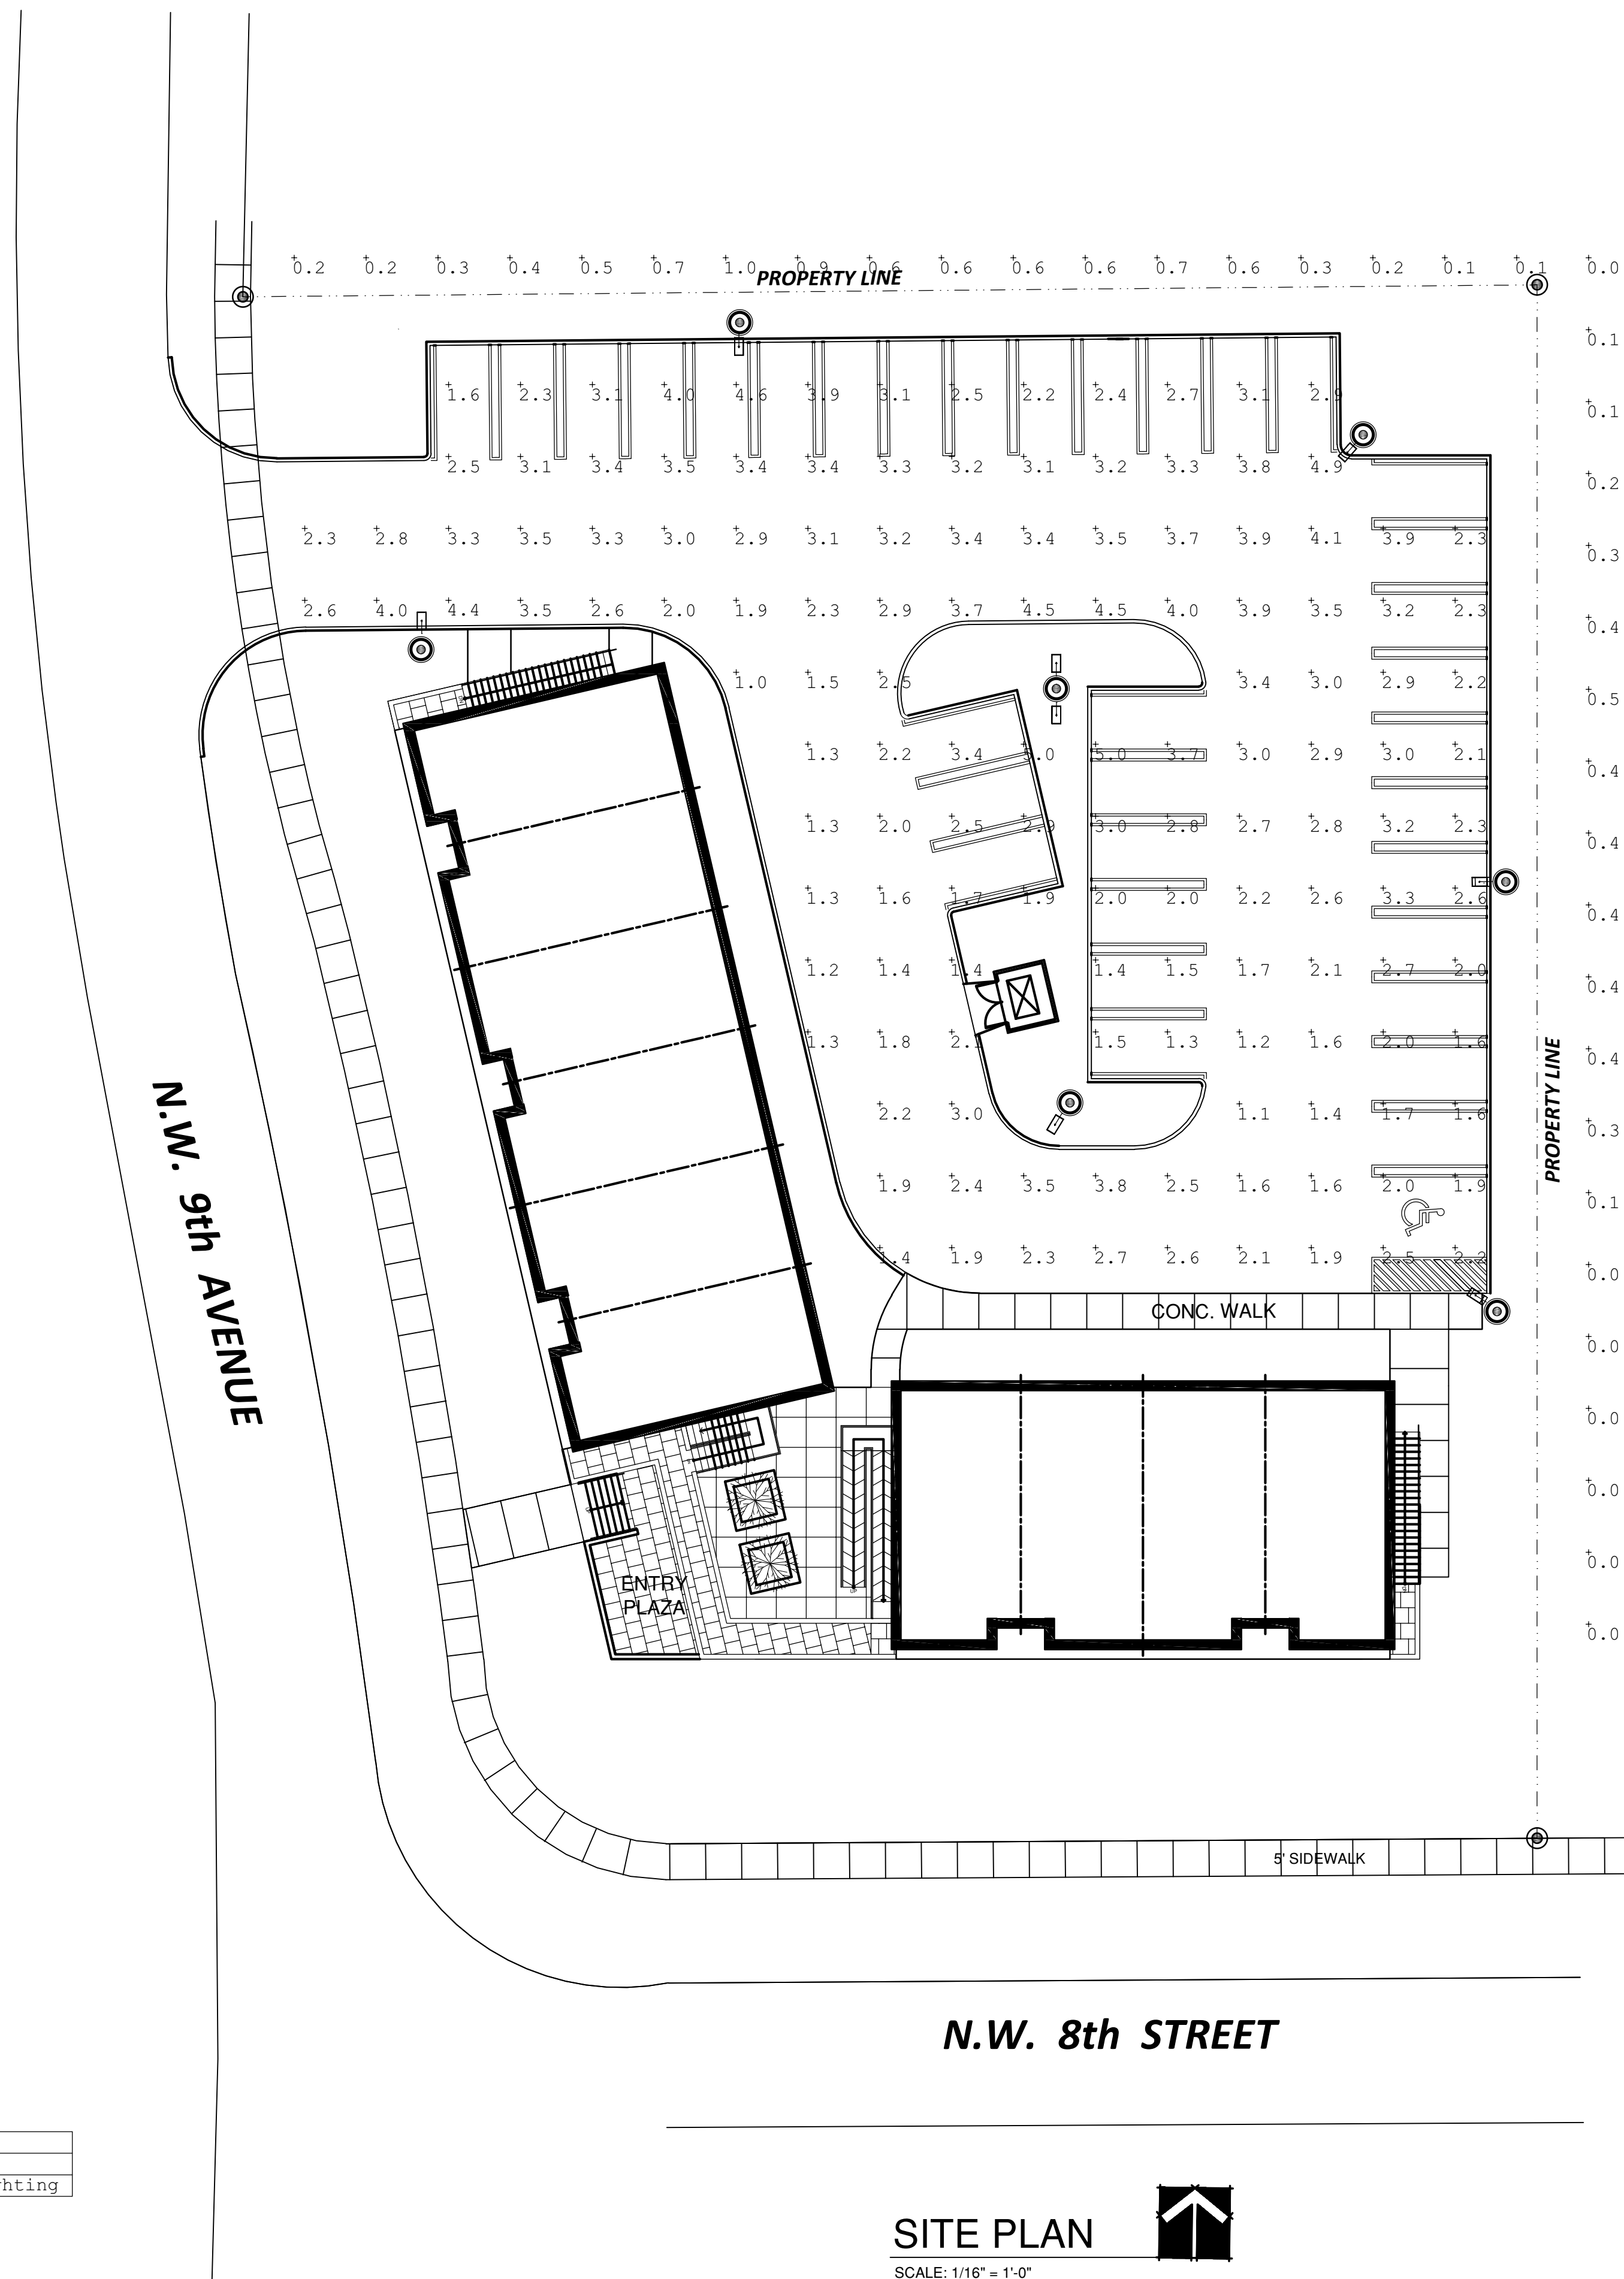


Calculation Summary									
Label	CalcType	Units	Avg	Max	Min	Avg/Min	Max/Min	Max/Avg	# Pts
PARKING LOT	Illuminance	Fc	2.66	5.0	1.0	2.66	5.00	1.88	139
Property Line Perimeter	Illuminance	Fc	0.33	1.0	0.0	N.A.	N.A.	3.03	38

Luminaire Location Summary							
LumNo	Label	X	Y	Z	Orient	Tilt	
8	RSX1 LED P2 40K R3 EGS	7780.535	-413.279	20	270	0	
9	RSX1 LED P2 40K R3 EGS	7736.411	-454.397	20	90	0	
10	RSX1 LED P2 40K R3 EGS	7824.667	-461.309	20	90	0	
11	RSX1 LED P2 40K R3 EGS	7867.257	-428.002	20	228.634	0	
15	RSX1 LED P2 40K R3 EGS	7824.691	-464.986	20	269.689	0	
19	RSX1 LED P2 40K R3 EGS	7884.113	-489.618	20	180.854	30	
20	RSX1 LED P2 40K R3 EGS	7883.311	-547.224	20	147.38	30	
21	RSX1 LED P2 40K R3 EGS	7825.901	-521.074	20	238.95	0	

Luminaire Schedule								
Symbol	Qty	Label	Arrangement	LLF	Lum. Watts	Total Watts	Lum. Lumens	[MANUFAC]
	8	RSX1 LED P2 40K R3 EGS	SINGLE	0.900	72.9467	583.5736	8430	Lithonia Lighting



## SITE PLAN

SCALE: 1/16" = 1'-0"


**BELLÓN**  
architecture

**b&a**

2930 S.W. 128 STREET  
SUITE 203  
MIAMI, FLORIDA 33186  
T. (305) 278-7776  
F. (305) 278-7473  
WWW.BELLONMILANES.COM  
AA-26002616

ARCHITECTURE  
LAND PLANNING  
INTERIORS  
CONSTRUCTION MANAGEMENT

CONSULTANTS

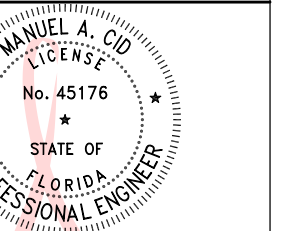


Digitally signed by  
Manuel A Cid  
Date: 2021.05.12  
6:02:20 -04'00'

FOR KAVAC MULTIFAMILY LLC  
820 NW 9th AVENUE  
POMPADRO BEACH, FLORIDA

[illegible]

PROJECT No. LB530
DRAWN BY: FM
CHECKED BY: LB
DATE: 5-30-19

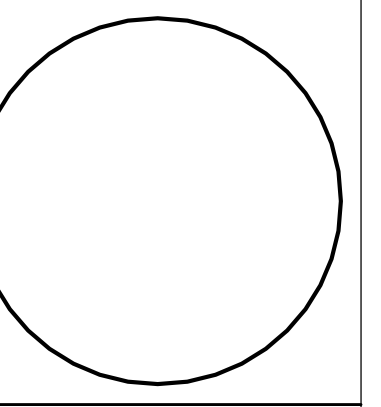

PHOTOMETRIC PLAN

PHOTOMETRIC PLAN

10

**PH**

0005

0005 OF

\_\_\_\_\_

**DRC**

PZ21-12000005

7/7/2021

PROF. POLDO BELLINI (AR-8737)

SHEET TITLE

PHOTOMETRIC PLAN

PZ21

ARCHITECT

PZ21-12000005