

K:\2025\270-279\25-274 - Costco - Pompano Beach - FL - DD Package\DD Package\274ES-1.dwg, 10/29/2025 10:35:50 AM, Tlitch

DRC

PZ25-12000023
12/03/2025


TYPICAL WALL MOUNTED LIGHT DETAIL
SCALE: NTS

FUEL FACILITY -
LED (GA)
NO SCALE

FIXTURE DESCRIPTION	
(P)	COOPER GALN-SA68-740-U-5WQ-BZ, 243W TYPE 5 DISTRIBUTION, FIBERGLASS POLE 30'-0" ABOVE GRADE, 4000K COLOR TEMPERATURE
(P1)	COOPER GALN-SA48-740-U-SL3-HSS-BZ, 243W TYPE 3 DISTRIBUTION, FIBERGLASS POLE 30'-0" ABOVE GRADE, 4000K COLOR TEMPERATURE
(P2)	COOPER GALN-SA68-740-U-T4W-BZ, 243W TYPE 4 FIBERGLASS POLE 30'-0" ABOVE GRADE, 4000K COLOR TEMPERATURE
(W)	LITHONIA DSXW2 P5 40K T2M MVOLT, 57W LED, 18' MOUNTING HEIGHT, 4000K COLOR TEMPERATURE
(W1)	LITHONIA DSXW2 P5 40K T4M MVOLT, 57W LED, 18' MOUNTING HEIGHT, 4000K COLOR TEMPERATURE
(W2)	LITHONIA DSXW1 P3 40K T4M MVOLT, 21W LED, 15' MOUNTING HEIGHT, 4000K COLOR TEMPERATURE
(GA)	86W LED, SURFACE SYMETRIC DOWN LIGHT, 40K, FLAT LENS, 15' MOUNTING HEIGHT, 4000K COLOR TEMPERATURE

PLAN NOTES



- ① LIGHTS ON SEPARATE CIRCUIT AND CONTROL GROUP.

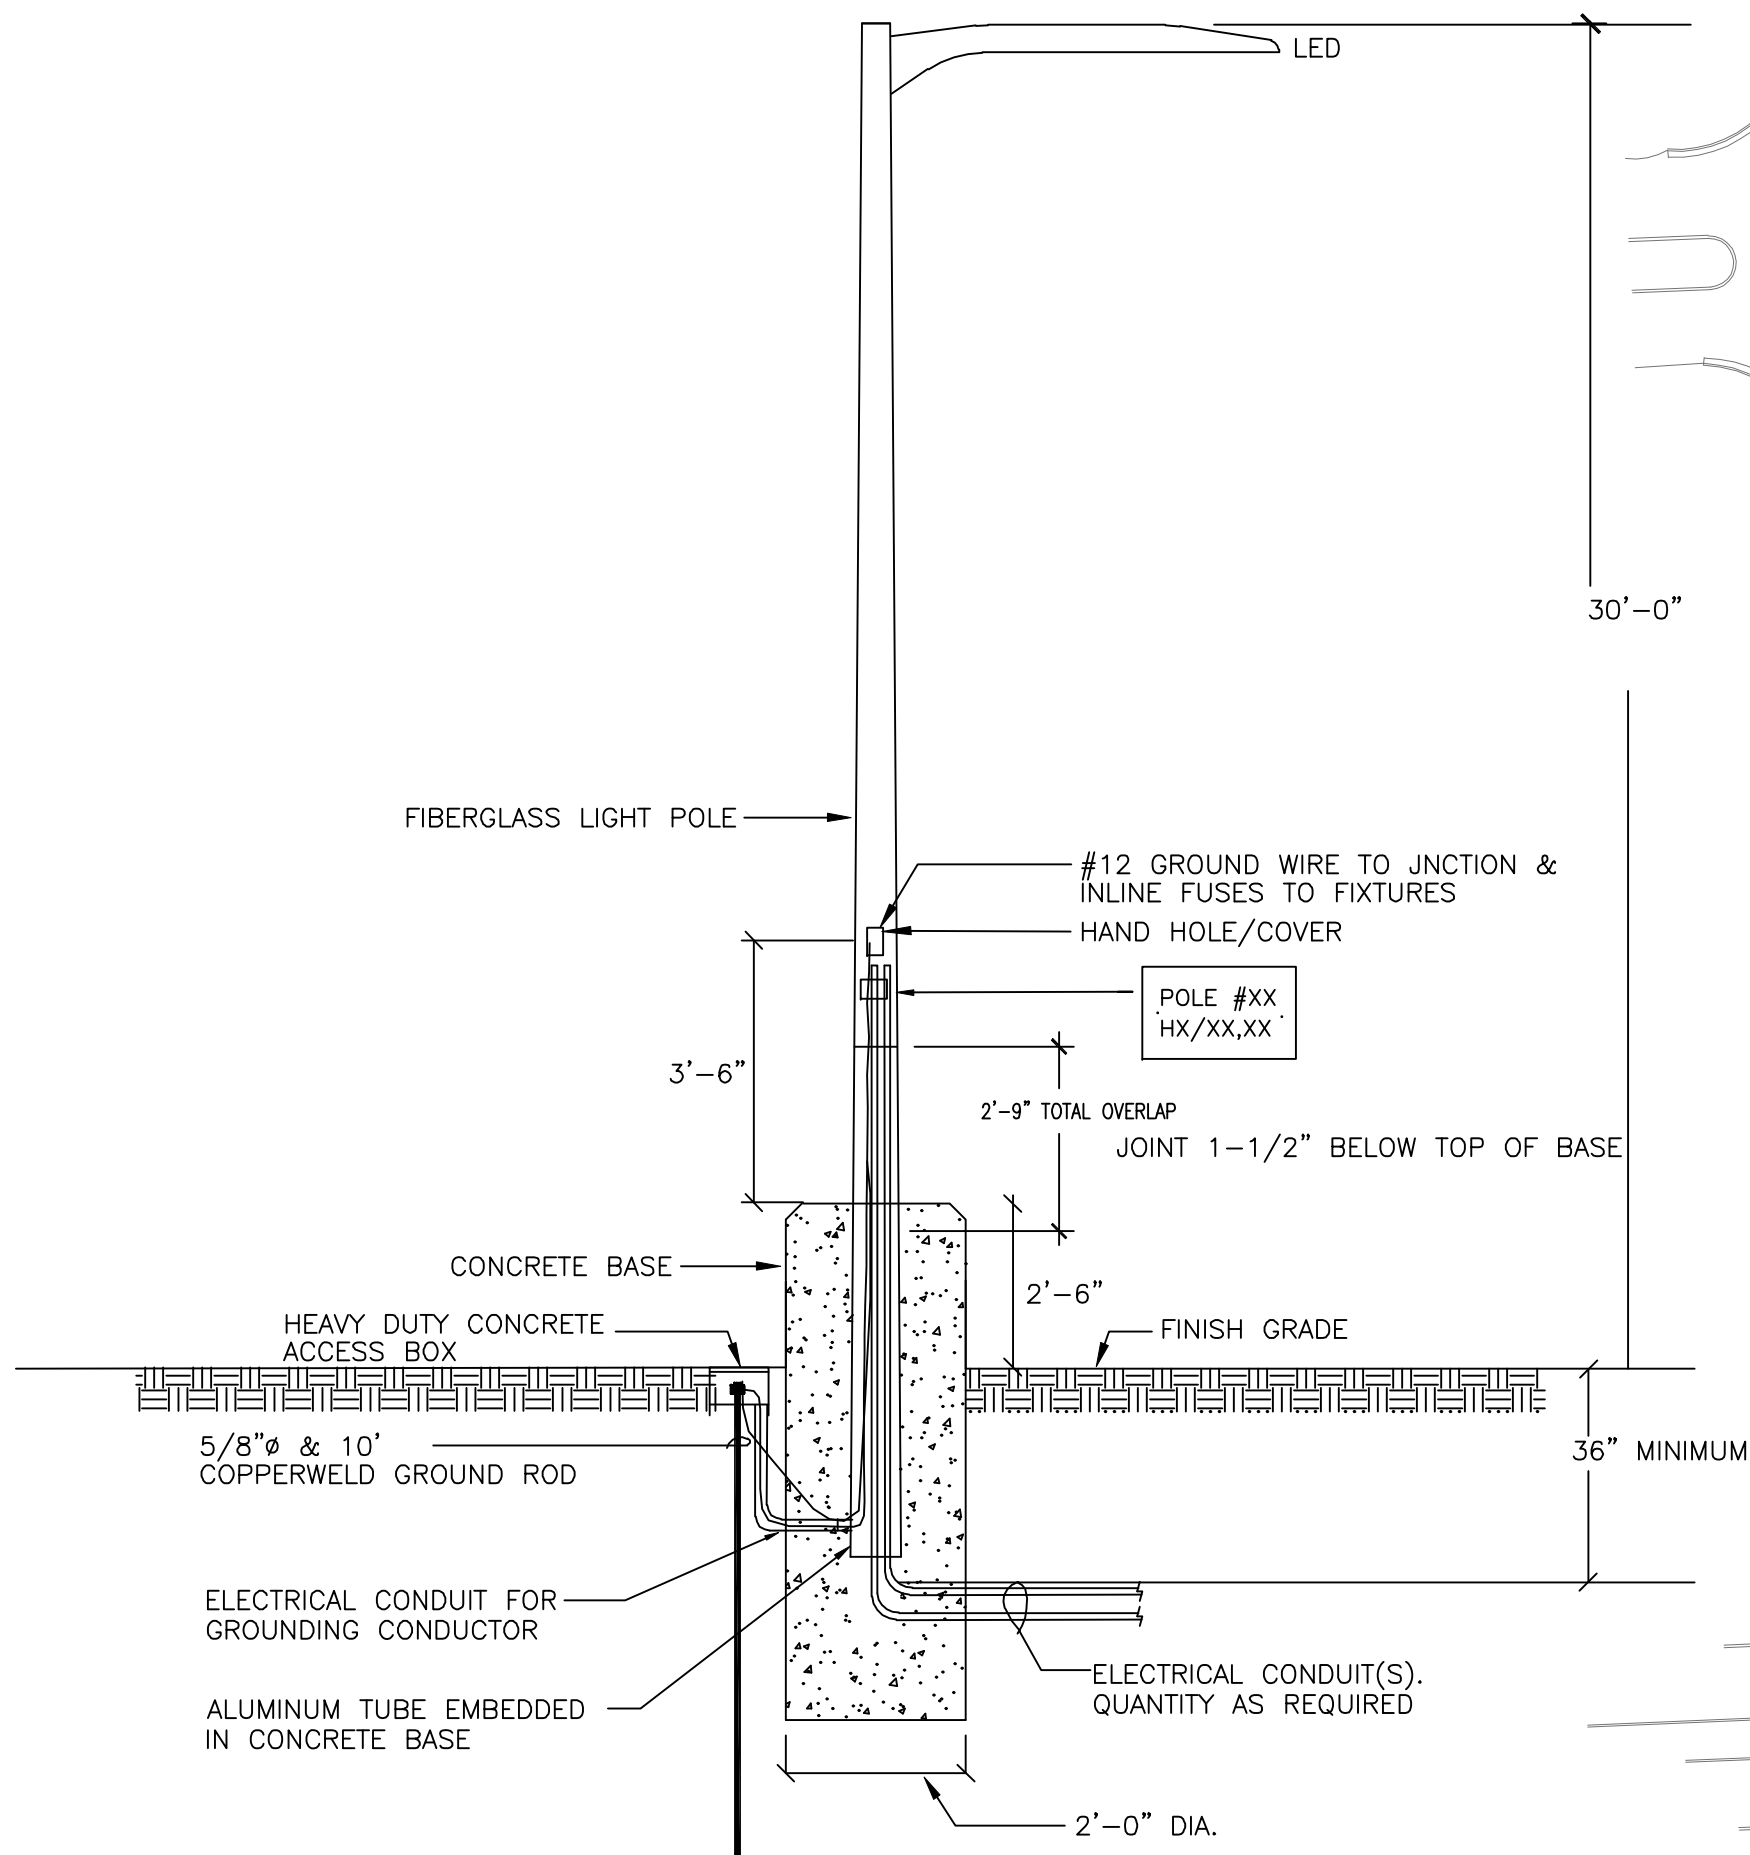

NOTE: PROVIDE CONCRETE J-BOX AS REQUIRED.
THIS DETAIL IS FOR ELECTRICAL CONDUITS ROUTING ONLY.
SEE STRUCTURAL DRAWINGS S0.2 FOR DETAILS.

POLE DETAIL

SCALE: NTS

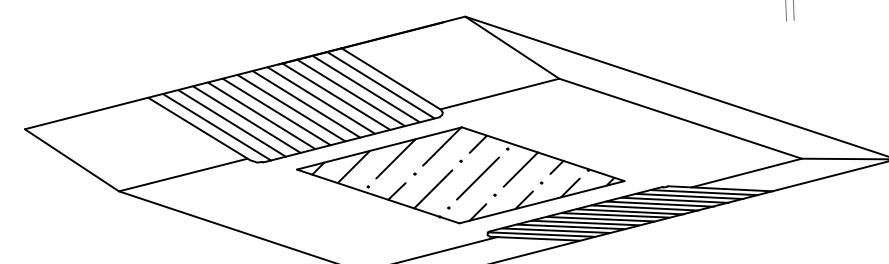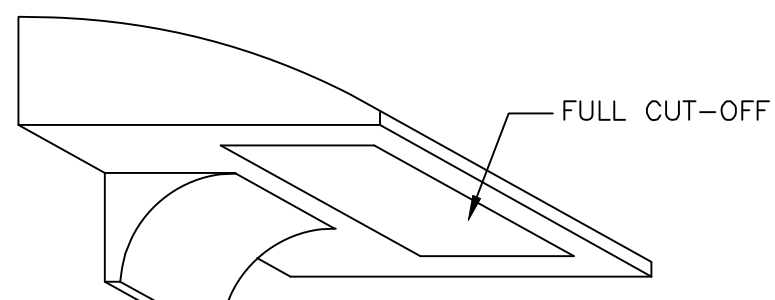

FUEL FACILITY -
LED (GA)
NO SCALE



SITE PHOTOMETRIC PLAN

SCALE: 1" = 50'-0"

SITE PLAN

NO PART OF THIS DOCUMENT MAY BE USED OR COPIED IN WHOLE
© OR IN PART WITHOUT THE PRIOR WRITTEN CONSENT OF T.E.I.NC.

ARCHITECT REFERENCE NO.24-0051

ISSUE DATE: JULY 30, 2025

REVISION DATE: OCTOBER 29, 2025


DRAWN: NW

CHECKED: HW/JGM

SE-1



DD PACKAGE
POMPAÑO BEACH, FL

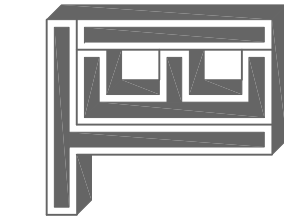

T.E. INC. of WA
830 N RIVERSIDE DRIVE
SUITE #200
RENTON, WA 98057
PHONE: 425-970-5763
FAX: 425-970-3766

PLANNING SUBMITTAL
10/01/25
PLANNING SUBMITTAL
10/29/25

PLANNING SUBMITTAL
10/01/25
PLANNING SUBMITTAL
10/29/25

THIS ITEM HAS
BEEN DIGITALLY
SIGNED AND SEALED
BY JOEL G.
MORTENSON, P.E.
ON
10/29/2025
PRINTED COPIES OF
THIS DOCUMENT
ARE NOT
CONSIDERED SIGNED
AND SEALED AND
THE SIGNATURE
MUST BE VERIFIED
ON ANY ELECTRONIC
COPIES.

