




PROPOSED AREA FOR ROOFTOP MECHANICAL UNITS
ROOFTOP MECHANICAL EQUIPMENT SCREEN: PROVIDE
ALUMINUM OR GALVANIZED STEEL LOUVERED SCREEN
SYSTEM, HURRICANE RATED PER FBC WIND LOAD
REQUIREMENTS. SCREEN HEIGHT TO FULLY CONCEAL ROOF
TOP EQUIPMENT (+/- 6'-6") FROM ALL PUBLIC VANTAGE
POINTS

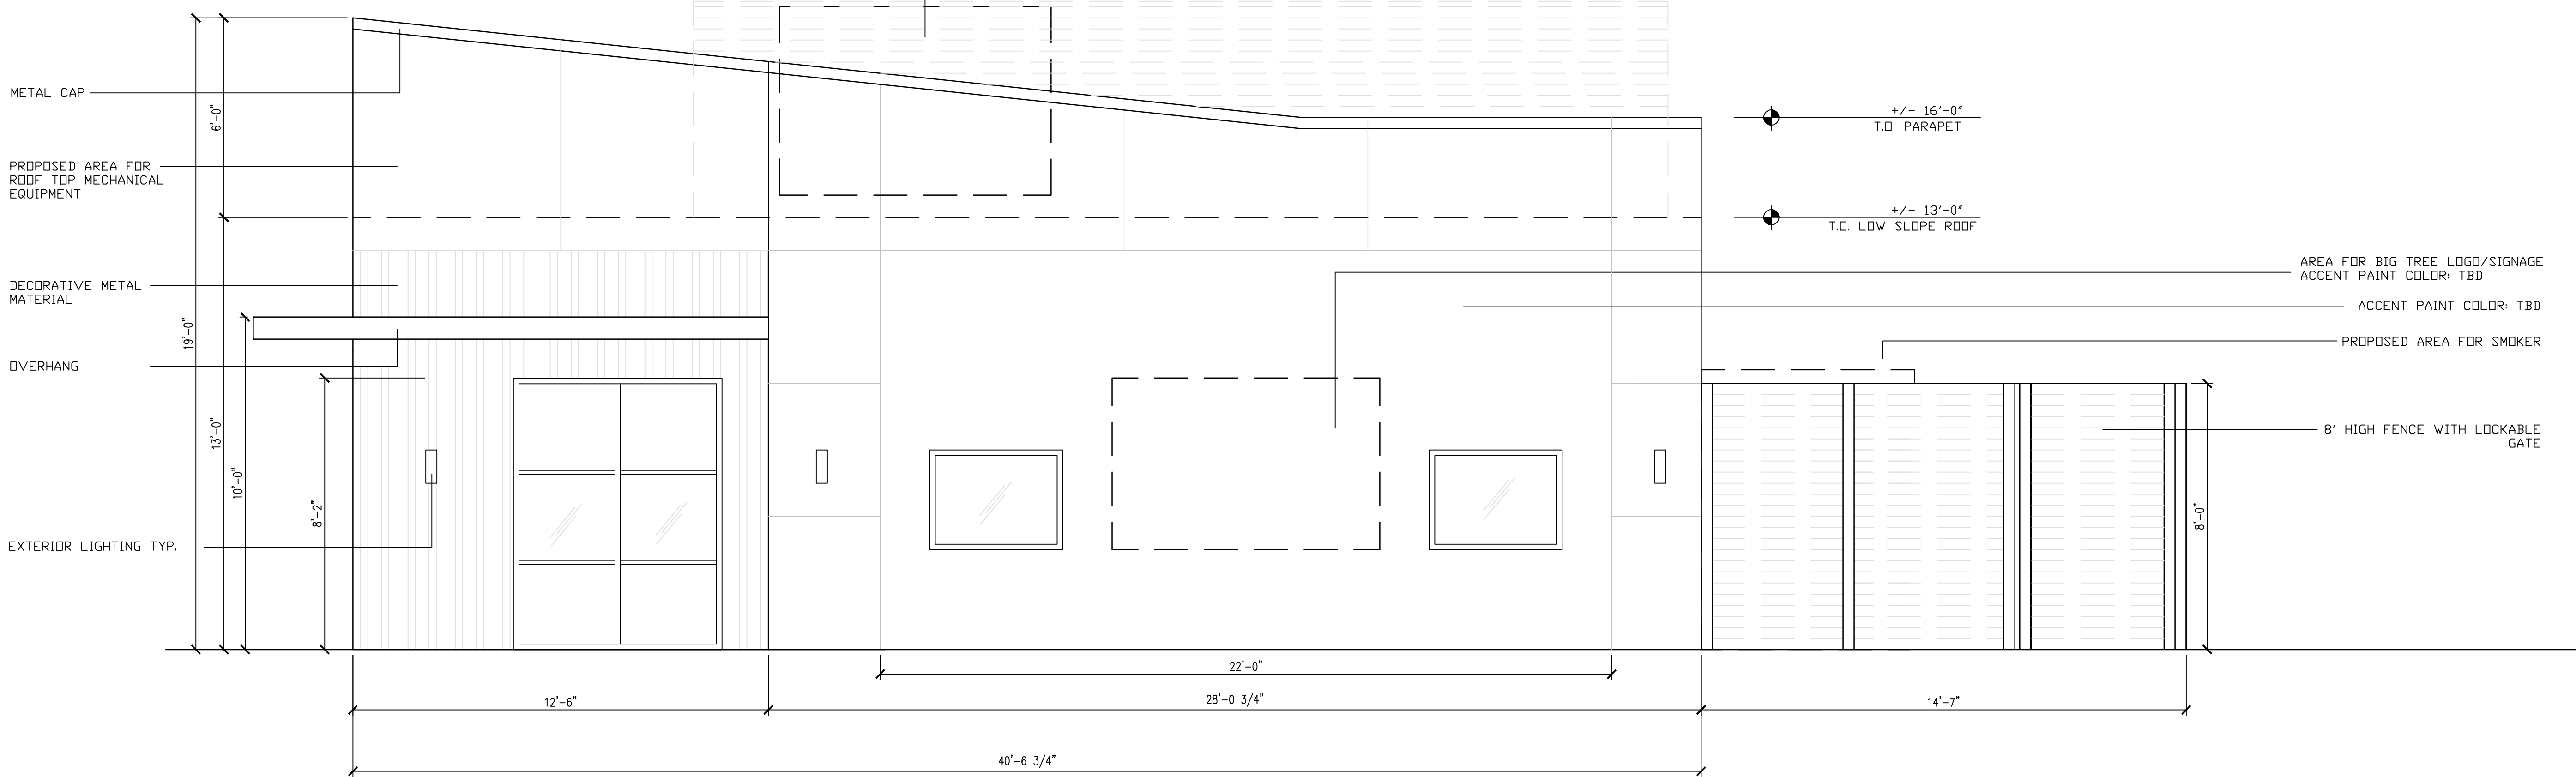


01

WEST EXTERIOR ELEVATION

1/2" = 1'-0"

PROPOSED AREA FOR ROOFTOP MECHANICAL UNITS
ROOFTOP MECHANICAL EQUIPMENT SCREEN:
PROVIDE ALUMINUM OR GALVANIZED STEEL
LOUVERED SCREEN SYSTEM, HURRICANE RATED
PER FBC WIND LOAD REQUIREMENTS. SCREEN
HEIGHT TO FULLY CONCEAL ROOF TOP
EQUIPMENT (+/- 6'-6") FROM ALL PUBLIC
VANTAGE POINTS

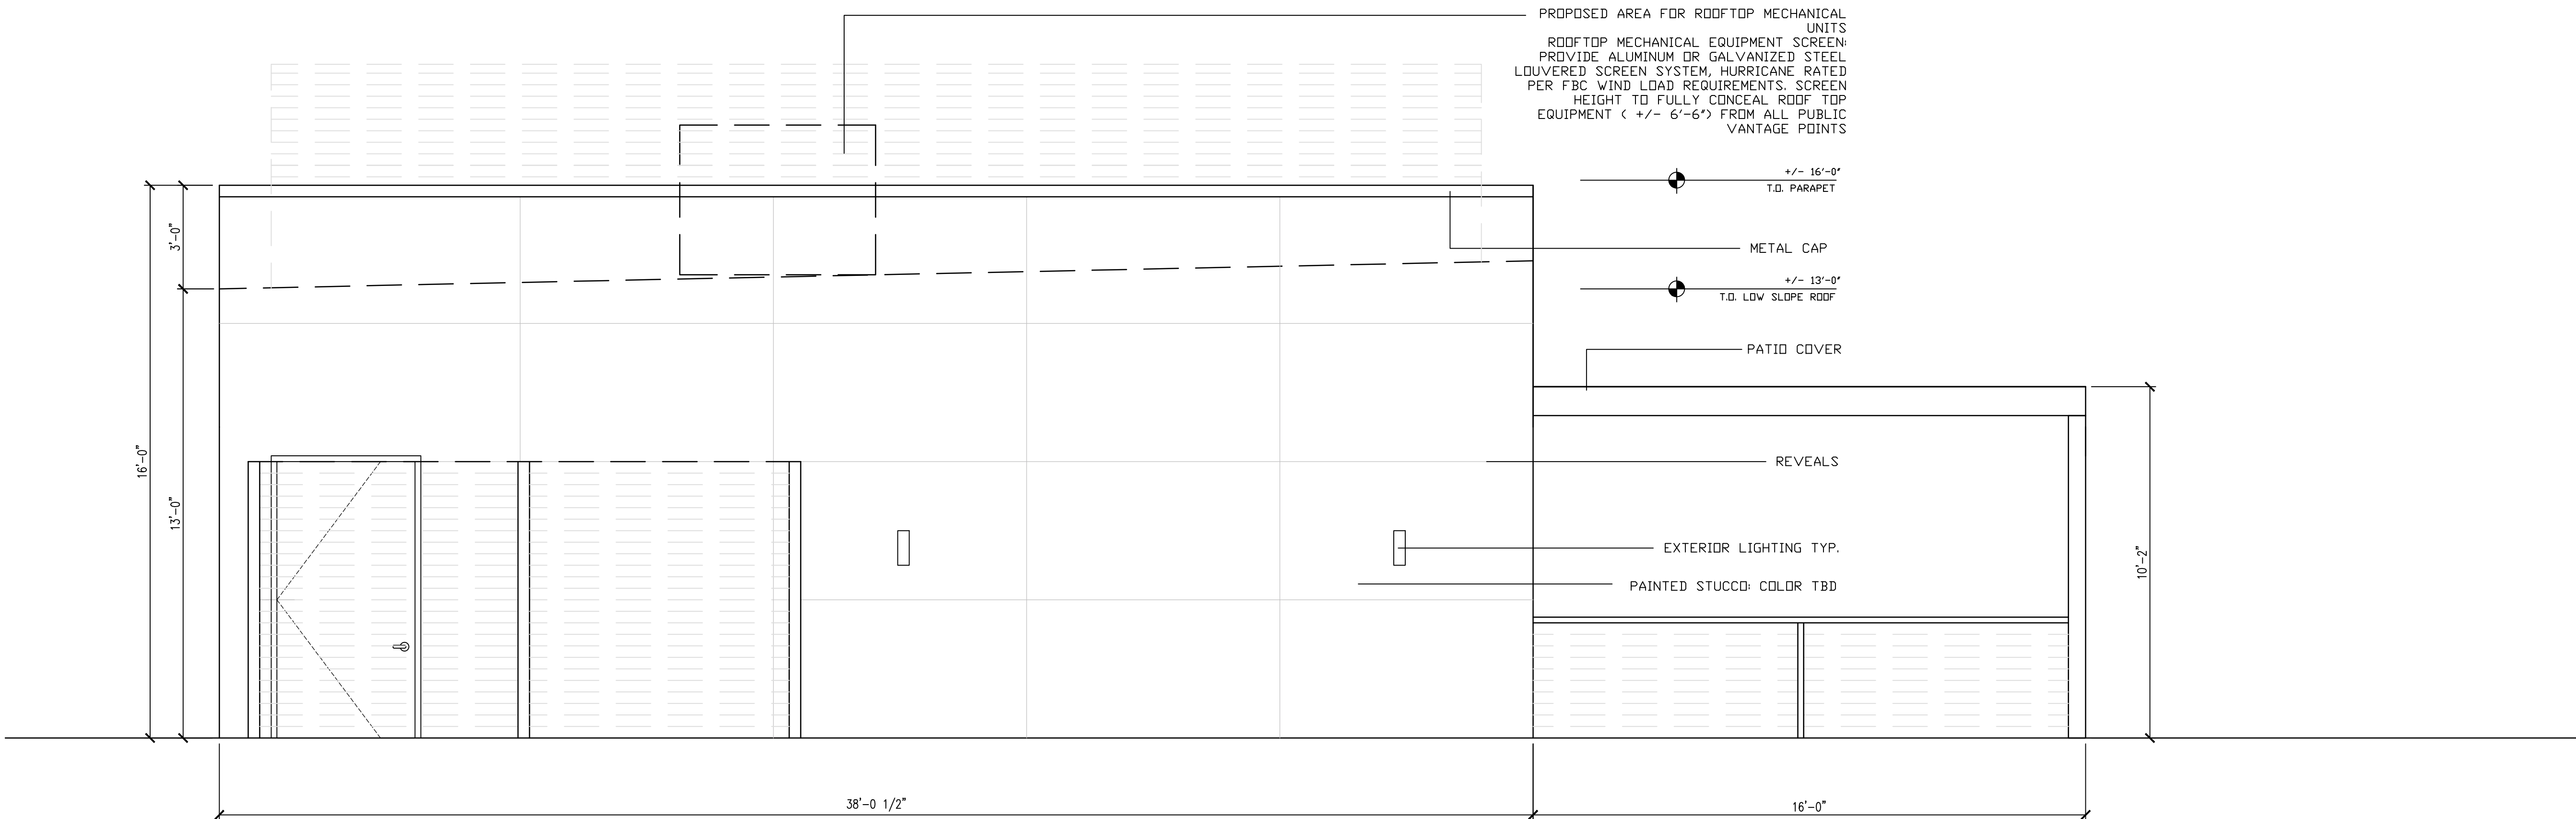

02

SOUTH EXTERIOR ELEVATION

1/2" = 1'-0"

STUDIO US
[DESIGN]

361 N UNIVERSITY DRIVE
PLANTATION, FLORIDA 33324

BIG TREE BBQ
NW 5TH STREET
POMPANO BEACH, FLORIDA 33069


REVISIONS

No.	DATE	DESCRIPTION

CONSTRUCTION DOCUMENTS

PROJECT NUMBER: 2023-16
ISSUE DATE:
DRAWN BY: SNB
CHECKED BY: SNB
FILENAME: 2023-16 BIG TREE BBQ

DRC
A-3.1

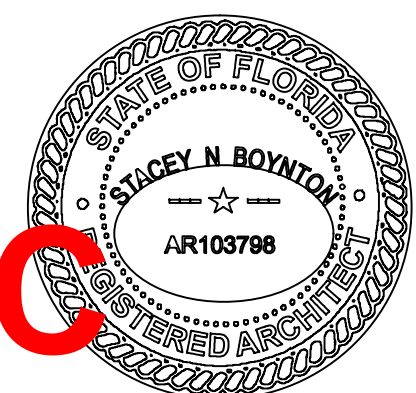

SHEET
PZ25-12000012

10.01.2025