

REV.	DATE	DESCRIPTION
01	05-13-2025	DRC SUBMITTAL

ALL MEASUREMENTS MUST BE VERIFIED BEFORE  
BEGINNING THE WORKS. NO MEASUREMENTS ARE TO  
BE SCALED DIRECTLY FROM THIS DRAWING.

Key section

Client  
**VERA FUND**  
NICK POLYUSHKIN  
& YURI KHARITONENKOV  
TEL: 305.833.3303



Project  
**1600 S FEDERAL HIGHWAY  
(MIXED-USE PROJECT)**  
1600 SOUTH FEDERAL HIGHWAY,  
POMPANO BEACH, FL 33062

Title  
**LEVEL 1.5  
PHOTOMETRICS**

Drawn	Field
J. WU	ARCHITECTURE
N. TREMBLAY	as shown
S. L'ECUYER	08-15-2025
J. WU	11/19/2025
24-838	P-002

Calculation Summary							
Label	CalcType	Units	Avg	Max	Min	Avg/Min	Max/Min
Parking Garage Floor	Illuminance	FC	12.24	81.1	1.2	6.8	103.5



Luminaire Schedule							
Symbol	Qty	Label	Arrangement	Description	LMF	Luminaire Lumens	Total Watts
○	18	01E	Single	Utopia Lighting LRC-36-SLEP-40K-180V-W8 (connected to	0.900	4810	83
○	18	01E	Single	Utopia Lighting LRC-36-SLEP-40K-180V-W8 (connected to	0.900	4810	83
○	11	01	Single	Utopia Lighting LRC-36-SLEP-40K-180V-W8	0.900	4810	83

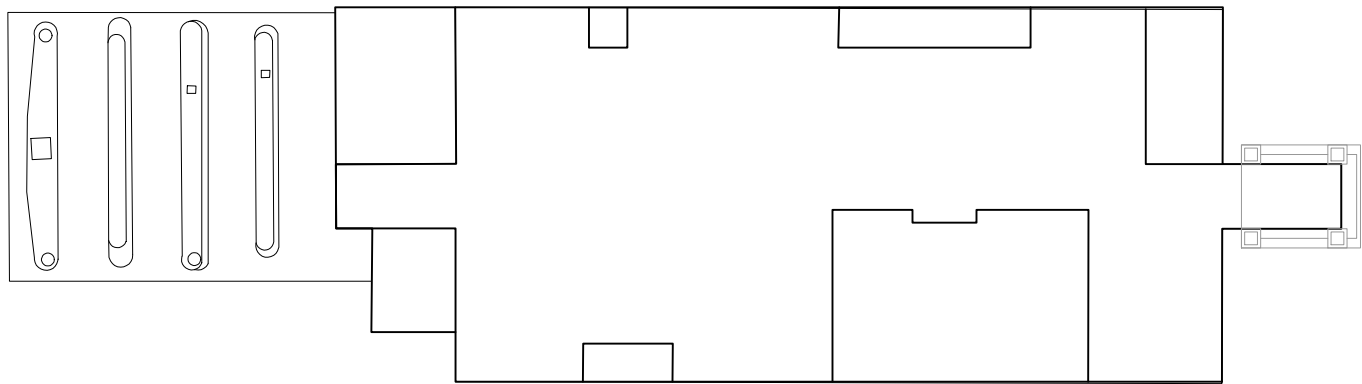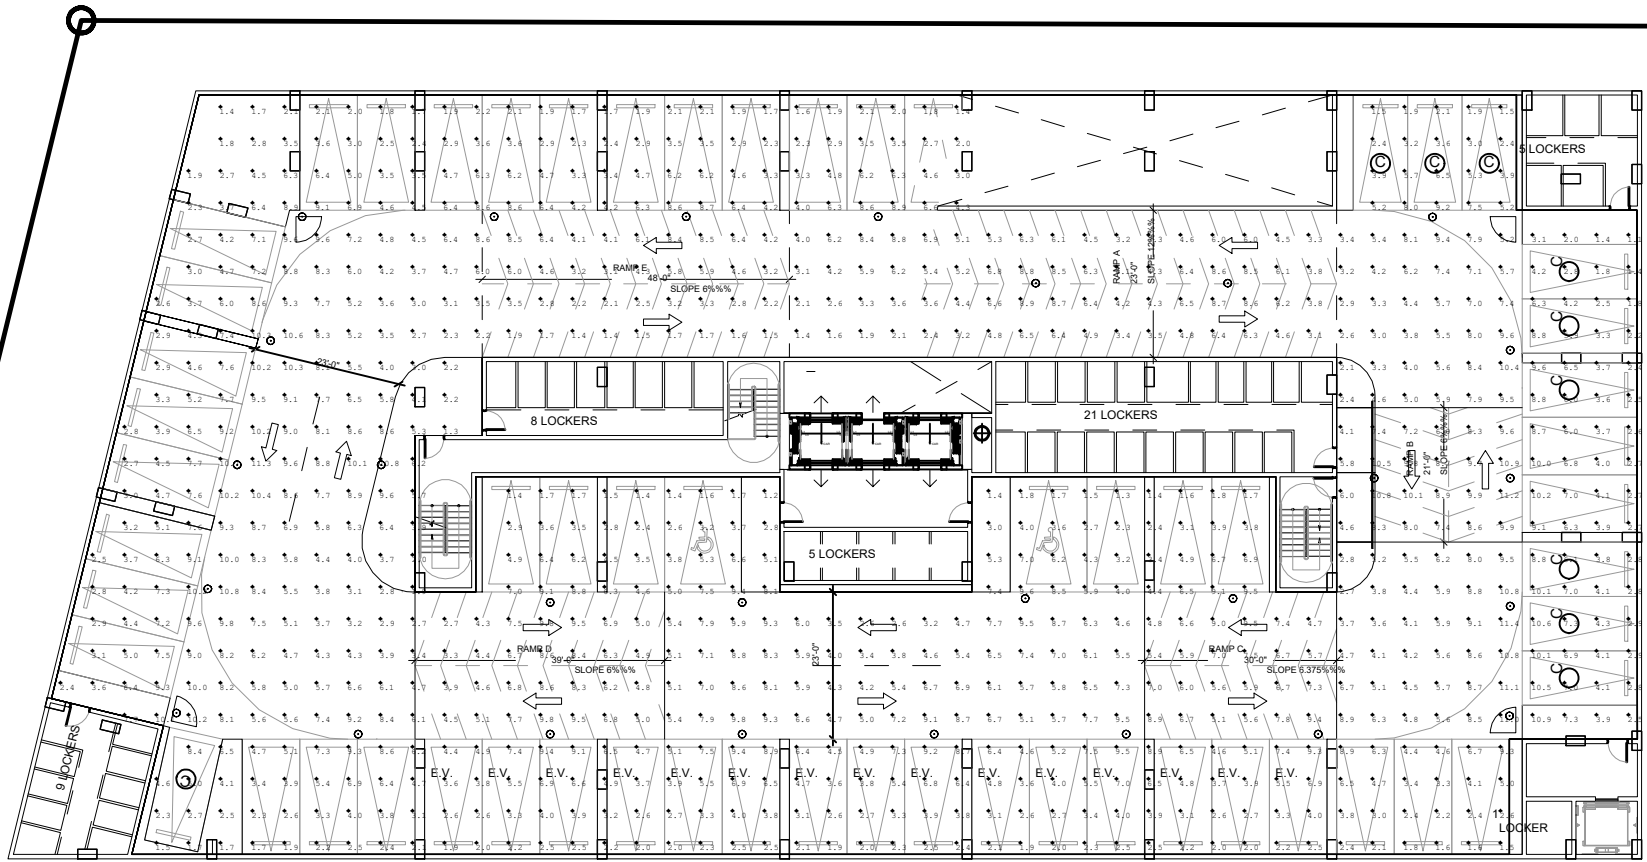

LEVEL 1.5  
PHOTOMETRICS - NORMAL  
SCALE: 1"= 30'-0"

Calculation Summary							
Label	CalcType	Units	Avg	Max	Min	Avg/Min	Max/Min
Parking Garage Floor	Illuminance	FC	12.24	81.1	1.2	6.8	103.5

Luminaire Schedule							
Symbol	Qty	Label	Arrangement	Description	LMF	Luminaire Lumens	Total Watts
○	18	01E	Single	Utopia Lighting LRC-36-SLEP-40K-180V-W8 (connected to	0.900	4810	83
○	18	01E	Single	Utopia Lighting LRC-36-SLEP-40K-180V-W8 (connected to	0.900	4810	83
○	11	01	Single	Utopia Lighting LRC-36-SLEP-40K-180V-W8	0.900	4810	83

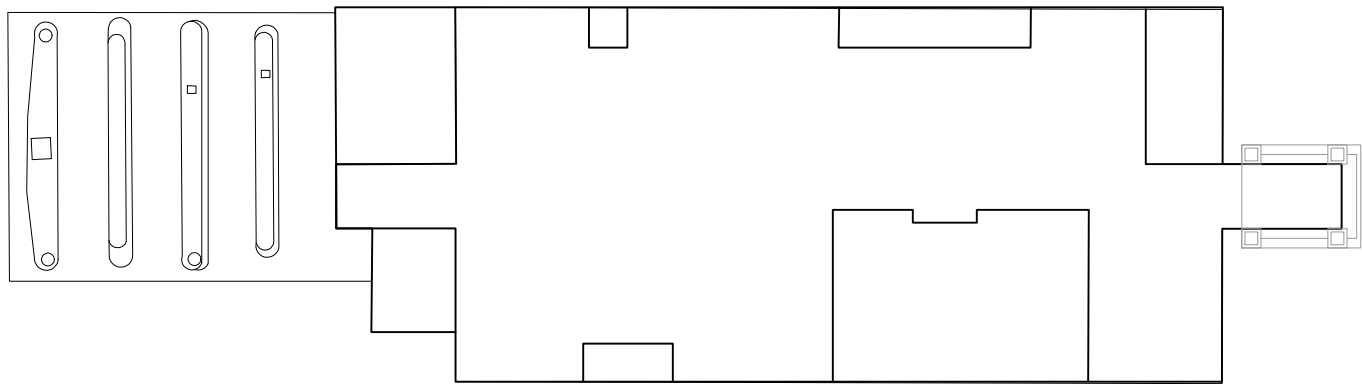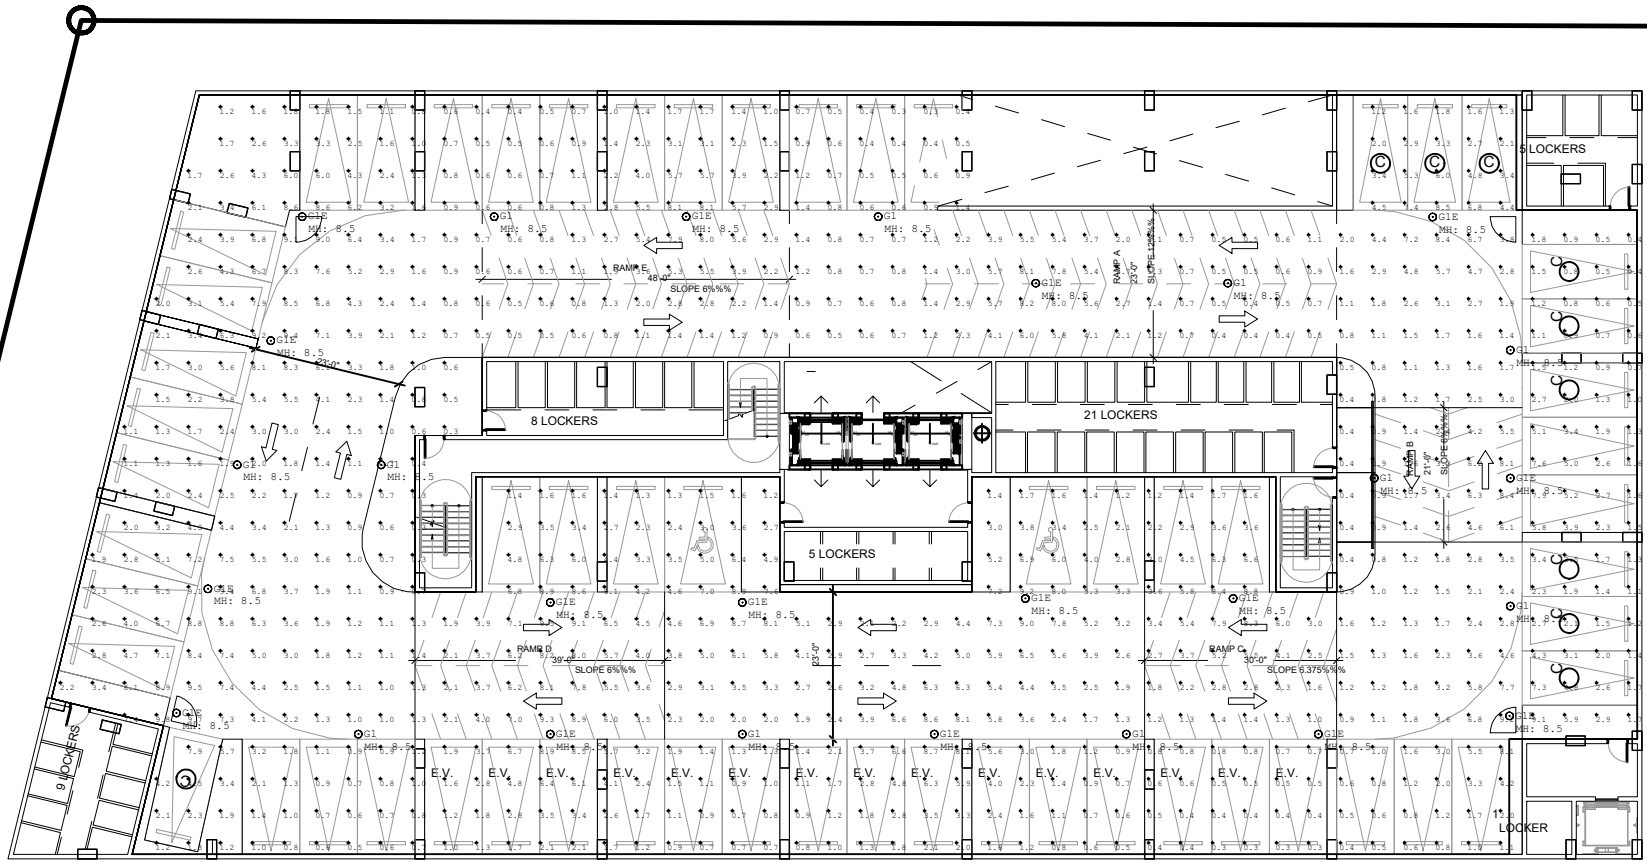

LEVEL 1.5  
PHOTOMETRICS - EMERGENCY  
SCALE: 1"= 30'-0"