


DRC

PZ25-12000043
03/04/2026

Project No. 330134202

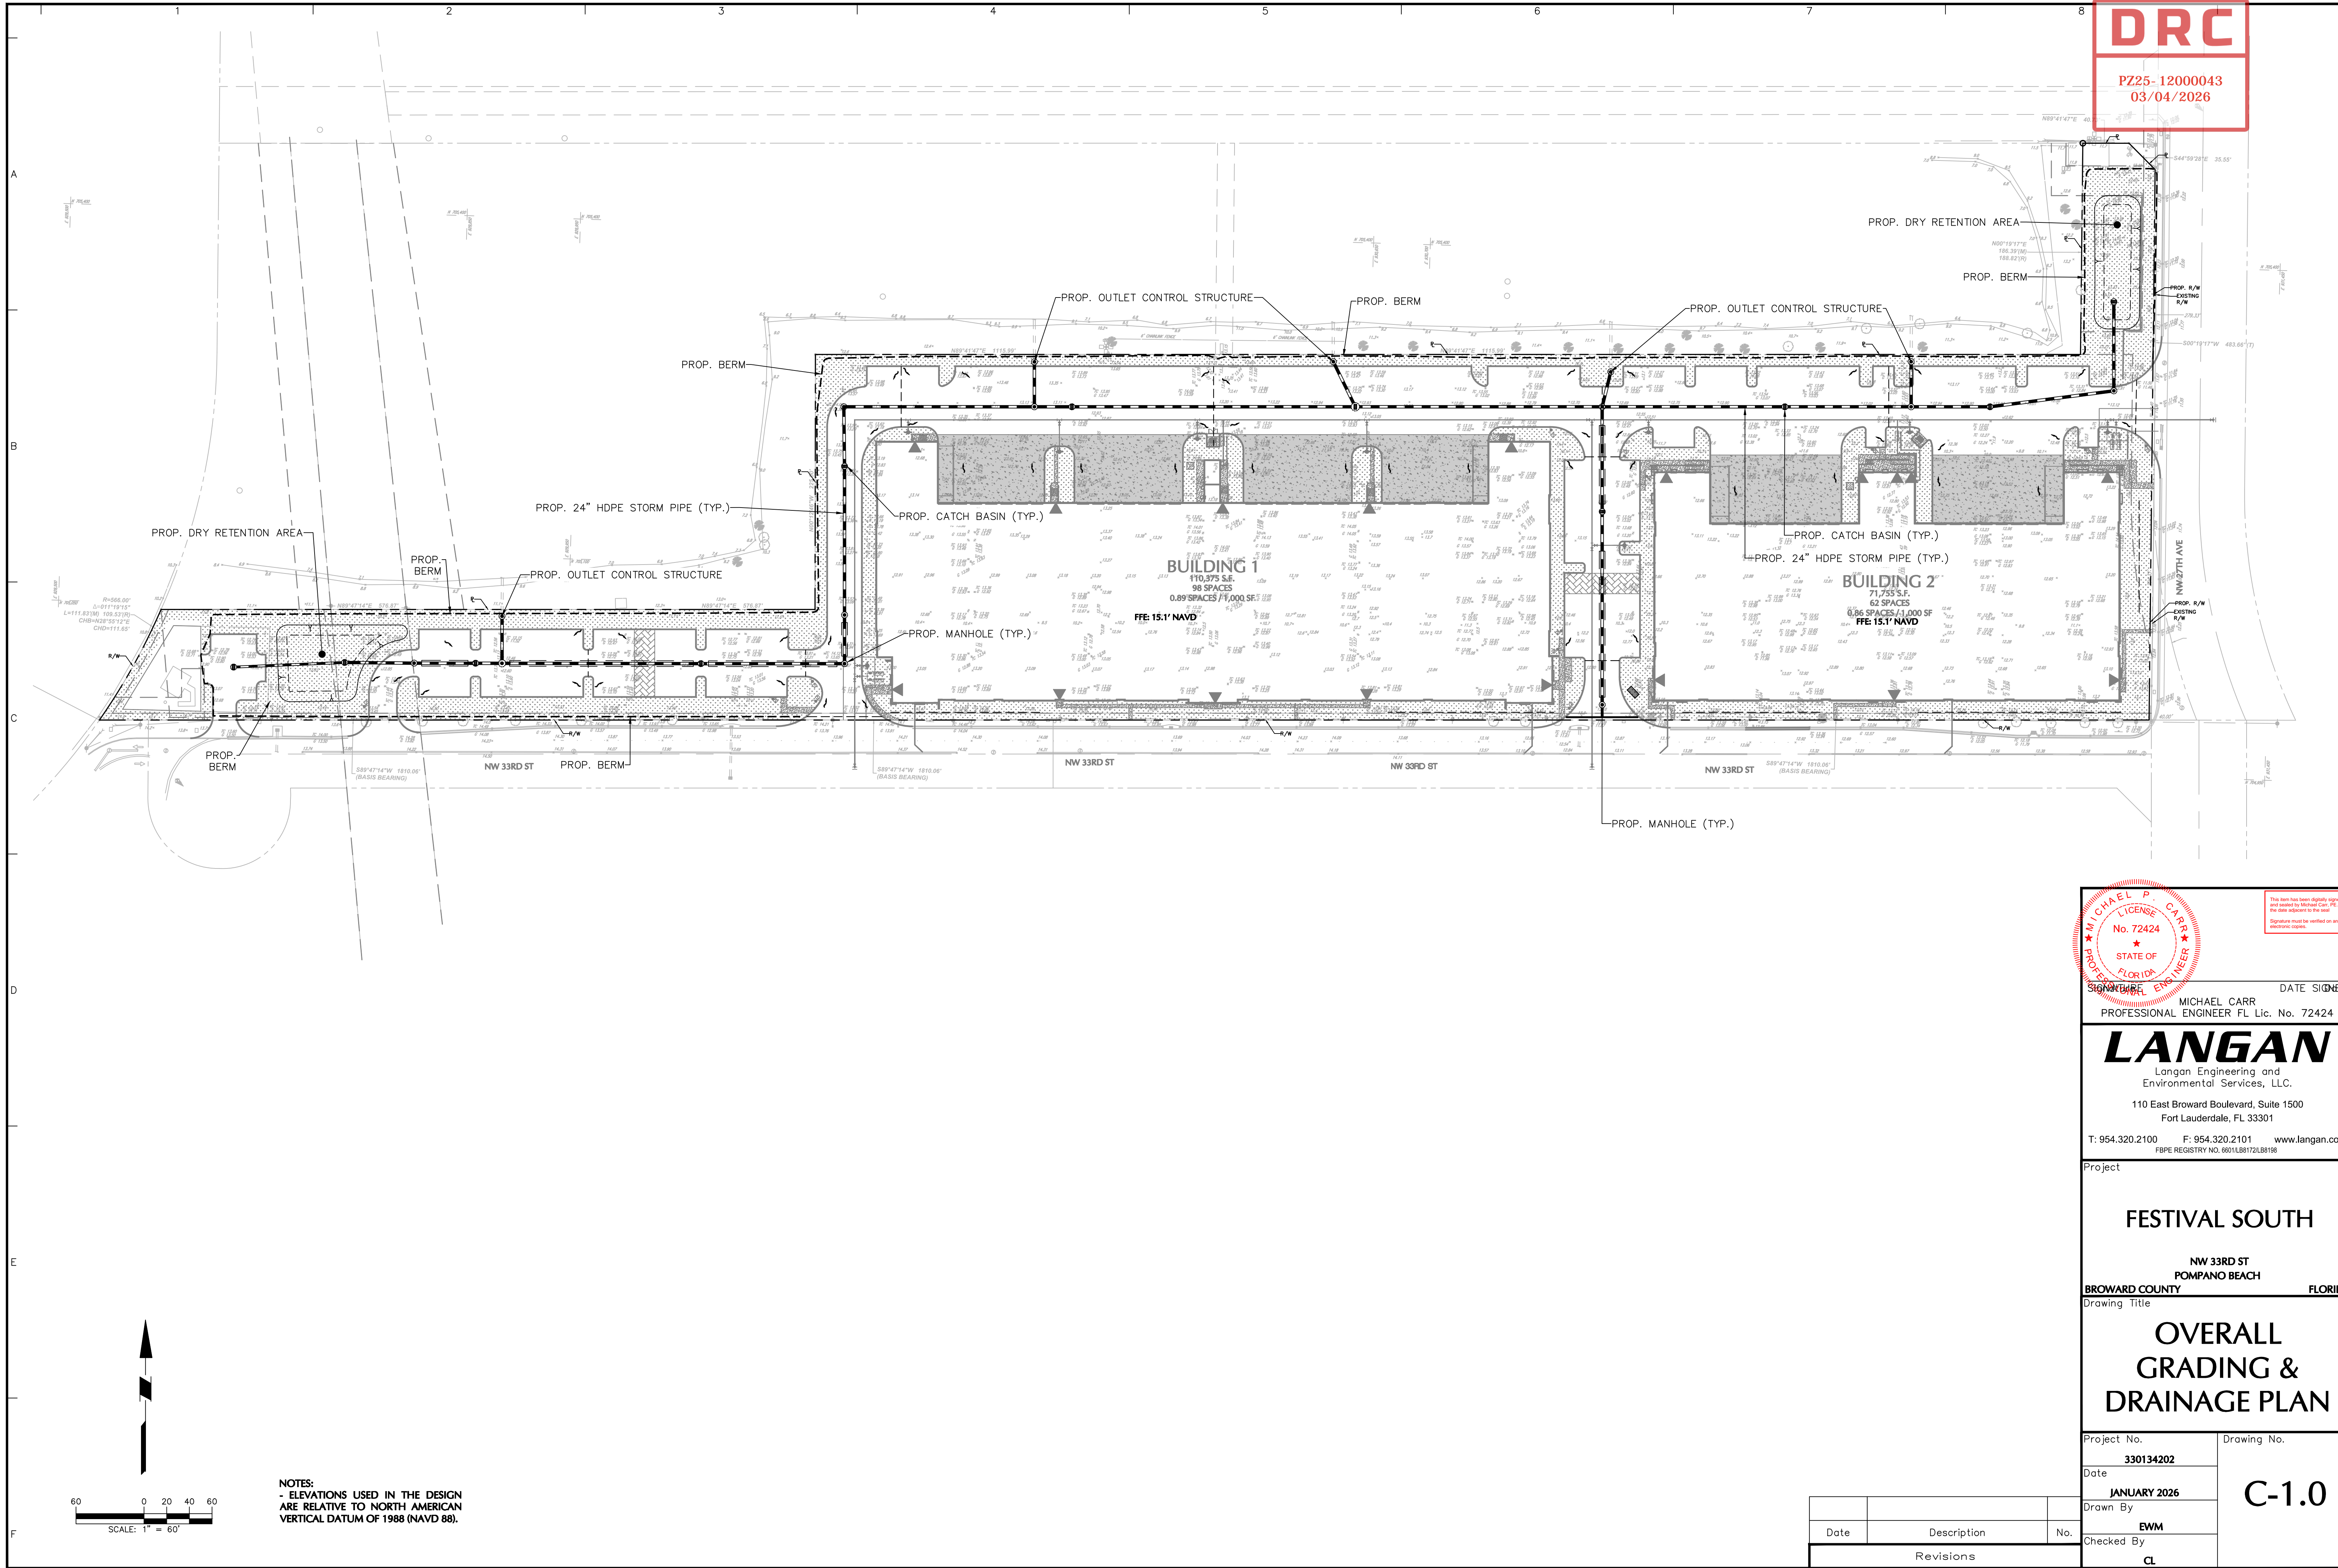

STATE OF FLORIDA
MICHAEL P. CARR
No. 72424
PROFESSIONAL ENGINEER
DATE SIGNED

LANGAN
Langan Engineering and
Environmental Services, LLC.
110 East Broward Boulevard, Suite 1500
Fort Lauderdale, FL 33301

T: 954.320.2100 F: 954.320.2101 www.langan.com
FBPE REGISTRY NO. 65011.B8172L.B8198

Project

FESTIVAL SOUTH

NW 33RD ST
POMPANO BEACH
BROWARD COUNTY FLORIDA
Drawing Title

**OVERALL
GRADING &
DRAINAGE PLAN**

Project No. 330134202	Drawing No. C-1.0
Date JANUARY 2026	
Drawn By EWM	
Checked By CL	

Date	Description	No.
Revisions		