

Project: **FESTIVAL FLEA MARKET SOUTH**
NW 27TH AVE & NW 33RD STREET, POMPANO BEACH, FL
LANDSCAPE PLAN

[illegible]

 

Seal:

Lic. # LA6667290
Member: A.S.L.A.


Drawing: Landscape Plan
 Date: 11/05/2025
 Scale: See Left
 Drawn by: MAV
 Sheet No.:

 L-6
 Cad Id.: 2025-060

Scale: 1" = 20'-0"

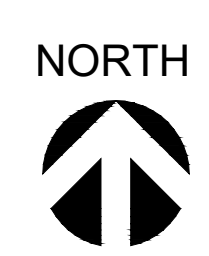

Note: Visibility and unobstructed working space must be maintained from fire apparatus access routes to fire protection and life safety appliances/equipment. The only landscaping should be grass or much no plants or shrubs. These include but not limited to: Fire hydrants, fire department connections (FDC), post indicating valves (PIV), fire sprinkler risers, fire alarm control panels and electrical room locations require a minimum 36-inch clearance path to and on all sides. Fire hydrants require 36-inch clear space each side and rear with a 60-inch wide clear access from the fire apparatus access to fire hydrant. (NFPA 1-2021 Ch. 18 Sec. 18.5.7)

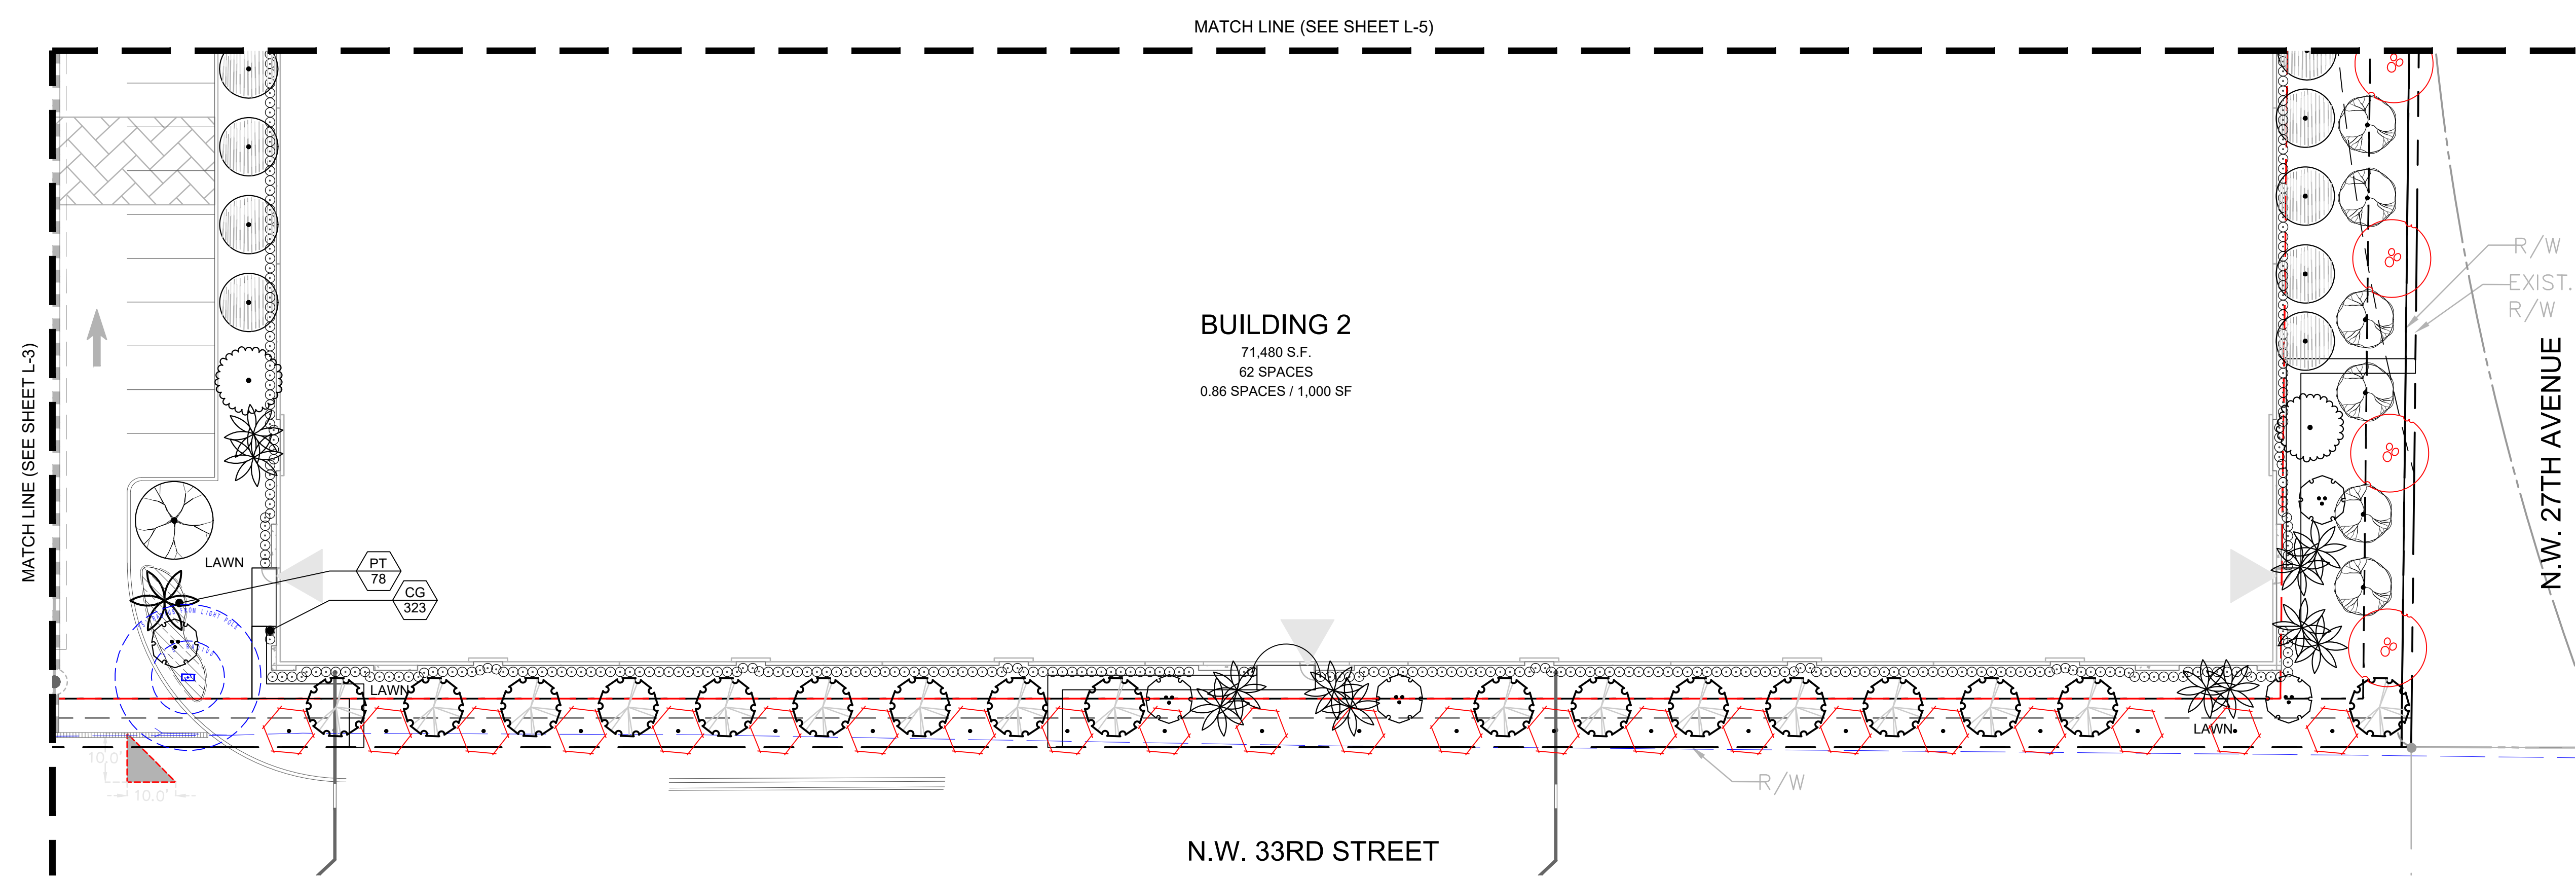

PROGRESS SET