


NOTES:

- SEE IRRIGATION LEGEND FOR MAINLINE AND LATERAL LINE PIPE SIZE AND TYPE.
- DIRECT BURIAL CONTROL WIRES SHALL BE INSTALLED IN SCH. 40 PVC ELECTRICAL CONDUIT IF REQUIRED.
- 2-WIRE IRRIGATION WIRE SHALL BE INSTALLED IN SCH. 40 PVC ELECTRICAL CONDUIT.
- DETECTABLE LOCATOR TAPE SHALL BE LOCATED SIX INCHES (6") ABOVE THE ENTIRE MAINLINE RUN.
- FINISHED GRADE
- PAVEMENT
- NON-PRESSURIZED LINE (LATERAL LINE)
- DETECTABLE LOCATOR TAPE
- PRESSURIZED LINE (MAINLINE)
- DIRECT BURIAL LOW VOLTAGE CONTROL WIRES

1 IRRIGATION TRENCHING

1 1/2" = 1'-0"


FX-IRRG-FX-AUXEQ-08

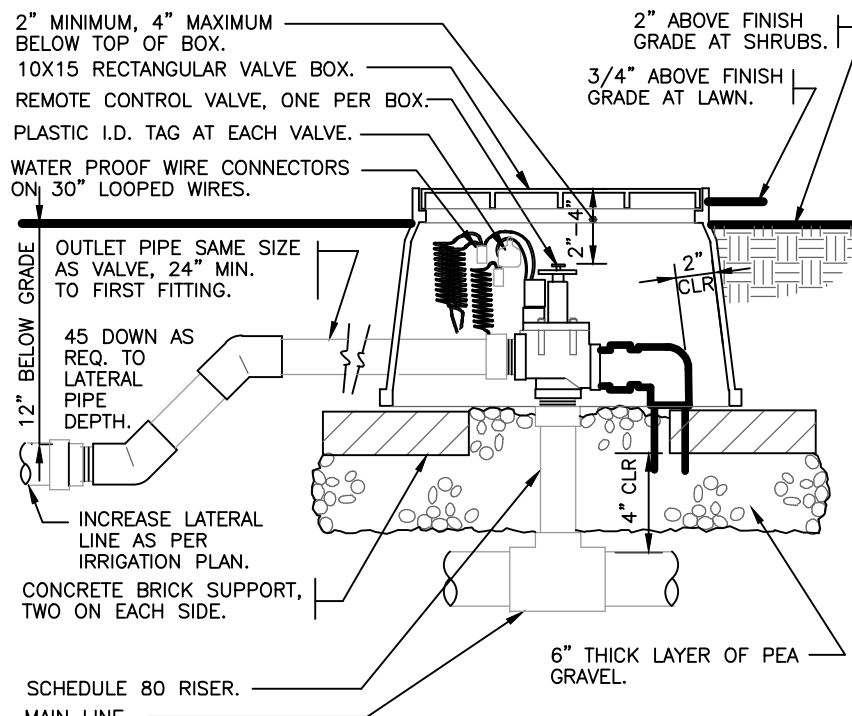

2 ELECTRIC REMOTE CONTROL VALVE

1 1/2" = 1'-0"


328406.13-01

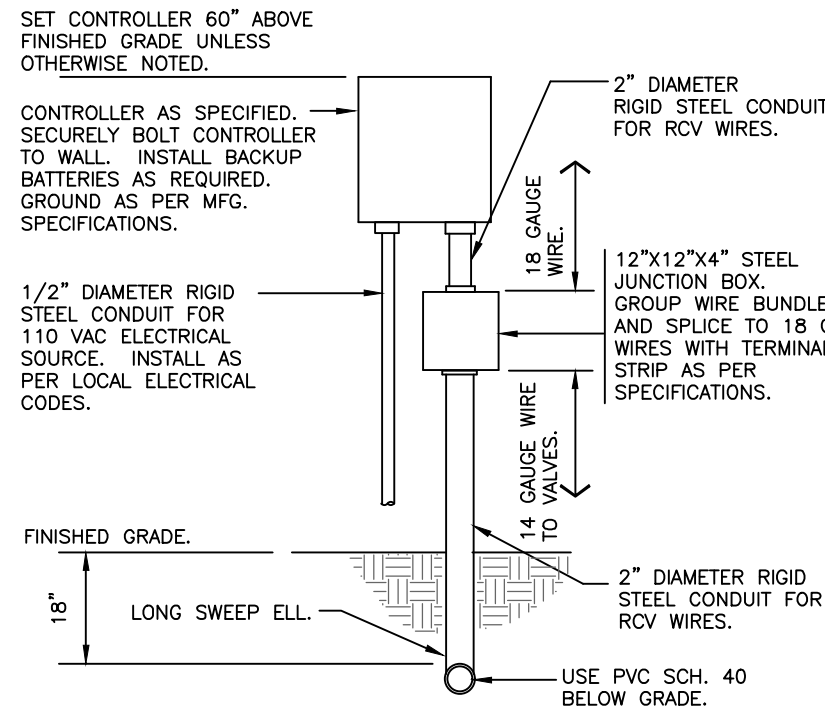

3 WALL MOUNT CONTROLLER

1" = 1'-0"

328409.13-02

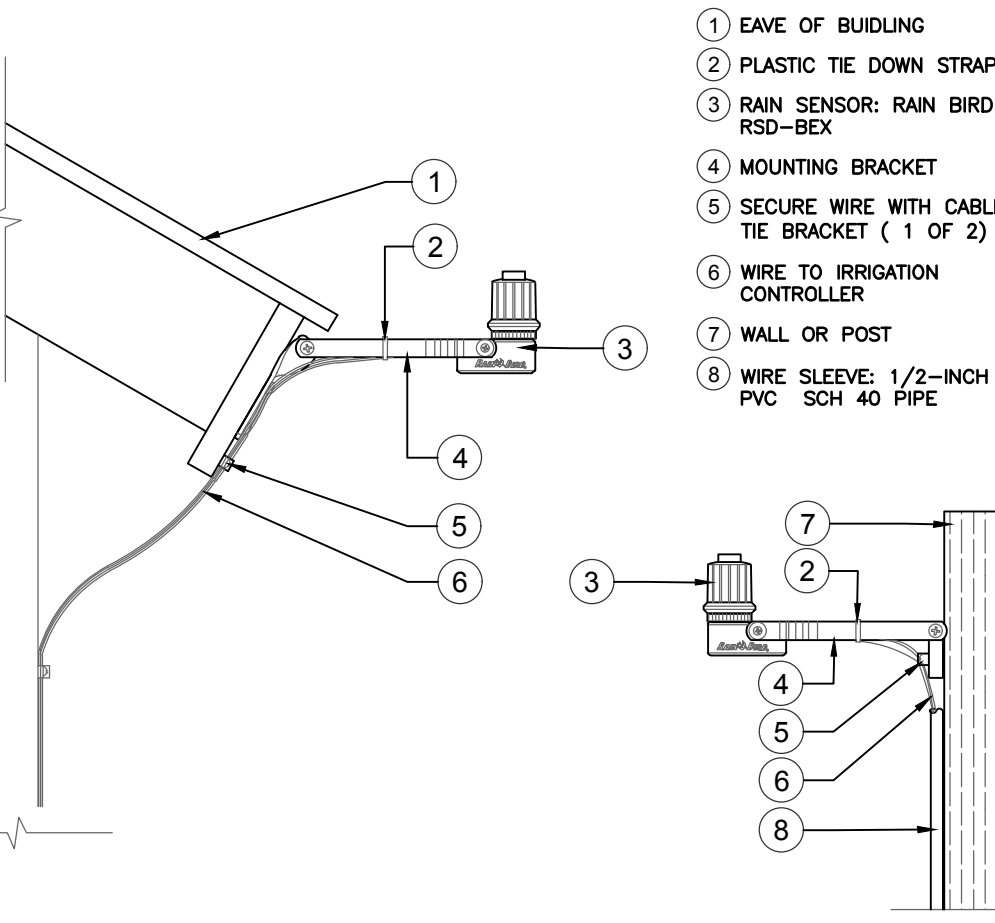


4 RAIN BIRD RSD RAIN SENSOR

1" = 1'-0"

FX-IRRG-RAIN-SENS-02


SLEEVING SCHEDULE	
PIPE SIZE	SLEEVING PIPE SIZE
3/4"	2"
1"	2"
1-1/4"	3"
1-1/2"	3"
2"	4"
3"	6"
4"	8"
6"	12"
8"	16"

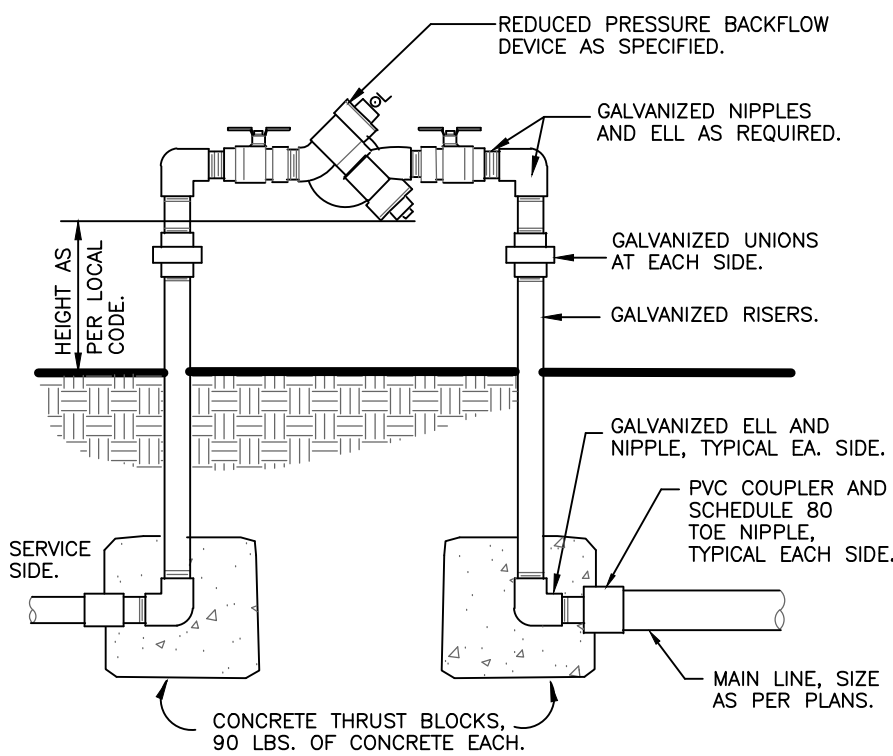

5 REDUCED PRESSURE BACKFLOW DEVICE

1" = 1'-0"


328409.43-01

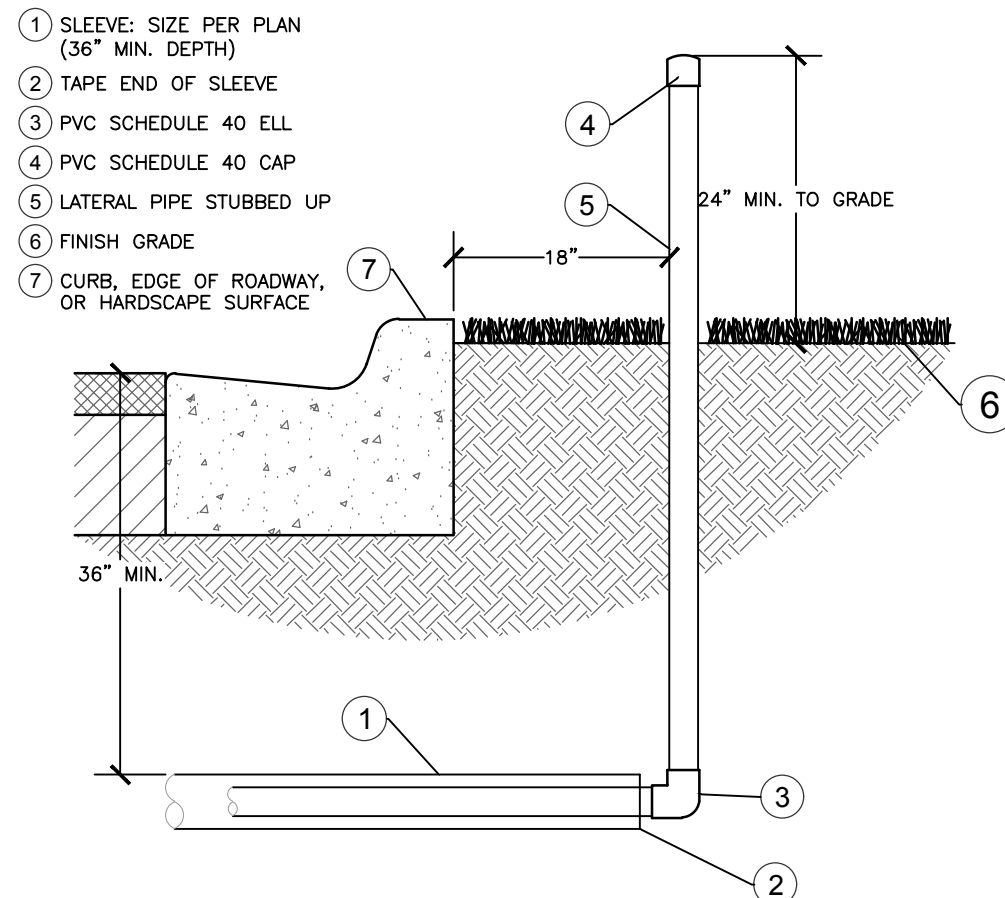

6 PIPE SLEEVING

1" = 1'-0"


328409.76-32

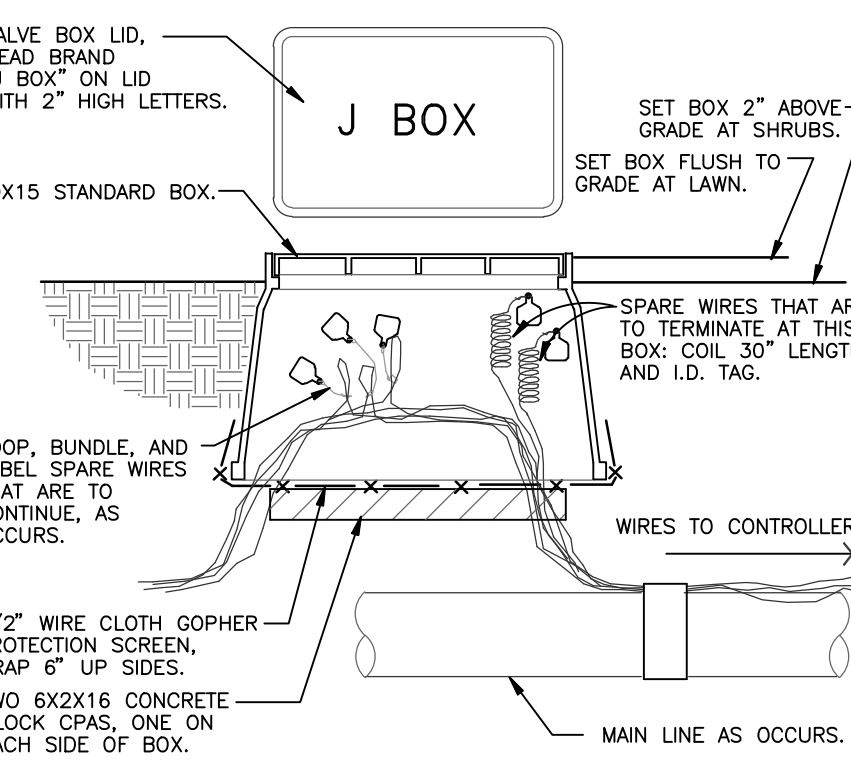

7 WIRE BUNDLE JUNCTION BOX

1 1/2" = 1'-0"


328409.79-01

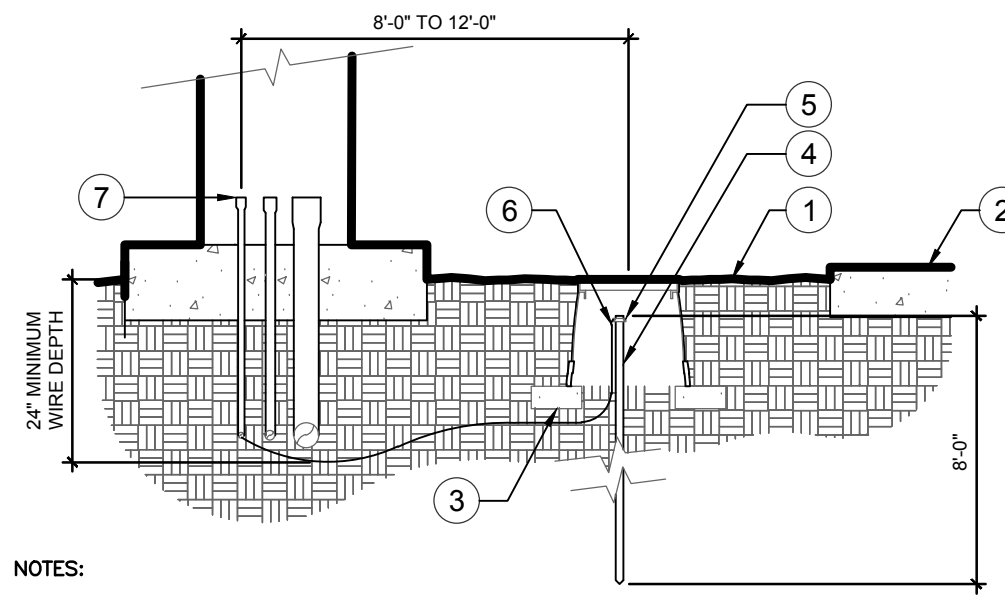

8 GROUNDING ROD

1" = 1'-0"


FX-IRRG-FX-AUXEQ-01

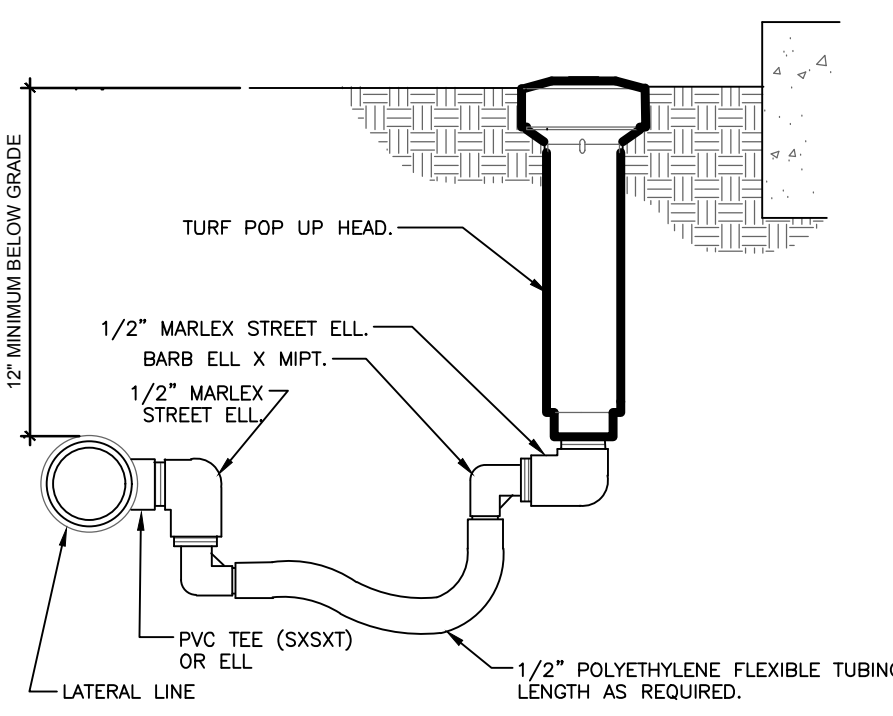

9 TURF SPRAY FLEX ASSEMBLY

3" = 1'-0"


FX-IRRG-FX-HEAD-04

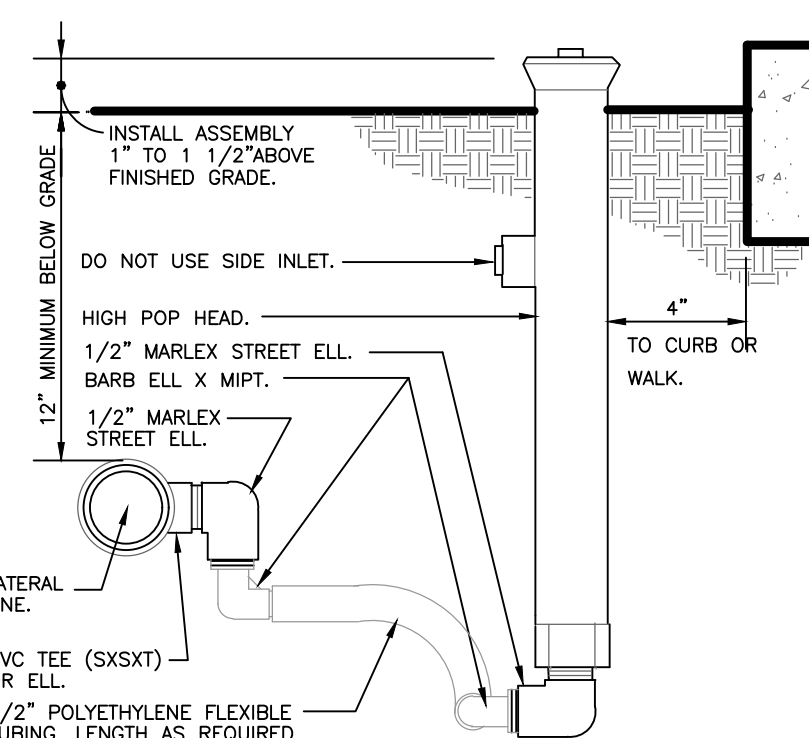

10 SHRUB SPRAY HIGHPOP W/FLEX ASSEMBLY

3" = 1'-0"


328403.29-01

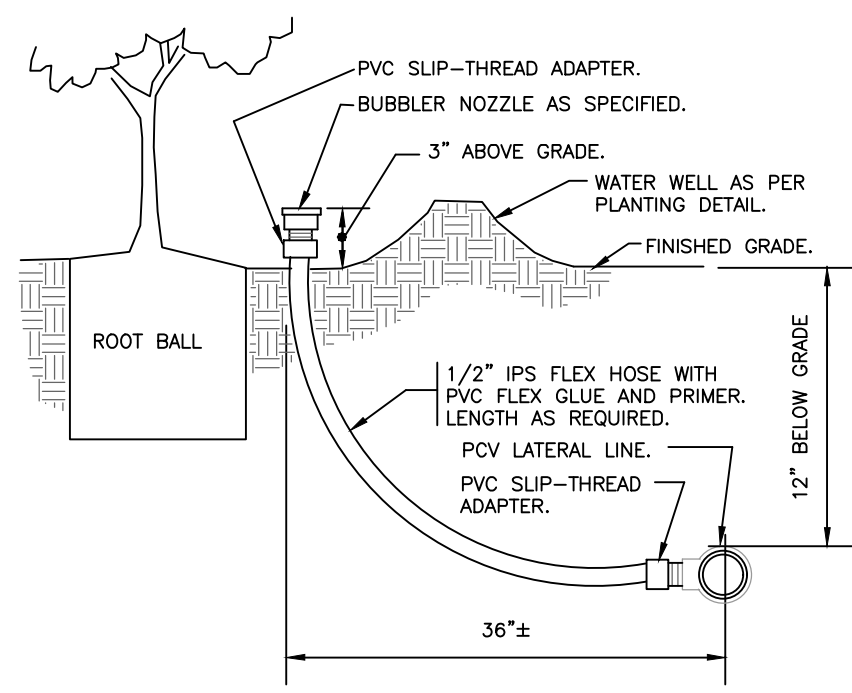

11 BUBBLER ON FLEX HOSE RISER

3" = 1'-0"

328403.53-01

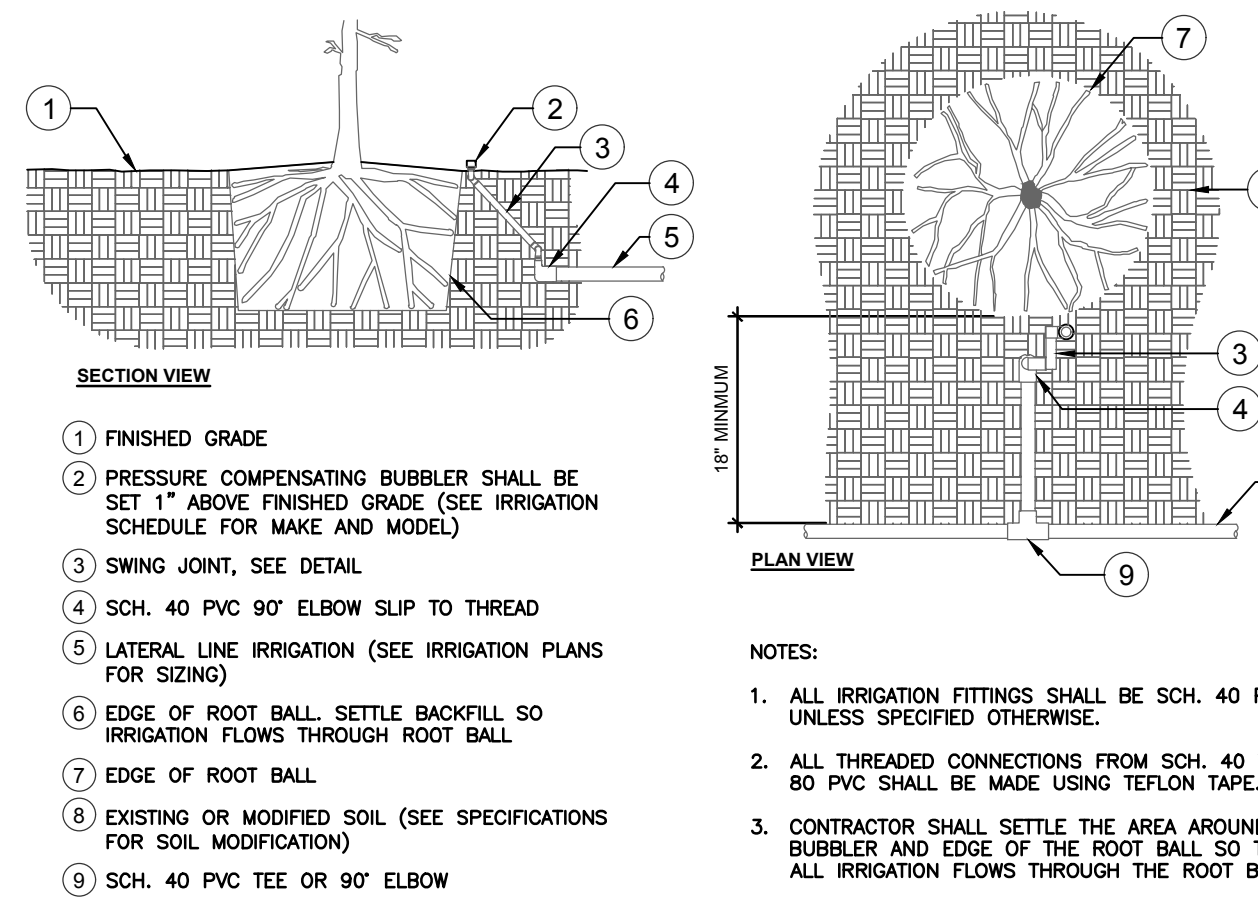

12 IRRIGATION BUBBLER W/ LAYOUT


3/4" = 1'-0"

FX-IRRG-FX-BUBB-04

DRC

PZ25-12000026
12/03/2025

AAL
Architectural Alliance Landscape
612 SW 4th Ave., Fort Lauderdale, FL 33315
TEL: 954-764-8858
EMAIL: Blue@archall.net

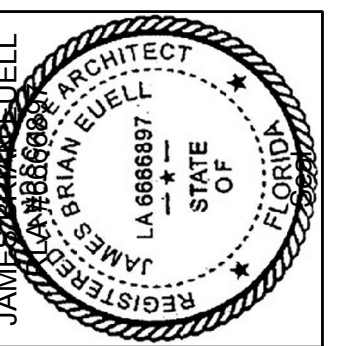

Revision Dates

SITE PLAN SUBMITTAL SET
RIISING TIDE CAR WASH
POMPANO BEACH, FLORIDA

Sheet Description

IRRIGATION
DETAILS

Release Date
07-16-2025

Project Number
2505

Drawing Number

L-301

Sheet 2 OF 3