

REV.	DATE	DESCRIPTION
01	05-13-2025	DRC SUBMITTAL

ALL MEASUREMENTS MUST BE VERIFIED BEFORE
BEGINNING THE WORKS. NO MEASUREMENTS ARE TO
BE SCALED DIRECTLY FROM THIS DRAWING.



Key section

Client
VERA FUND
NICK POLYUSHKIN
& YURI KHARITONENKOV
TEL: 305.833.3303

Project
**1600 S FEDERAL HIGHWAY
(MIXED-USE PROJECT)**
1600 SOUTH FEDERAL HIGHWAY,
POMPANO BEACH, FL 33062

Title LEVEL 02 PHOTOMETRICS	
Drawn J. WU	Field ARCHITECTURE
Verified N. TREMBLAY	Scale as shown
Approved S. L'ECUYER	Date 08-15-2025
Project Manager J. WU	Dwg. no. P-003
Project 24-838	



Calculation Summary								
Label	ColType	Units	Avg	Max	Min	Avg/Min	Max/Min	
Parking Garage Floor	Illuminance	FC	12.3	22.3	12.3	1.83	1.83	
Luminaire Schedule								
Symbol	Qty	Label	Arrangement	Description	LMF	Luminaire Lumens	Luminaire Watts	Total Watts
○	13	01	Single	Utopia Lighting LRC-36-SLED-40K-00V-W8	0.900	4810	37	481
○	18	01E	Single	Utopia Lighting LRC-36-SLED-40K-00V-W8 (Connected to Generator)	0.900	4810	37	666

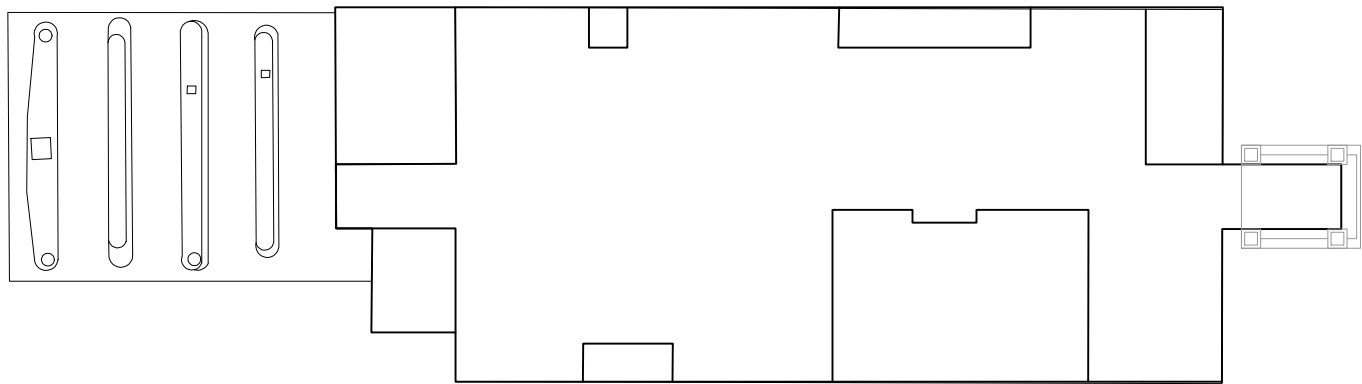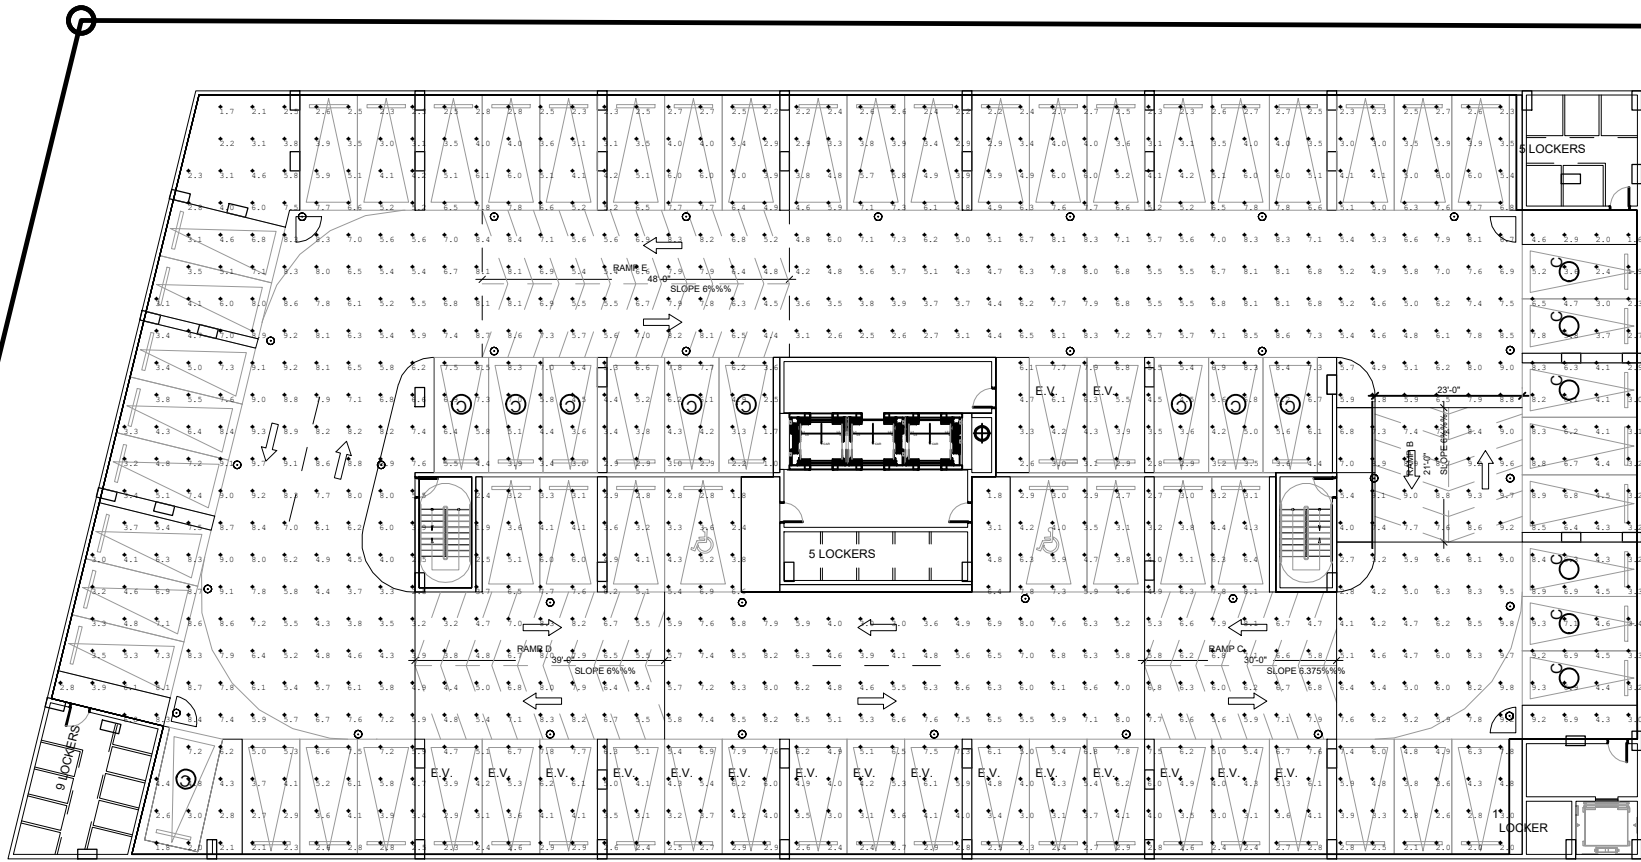

LEVEL 02
PHOTOMETRICS - NORMAL
SCALE: 1"= 30'-0"

AAC
PZ24- 12000027
09/10/2025

Calculation Summary								
Label	ColType	Units	Avg	Max	Min	Avg/Min	Max/Min	
Parking Garage Floor	Illuminance	FC	12.3	22.3	12.3	1.83	1.83	
Luminaire Schedule								
Symbol	Qty	Label	Arrangement	Description	LMF	Luminaire Lumens	Luminaire Watts	Total Watts
○	13	01	Single	Utopia Lighting LRC-36-SLED-40K-00V-W8	0.900	4810	37	481
○	18	01E	Single	Utopia Lighting LRC-36-SLED-40K-00V-W8 (Connected to Generator)	0.900	4810	37	666

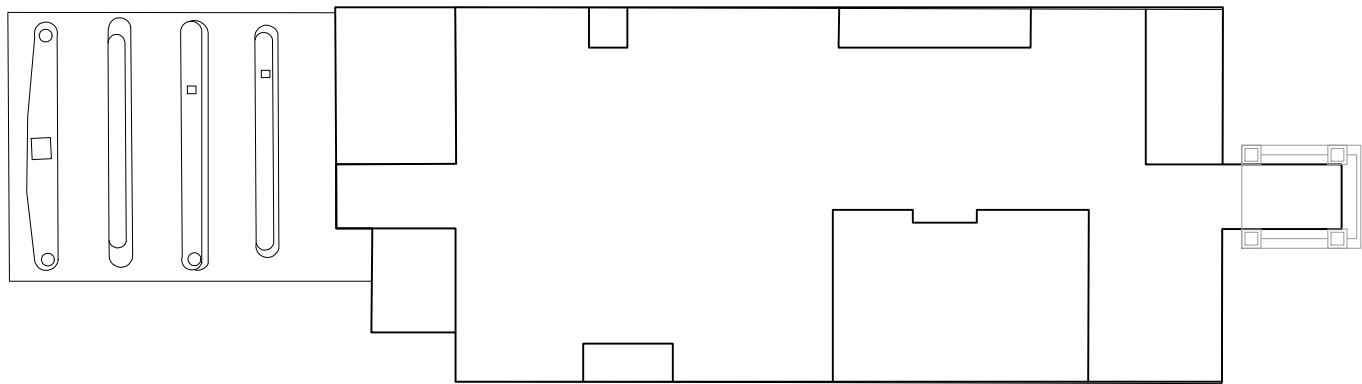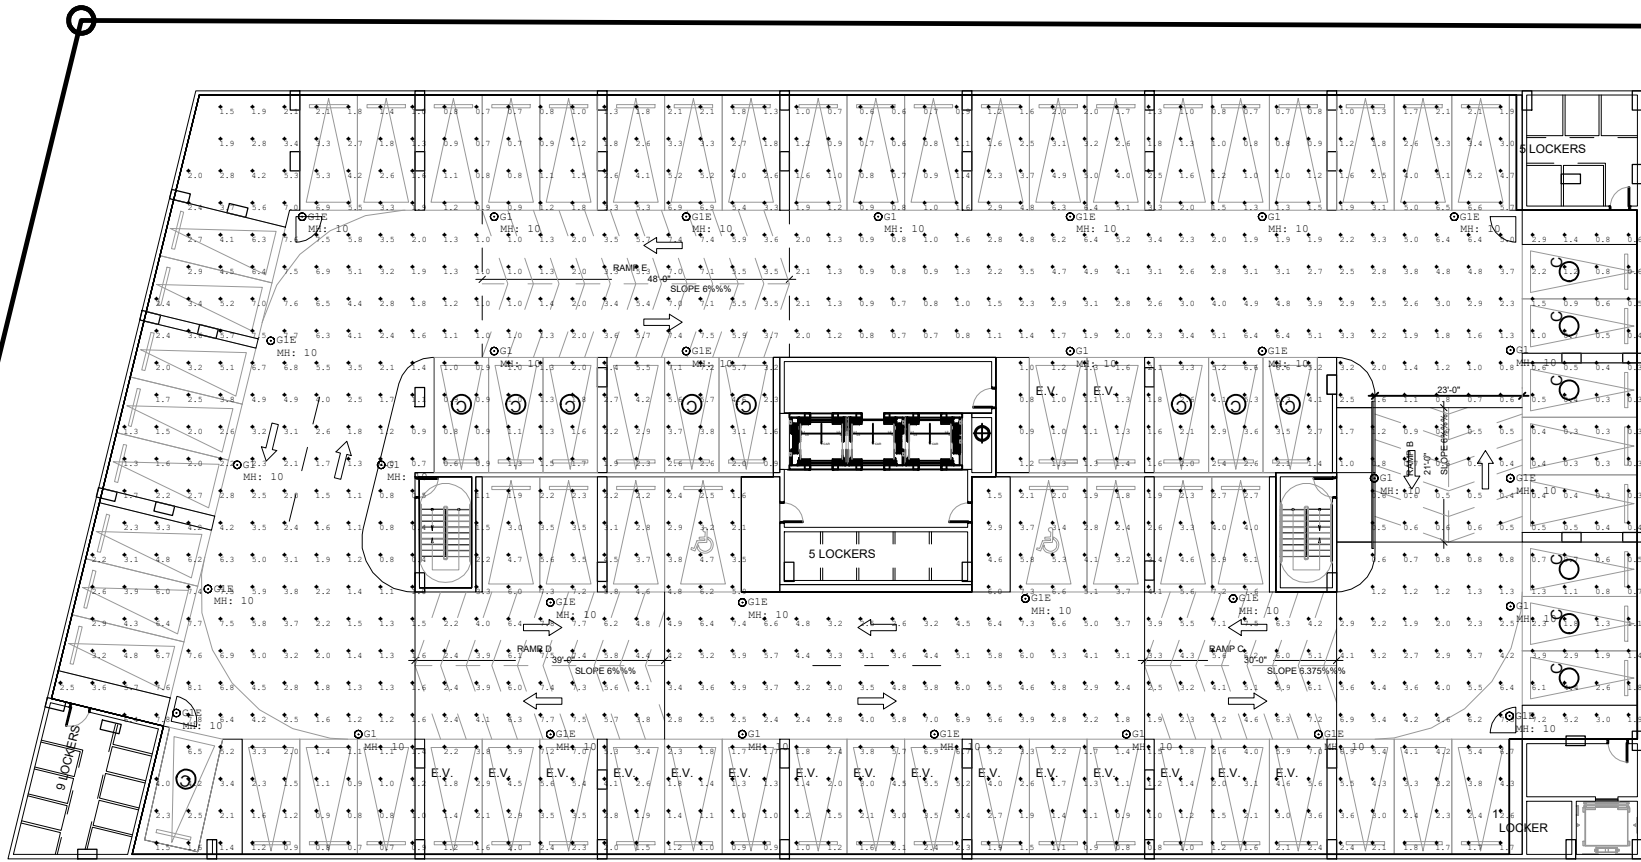

LEVEL 02
PHOTOMETRICS - EMERGENCY
SCALE: 1"= 30'-0"