 
 



Luminaire Schedule					LLF	Luminaire Lumens	Luminaire Watts	Total Watts
Symbol	Qty	Label	Arrangement	Description				
	3	WA	Single	Cree Lighting OSQL-B-30L-40K7-4M-XX-NM-XX, Wall Mount	0.900	29097	202	606
	9	SB	Single	Cree Lighting OSQL-B-30L-40K7-4M-XX-NM-XX / OSQ-BLSLF, Pole Mount	0.900	22298	202	1818

Calculation Summary								
Label	CalcType	Units	Avg	Max	Min	Avg/Min	Max/Min	
SPill	Illuminance	Fc	0.04	0.5	0.0	N.A.	N.A.	
Parking Lot	Illuminance	Fc	3.05	8.8	1.0	3.05	8.80	

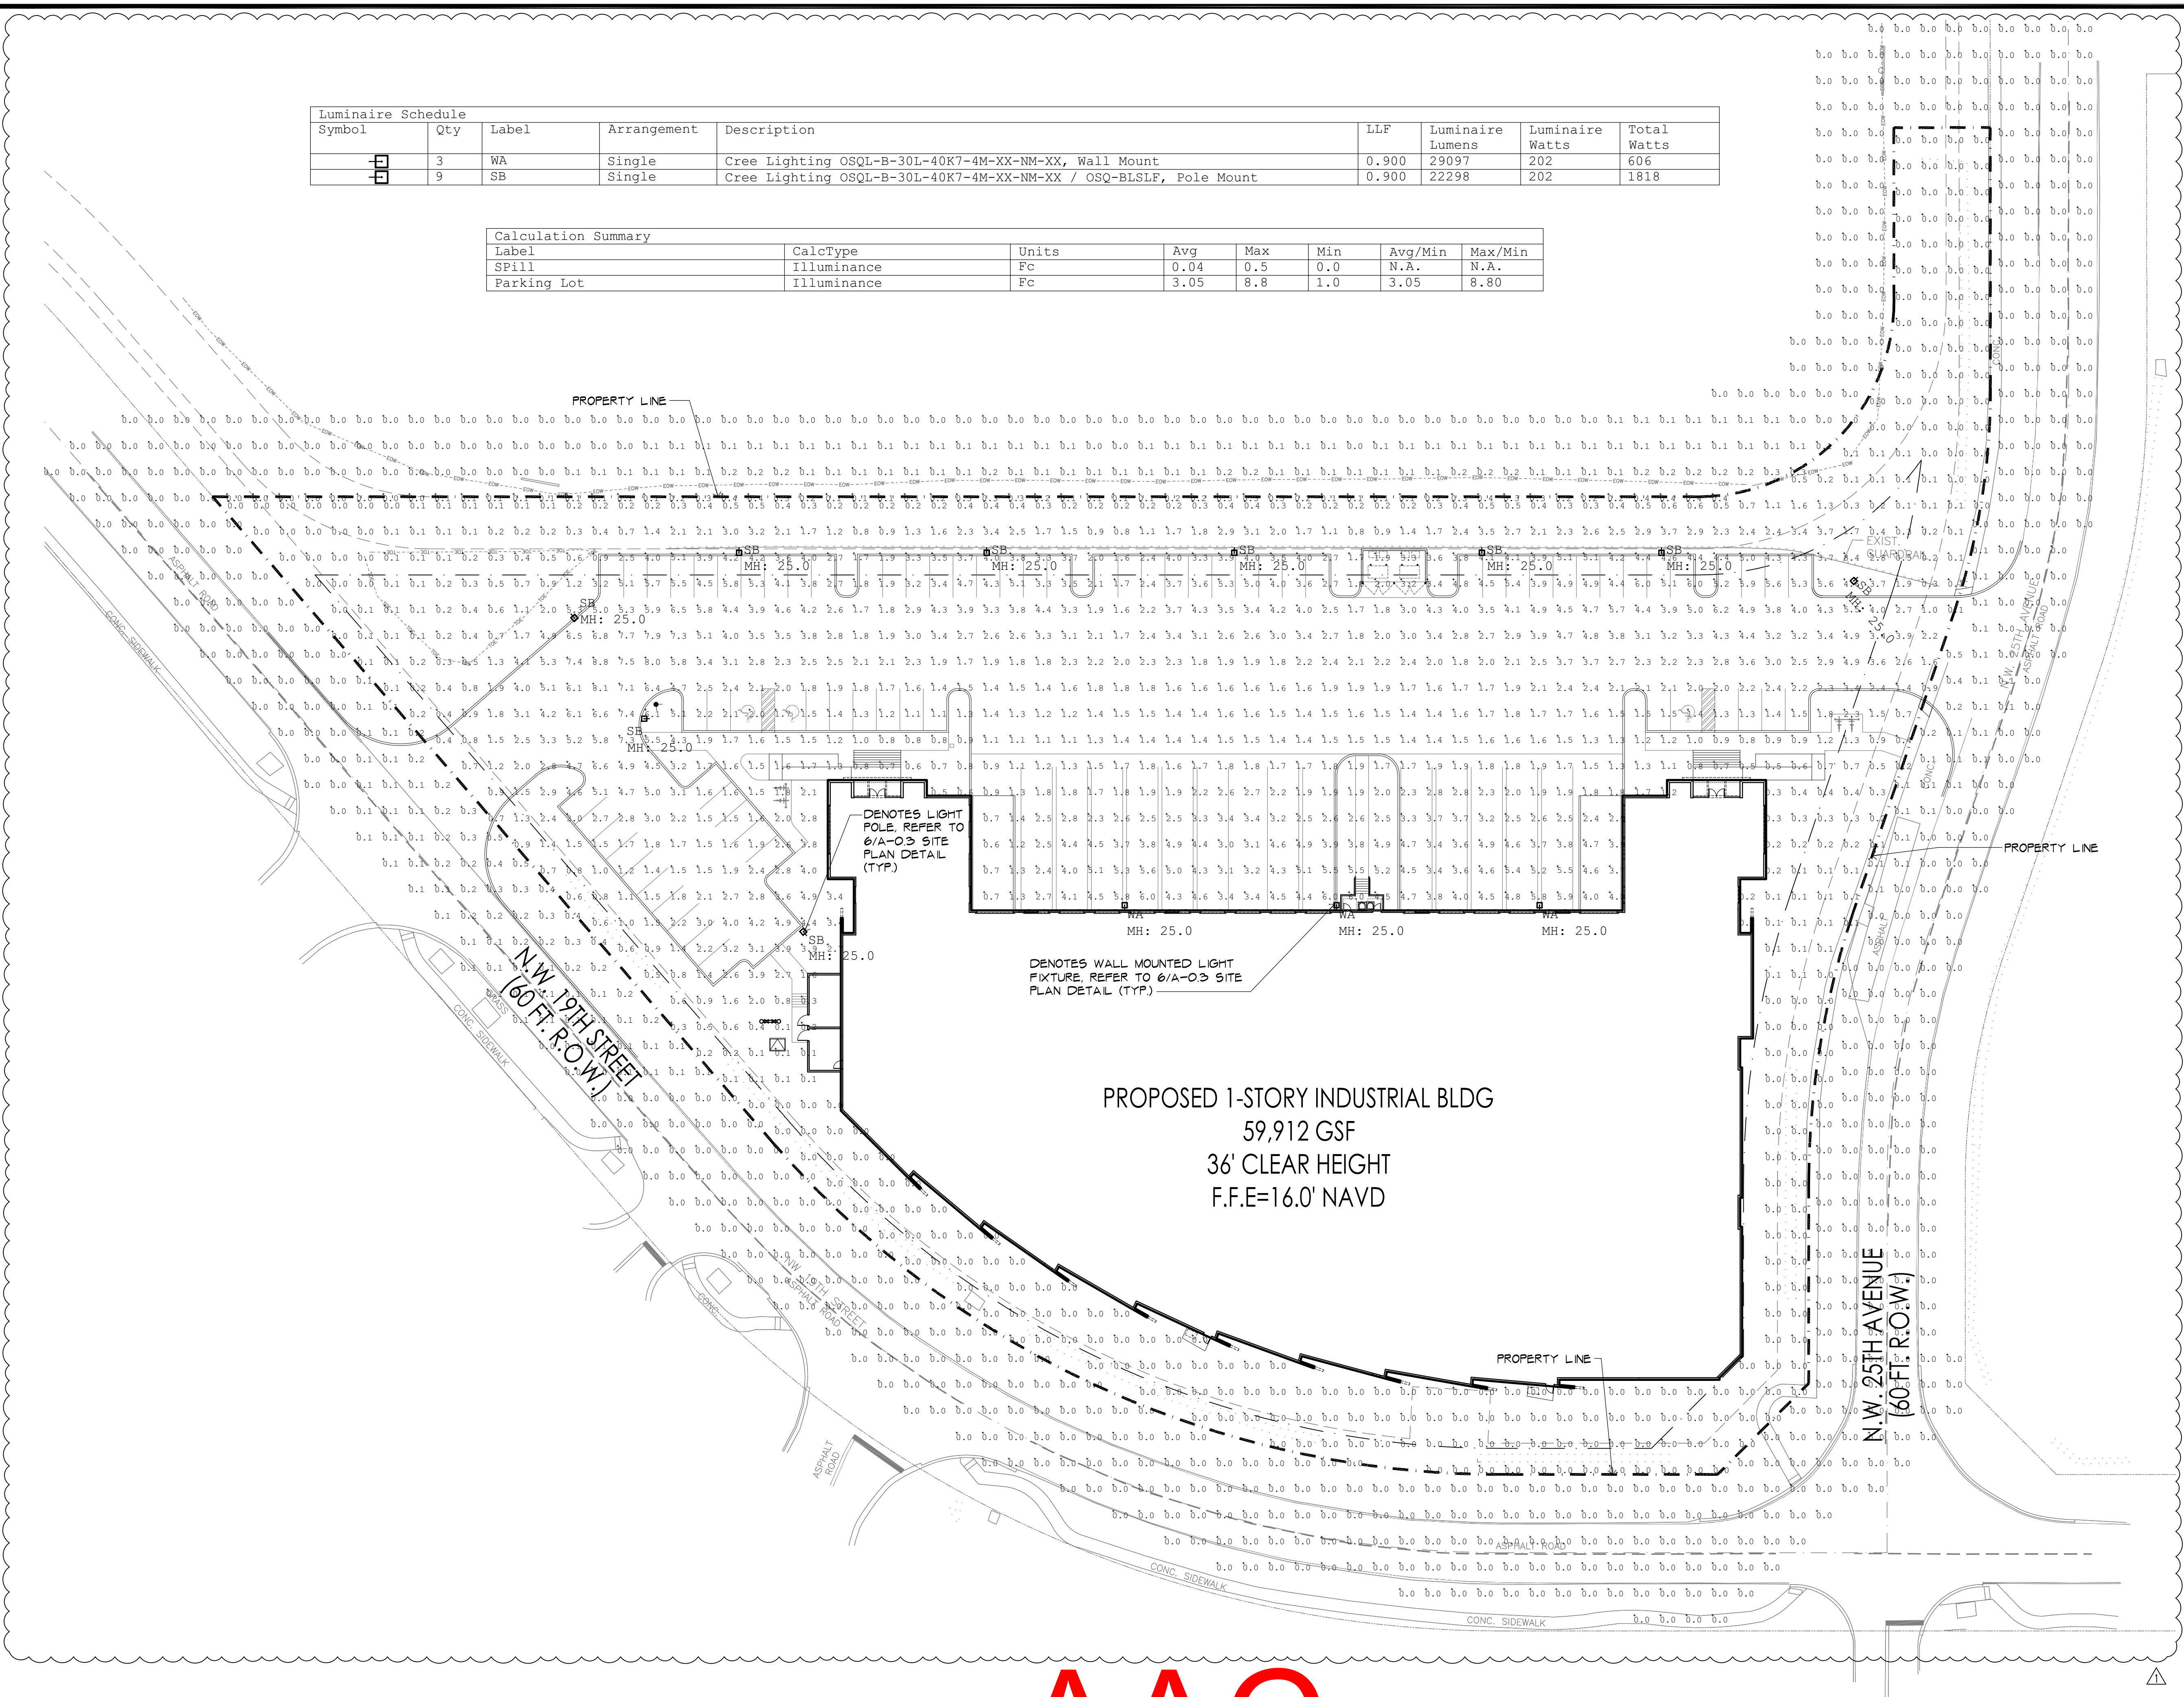

AAC

PZ22-12000042
03/07/2023

FIRST POMPANO LOGISTICS CENTER I

2551 NW 19th Street
Pompano Beach, FL 33069

2022-12-26
DRC COMMENTS

NO
DATE
REVISION

ALL DRAWINGS, SPECIFICATIONS AND RELATED DOCUMENTS ARE THE COPYRIGHT PROPERTY OF THE ARCHITECT AND MUST BE RETURNED UPON REQUEST. REPRODUCTION OF DRAWINGS, SPECIFICATIONS AND RELATED DOCUMENTS IN PART OR WHOLE IS FORBIDDEN WITHOUT THE ARCHITECT'S WRITTEN PERMISSION.

CONTRACTOR MUST CHECK AND VERIFY ALL DIMENSIONS AND FIELD CONDITIONS AND NOTIFY ARCHITECT/ENGINEER IMMEDIATELY OF ANY DISCREPANCIES.

HNM
ARCHITECTURE

3705 North Federal Highway • Delray Beach, Florida 33483 • T: 561.733.2223
info@hnmarchitect.com • A00000702 • www.hnmarchitect.com

Digitally signed
by Michael
Hanlon
Date:
2022.12.27
16:24:26-05'00'

MICHAEL W. HANLON
FLORIDA REGISTERED ARCHITECT - REG. NUMBER: AR0019270
ELECTRONIC SIGNATURE SERIAL NUMBER:

HNM PROJECT NUMBER:
20-043.1

ISSUED DATE:
2022-11-17

SCALE:
1" = 30'-0"

TITLE:
PHOTOMETRICS
SITE PLAN

DRAWING NUMBER:

A-0.2