



THE SATORI

4211 N FEDERAL HIGHWAY
POMPAHO BEACH, FL

4211 N FEDERAL HIGHWAY
POMPANO BEACH, FL

Sheet Title
PHOTOMETRIC
PLAN


1	Revision Dates
2	10/27/25 - CITY COMMENTS
3	12/16/25 - CITY COMMENTS




— Date —
12/16/2025

Sheet Number
SP-3

Sea

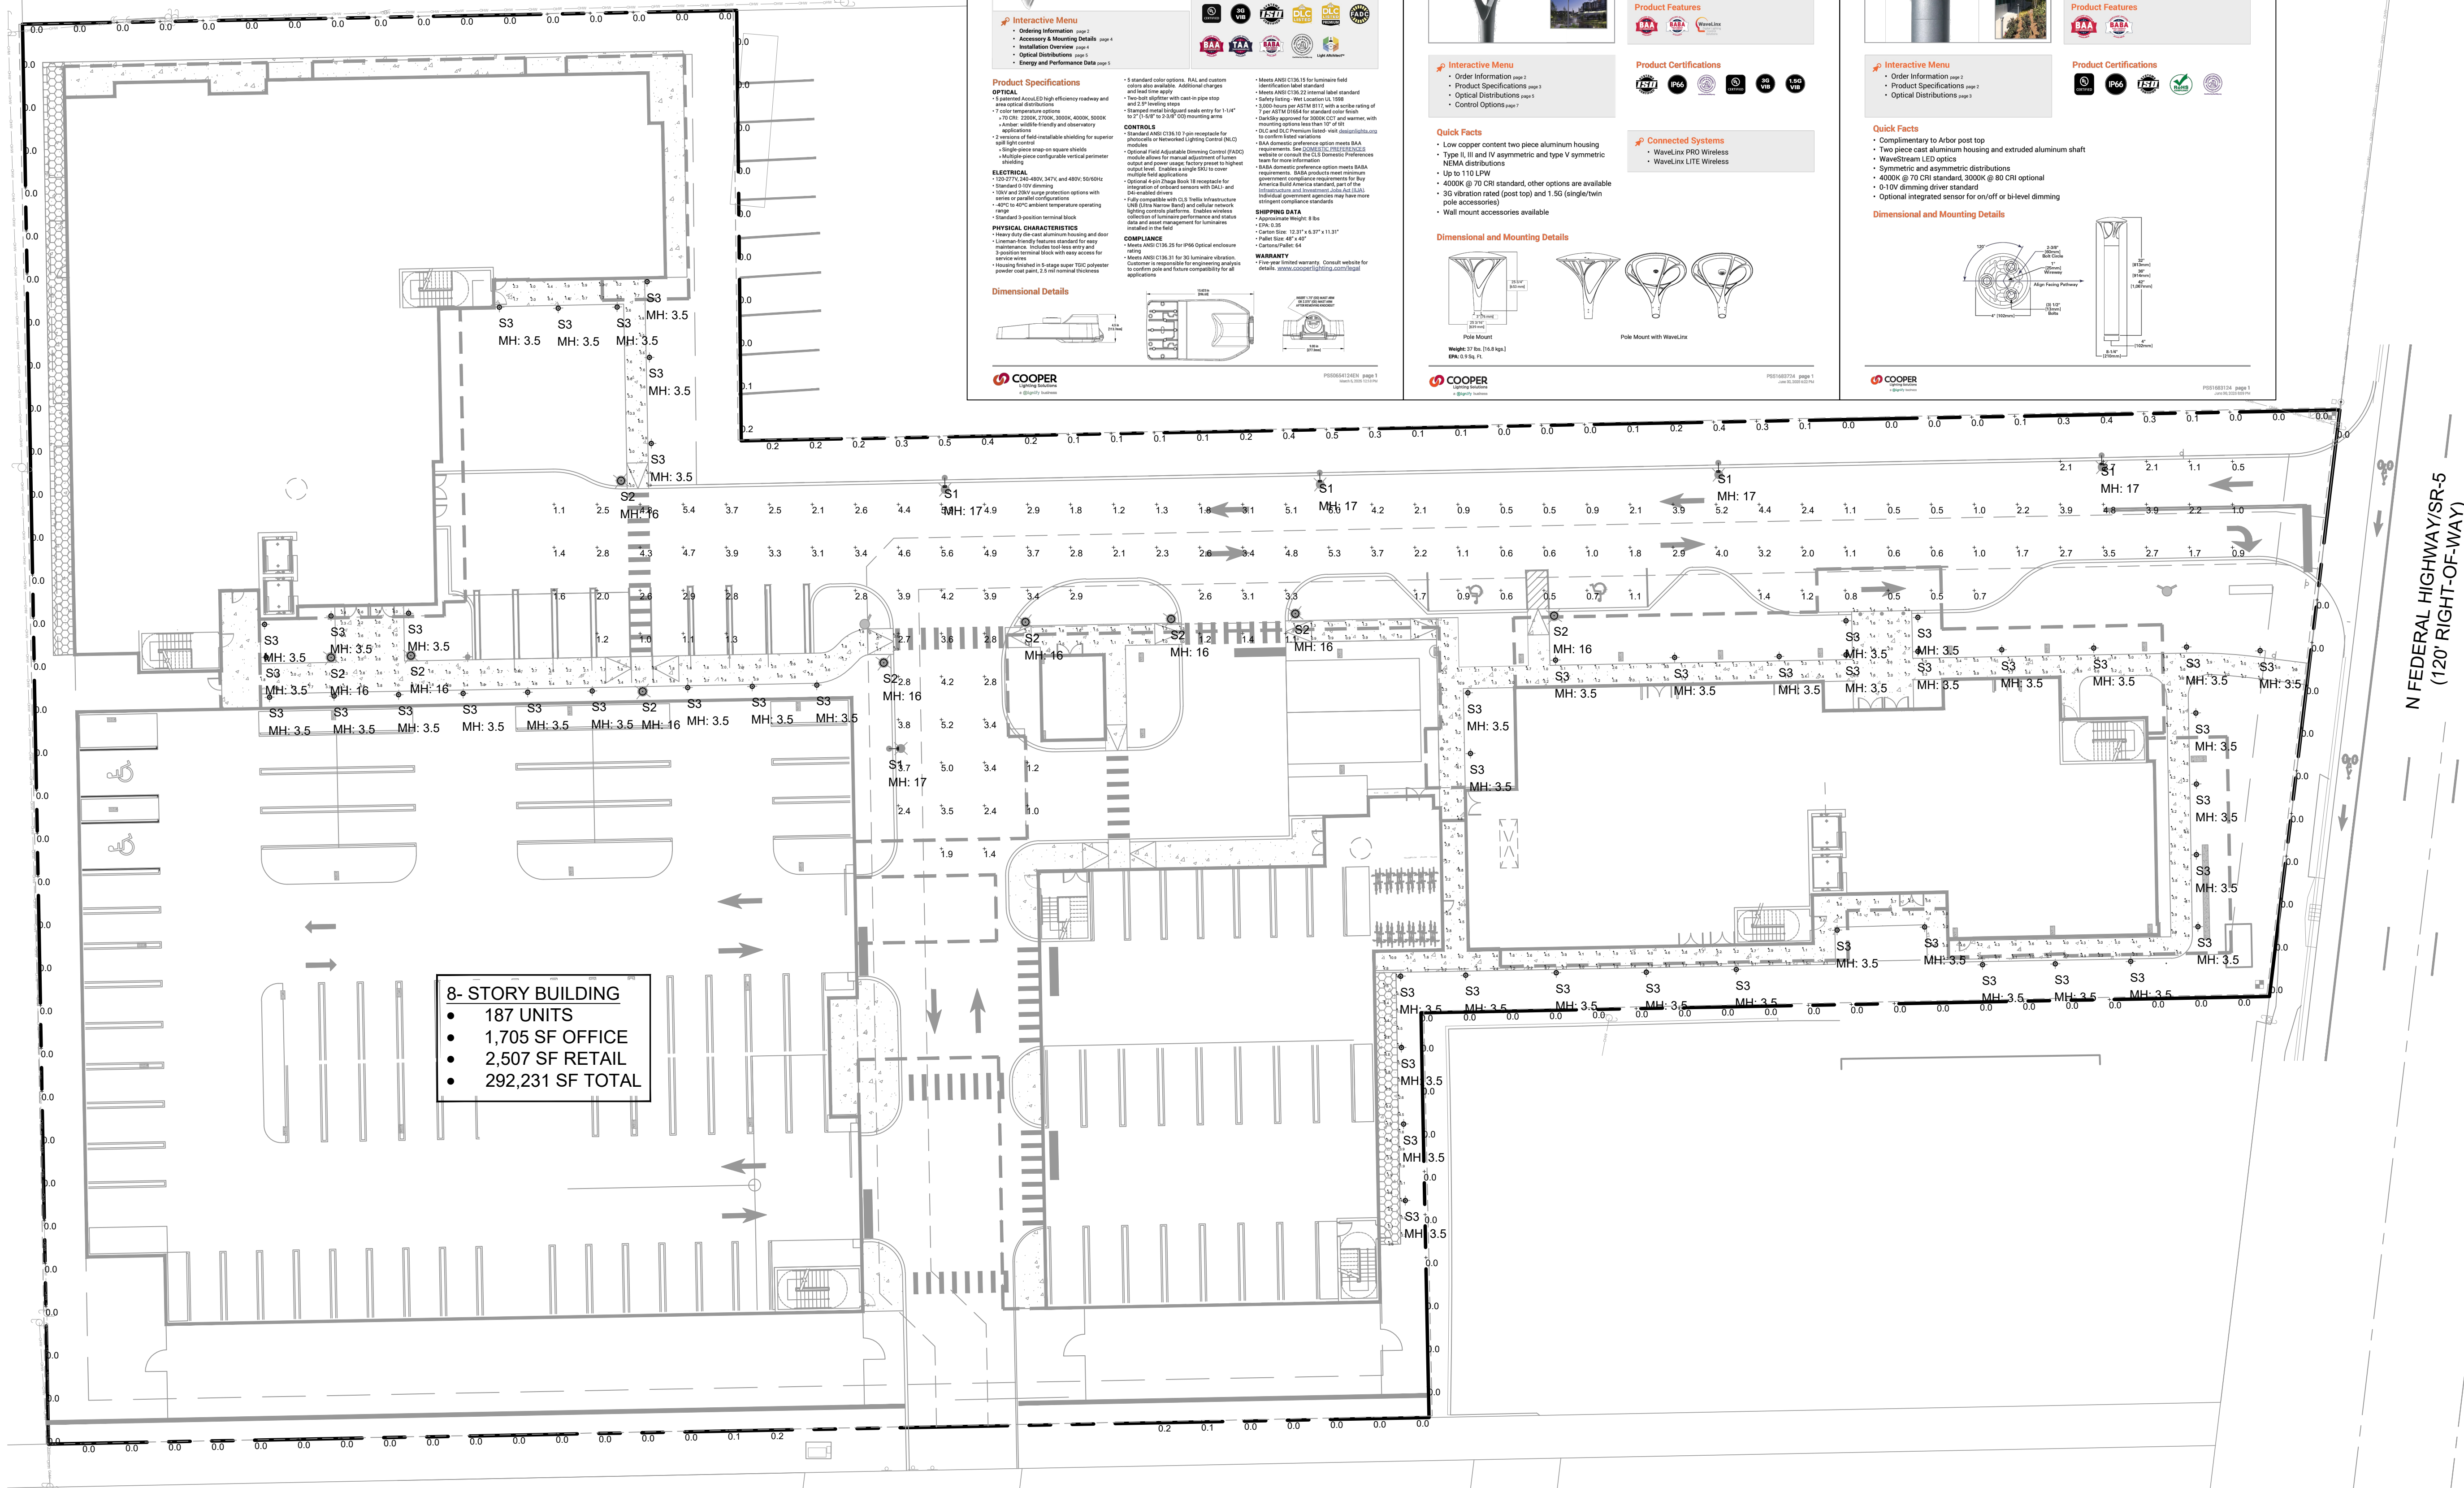STEPHEN M FECCIA, PLA
LA 6667289





Photometrics Luminaire Schedule								
Symbol	Qty	Label	Arrangement	Lum. Lumens	Arr. Lum. Lumens	LLF	Lum. Watts	Arr. Watts
	5	S1	Single	6893	6893	0.900	73.6	73.6
	9	S2	Single	2151	2151	0.900	24	24
	49	S3	Single	834	834	0.900	23	23

[illegible]

FOR QUESTIONS PERTAINING TO THIS FIXTURE SCHEDULE PLEASE CONTACT STEVE SANDERS @ LIGHTING DYNAMICS- (954) 295-9766



Know what's **below**.
Call before you dig.

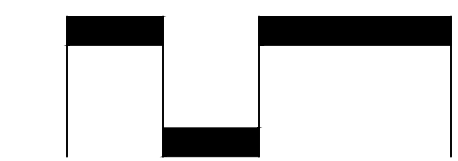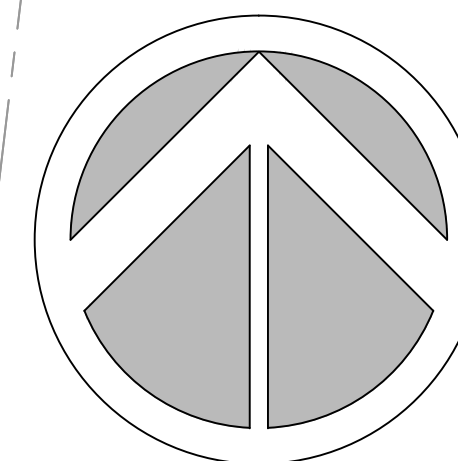

0 10 20 40
SCALE: 1" = 20'