




Exhibit "A"

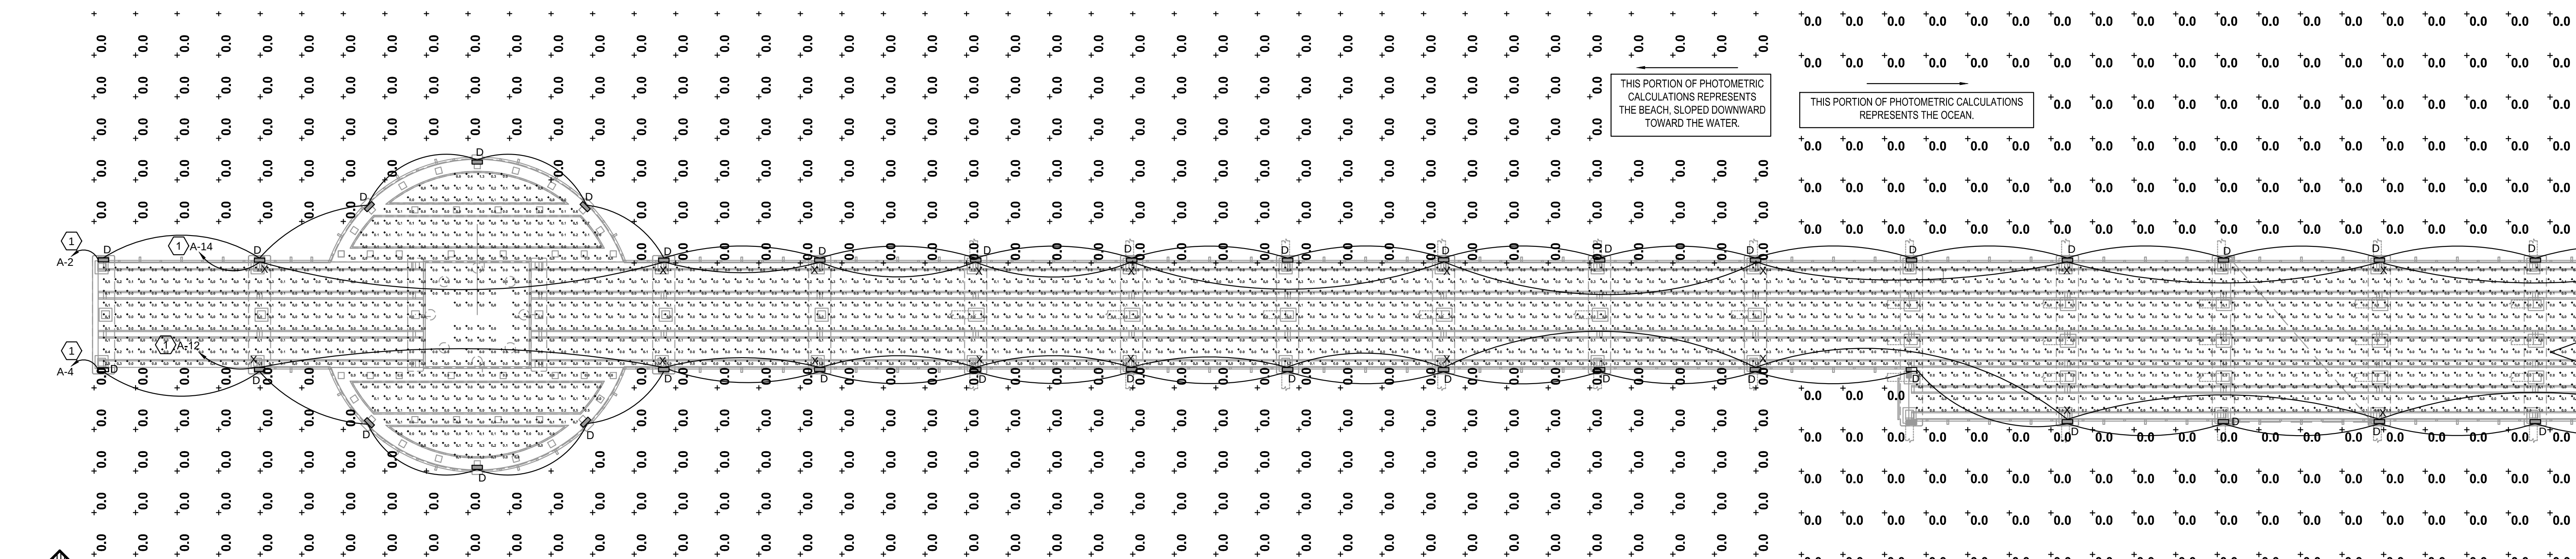

1 ELECTRICAL LIGHTING PLAN - PARTIAL PIER

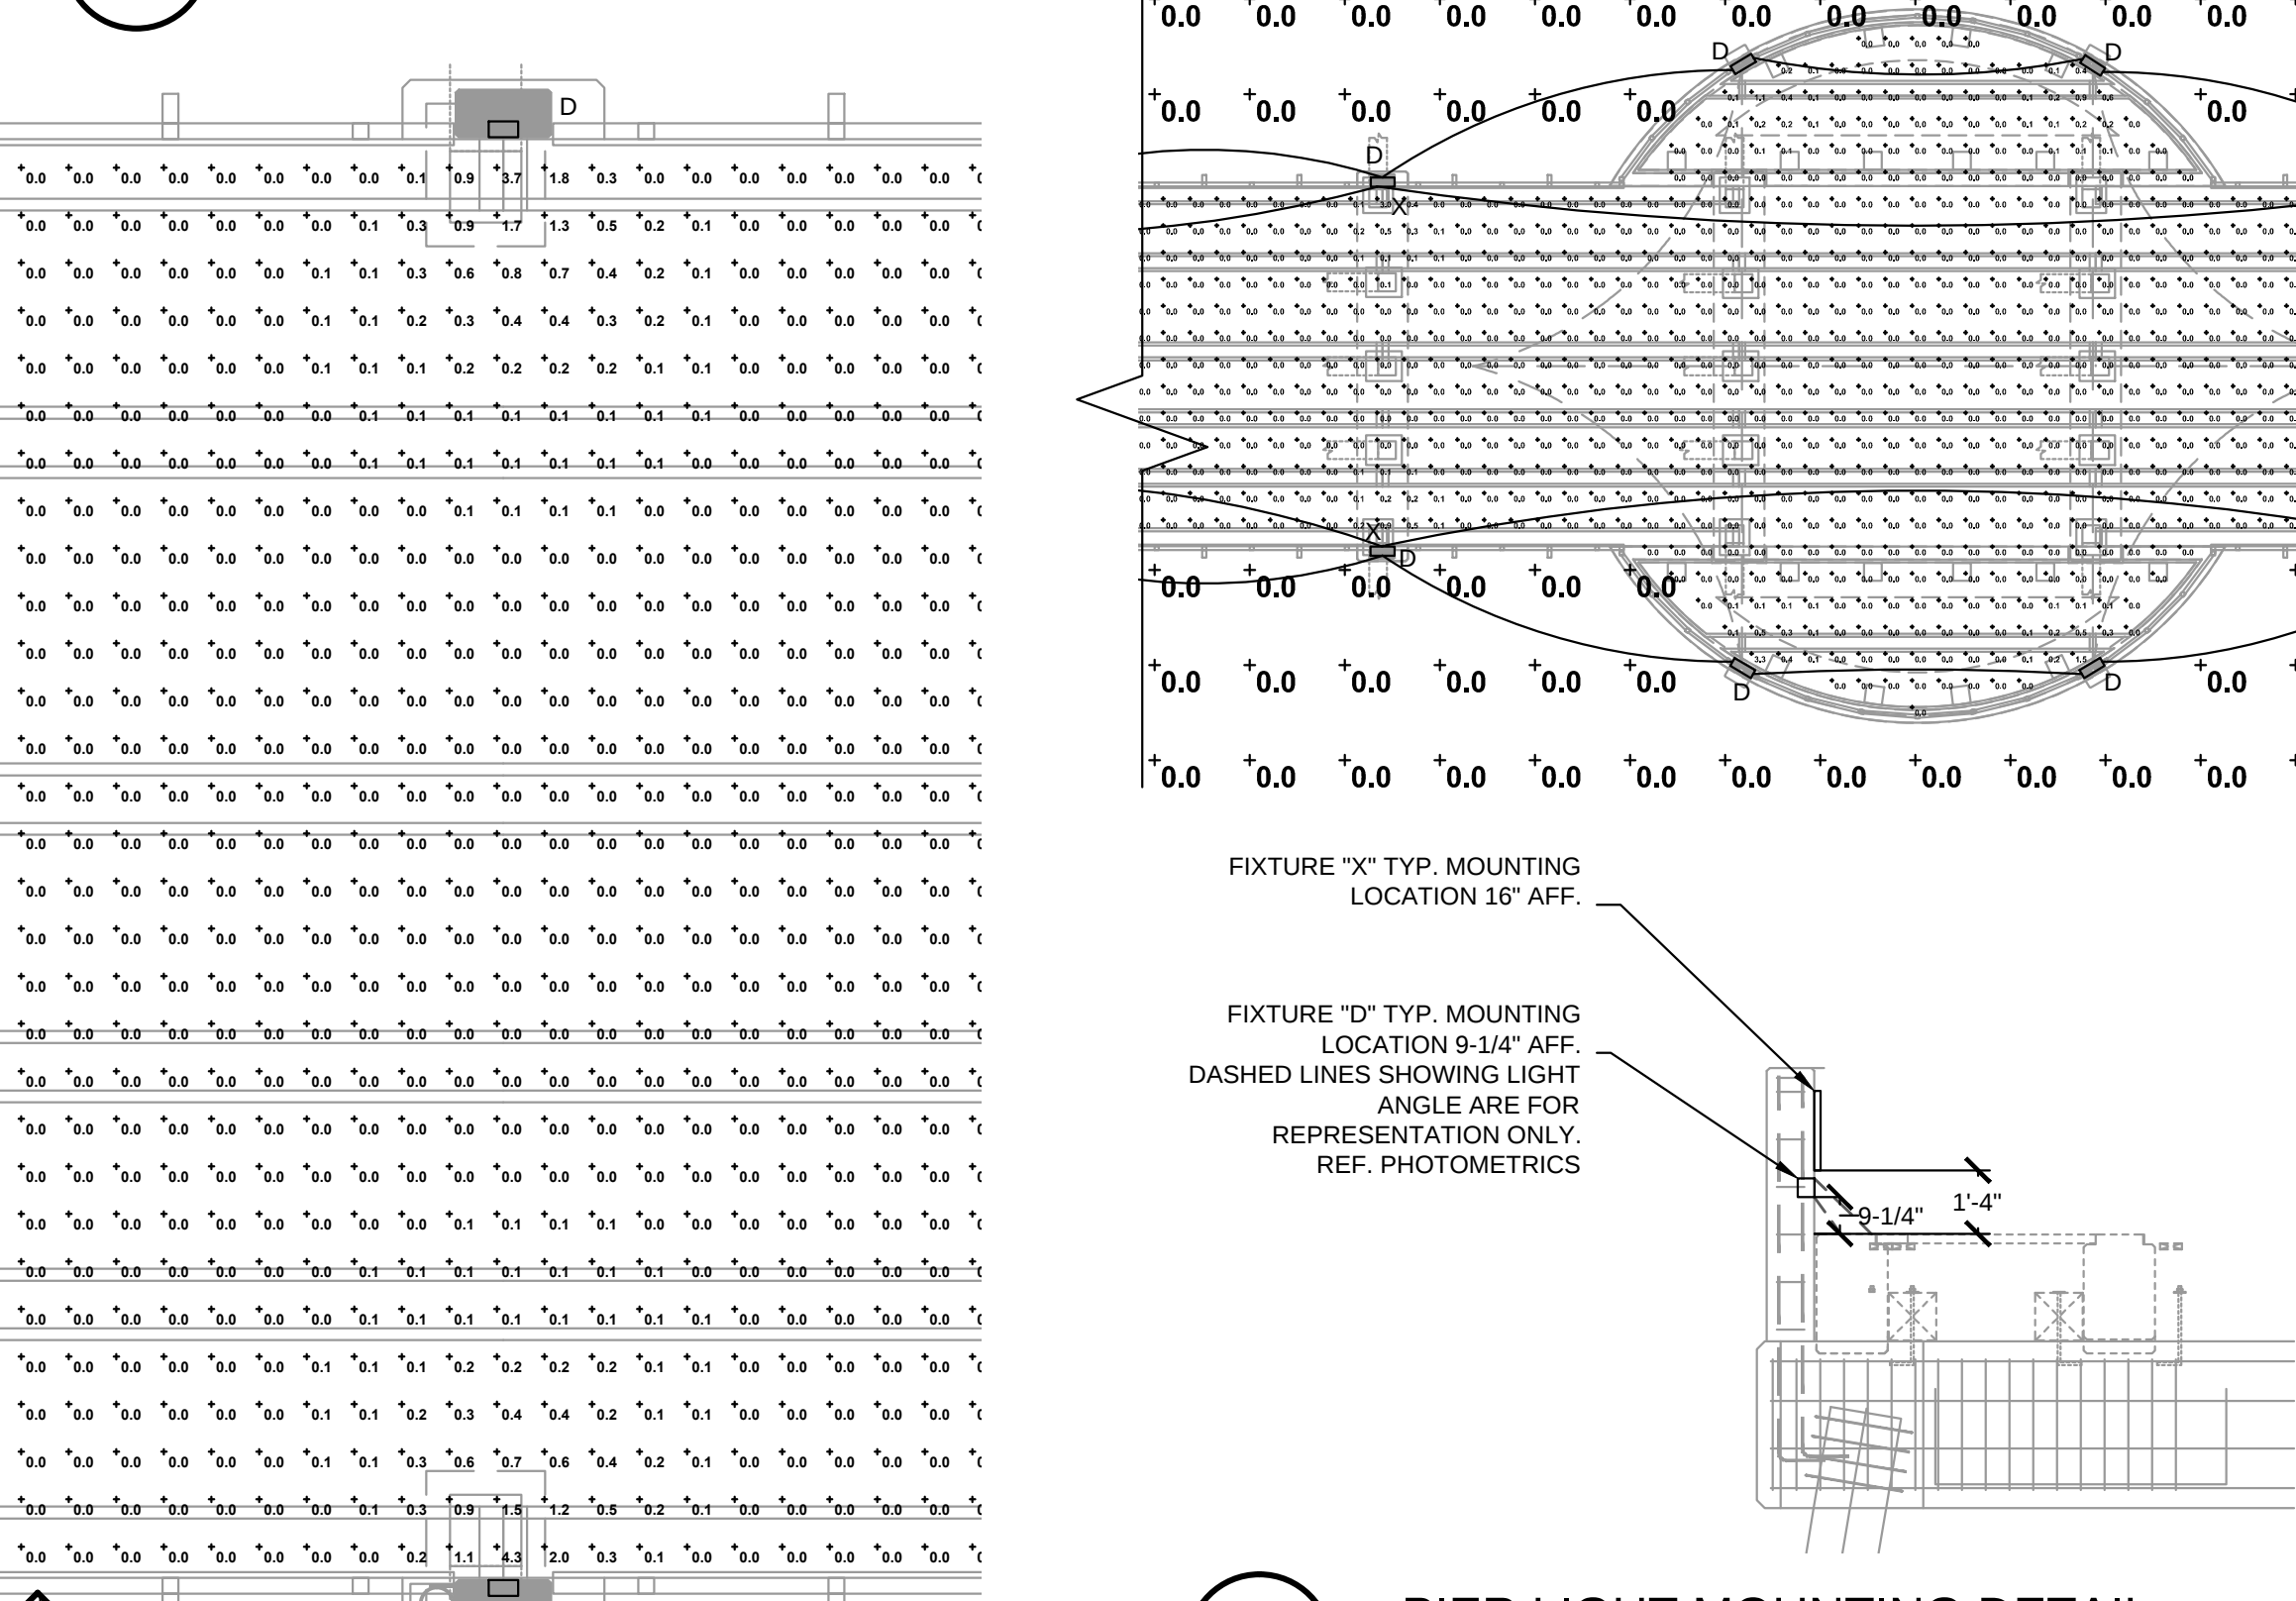

3 ENLARGED PIER LIGHTING
SCALE: 1/4" = 1'-0"

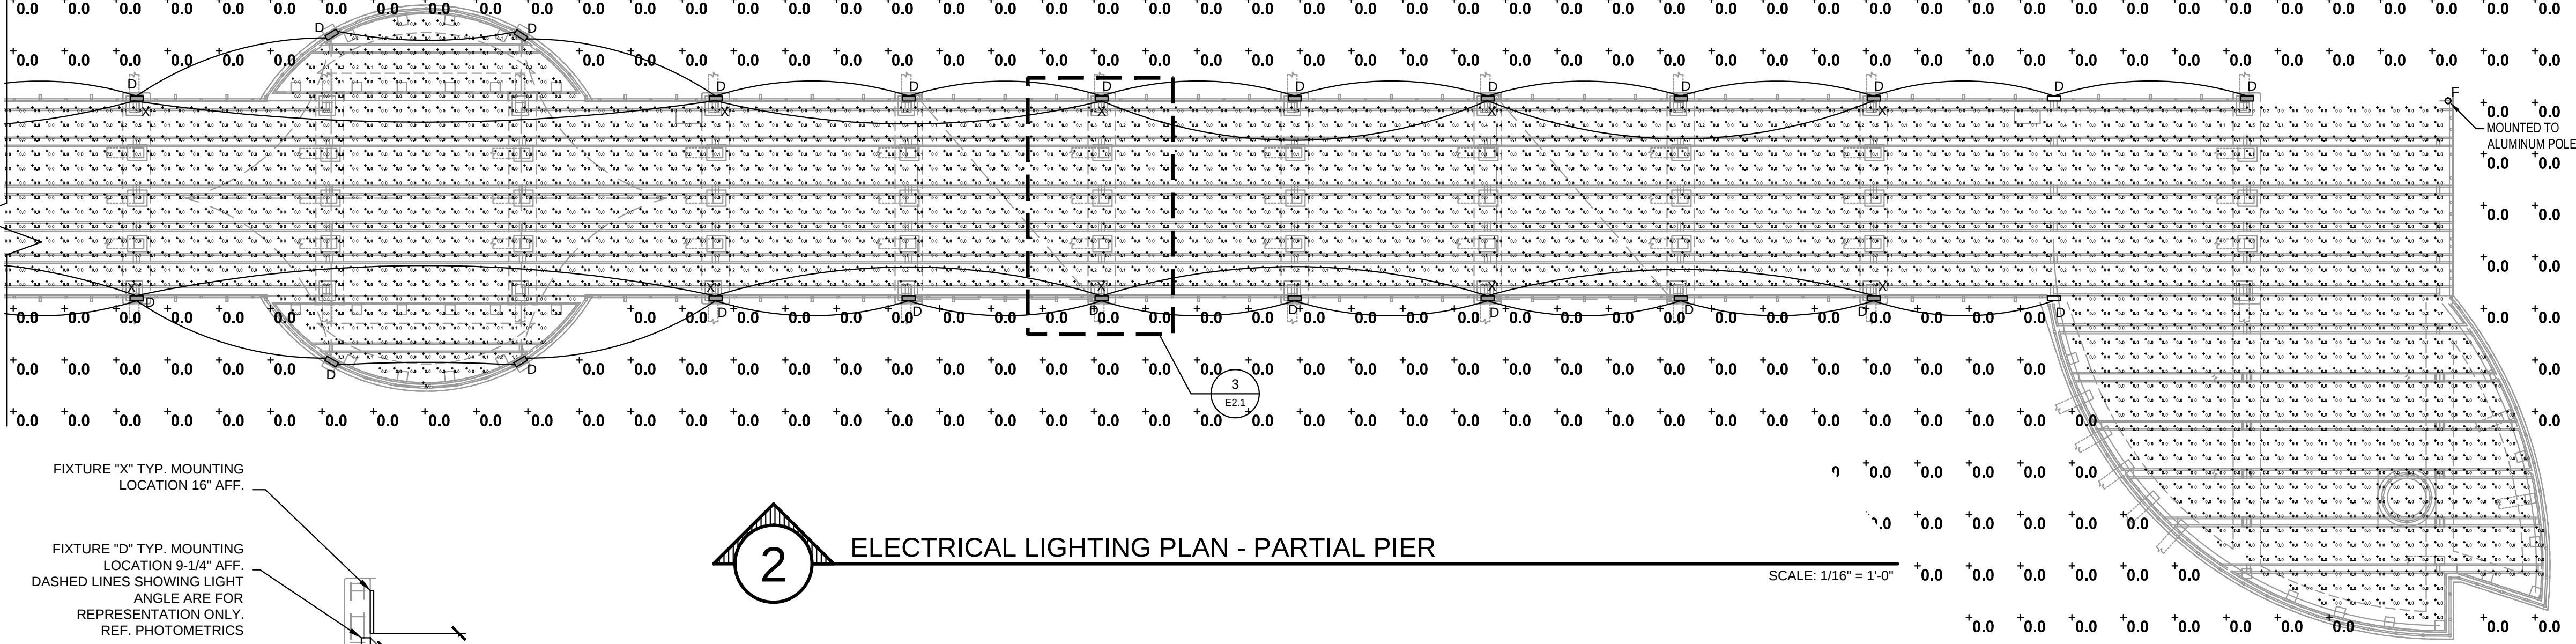

2 ELECTRICAL LIGHTING PLAN - PARTIAL PIER
SCALE: 1/16" = 1'-0"

4 PIER LIGHT MOUNTING DETAIL
SCALE: 1/4" = 1'-0"

- # **ELECTRICAL KEYNOTES**
- CIRCUIT SHALL BE CONTROLLED VIA PROGRAMMABLE TIME CLOCK. PROVIDE TIME CLOCK OVER RIDE SWITCHES AS SHOWN.
 - GENERAL NOTE: TIME CLOCK WILL BE SET SO LIGHTS WILL BE PERMANENTLY OFF FROM MARCH 1 TO OCTOBER 31.

POMPAÑO BEACH PIER OBSERVATORY						
LIGHTING FIXTURE SCHEDULE						
	Type	Manufacturer	Model#	Lamp	Voltage	Notes
D	RECESSED OUTDOOR LED STEPLIGHT WITH SHARP OUTSIDE LOUVERS & AMBER LED	COLE LIGHTING	L157W-HO-SCL-B-SS-AMB	3.6W INTEGRAL LED	120V	*** = SELECT FINISH AMBER LED; PHILIPS LUXEON REBEL TRUE AMBER
X	OUTDOOR USE AMBER LED LIGHT PANEL BACKLIGHTING 24" X 10" PAINTING	G-TRAN LED	SC2415-0WET-A-BW-48"	20W/ 48"	24V	*** = SELECT FINISH INSTALLED BEHIND ARTWORK; NOTE 6.
F	US COAST GUARD NAVIGATIONAL LIGHT	SABIK	M680W		3.7V	US COAST GUARD NAVIGATIONAL LIGHT - FLUSH WHITE LITHON BATTERY
NOTES:						
1) INTEGRAL DRIVER						
2) NOTE NOT USED						
3) INCLUDE ALL ELECTRICAL AND MOUNTING ACCESSORIES, CONNECTORS, ETC.						
4) COORDINATE ALL LIGHTING WITH POWER & LIGHTING SYSTEMS, INC.						
5) PROVIDE ALL LIGHTING FIXTURES AS SPECIFIED; SUBSTITUTIONS WILL NOT BE ACCEPTED WITHOUT PRIOR APPROVAL FROM THE OWNER AND ARCHITECT						
6) AMBER LED STRIP - WAVELENGTH = 597 - 26 TOTAL FIXTURES						

RGD
CONSULTING ENGINEERS
STRUCTURAL | MECHANICAL | ELECTRICAL | PLUMBING | FIRE PROTECTION
www.rgdengineers.com
MADE IN THE USA
2151 S. ALT A1A, SUITE 2000, JUPITER, FL 33477 (561) 743-0165
CERTIFICATE OF AUTHORIZATION: 5454
This item has been electronically signed and sealed by Davis A. Fitzgerald, PE
using a Digital Signature and date. Printed copies of this document are not
considered signed and sealed and the signature must be verified on any electronic
copies.

VERIFY SCALE
1" = 1'
BAR IS ONE INCH ON
ORIGINAL DRAWINGS.
ADJUST SCALES
AS NECESSARY.

NO.	REVISION	DATE	BY
1	ALTERNATE LIGHT FIXTURE	05/08/17	RDM
2	ALTERNATE LIGHT FIXTURE	08/20/17	RDM
3	ADDED RECEPTACLES	11/09/17	AL
5	ARTISTIC FIXTURE	07/06/18	AL
6	ARTISTIC REMOVAL	04/05/18	DF
8	ARTISTIC FIXTURE	07/23/19	DF
9	LIGHTING	01/09/20	DF

BRIDGE DESIGN ASSOCIATES, INC.
1402 Royal Palm Beach Blvd., Suite 200, Royal Palm Beach, FL 33411
Tel. (561) 886-3660 Fax (561) 791-1995
COAST GUARD ENGINEERS
FLORIDA E.C. NO. 4952

Proposed Concrete and Wood Pier for:
Pompano Pier
Pompano Beach, Florida

DRAWN
RGD
CHECKED
RGD
DATE
01/10/17
SCALE
AS NOTED

ELECTRICAL LIGHTING
PLAN

SHEET
E2.1
PROJECT NO.
13-599