



ISSUE FOR:

DRC SUBMITTAL

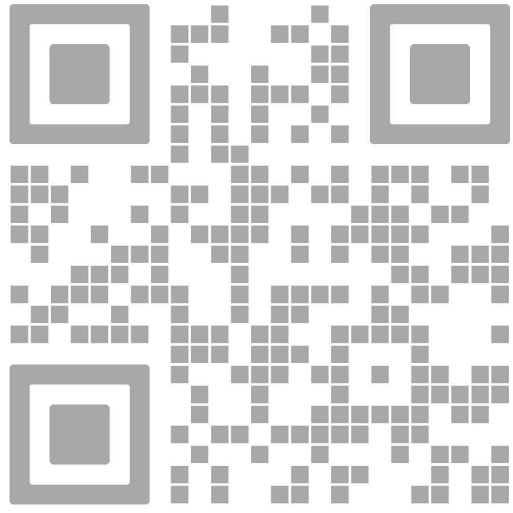

REV.	DATE	DESCRIPTION
01	01-29-2025	D.R.C. SUBMITTAL

ALL MEASUREMENTS MUST BE VERIFIED BEFORE BEGINNING THE WORKS. NO MEASUREMENTS ARE TO BE SCALED DIRECTLY FROM THIS DRAWING.

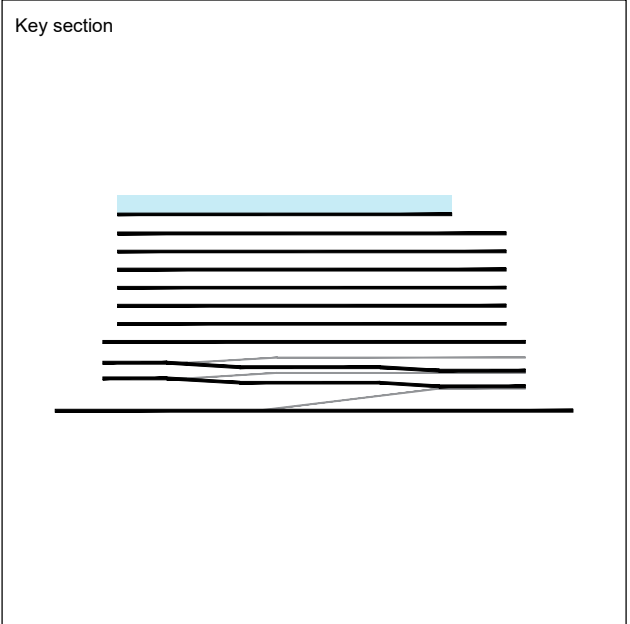

Client

**VERA FUND**  
NICK POLYUSHKIN  
& YURI KHARITONENKOV  
TEL: 305.833.3303

Project


**1600 S FEDERAL HIGHWAY  
(MIXED-USE PROJECT)**

1600 SOUTH FEDERAL HIGHWAY,  
POMPAÑO BEACH, FL 33062

Title	
LEVEL 02 PHOTOMETRICS	
Drawn <b>J. WU</b>	Field <b>ARCHITECTURE</b>
Verified <b>N. TREMBLAY</b>	Scale <b>as shown</b>
Approved <b>S. L'ECUYER</b>	Date <b>03-12-2025</b>
Project Manager <b>J. WU</b>	Dwg. no. <b>P-003</b>
Project <b>24-838</b>	

Calculation Summary							
Label	CalcType	Units	Avg	Max	Min	Avg/Min	Max/Min
Parking Garage Floor	Illuminance	FC	5.41	9.8	1.9	5.41	9.80


Luminaire Schedule							
Symbol	Qty	Label	Arrangement	Description	LF	Luminaire Lumens	Total Watts
⊙	17	01	Single	Utopia Lighting LRC-30-SLED-408-00V-WB	1,900	4810	37
⊙	18	01K	Single	Utopia Lighting LRC-30-SLED-408-00V-WB (connected to generator)	2,900	4810	37
							666

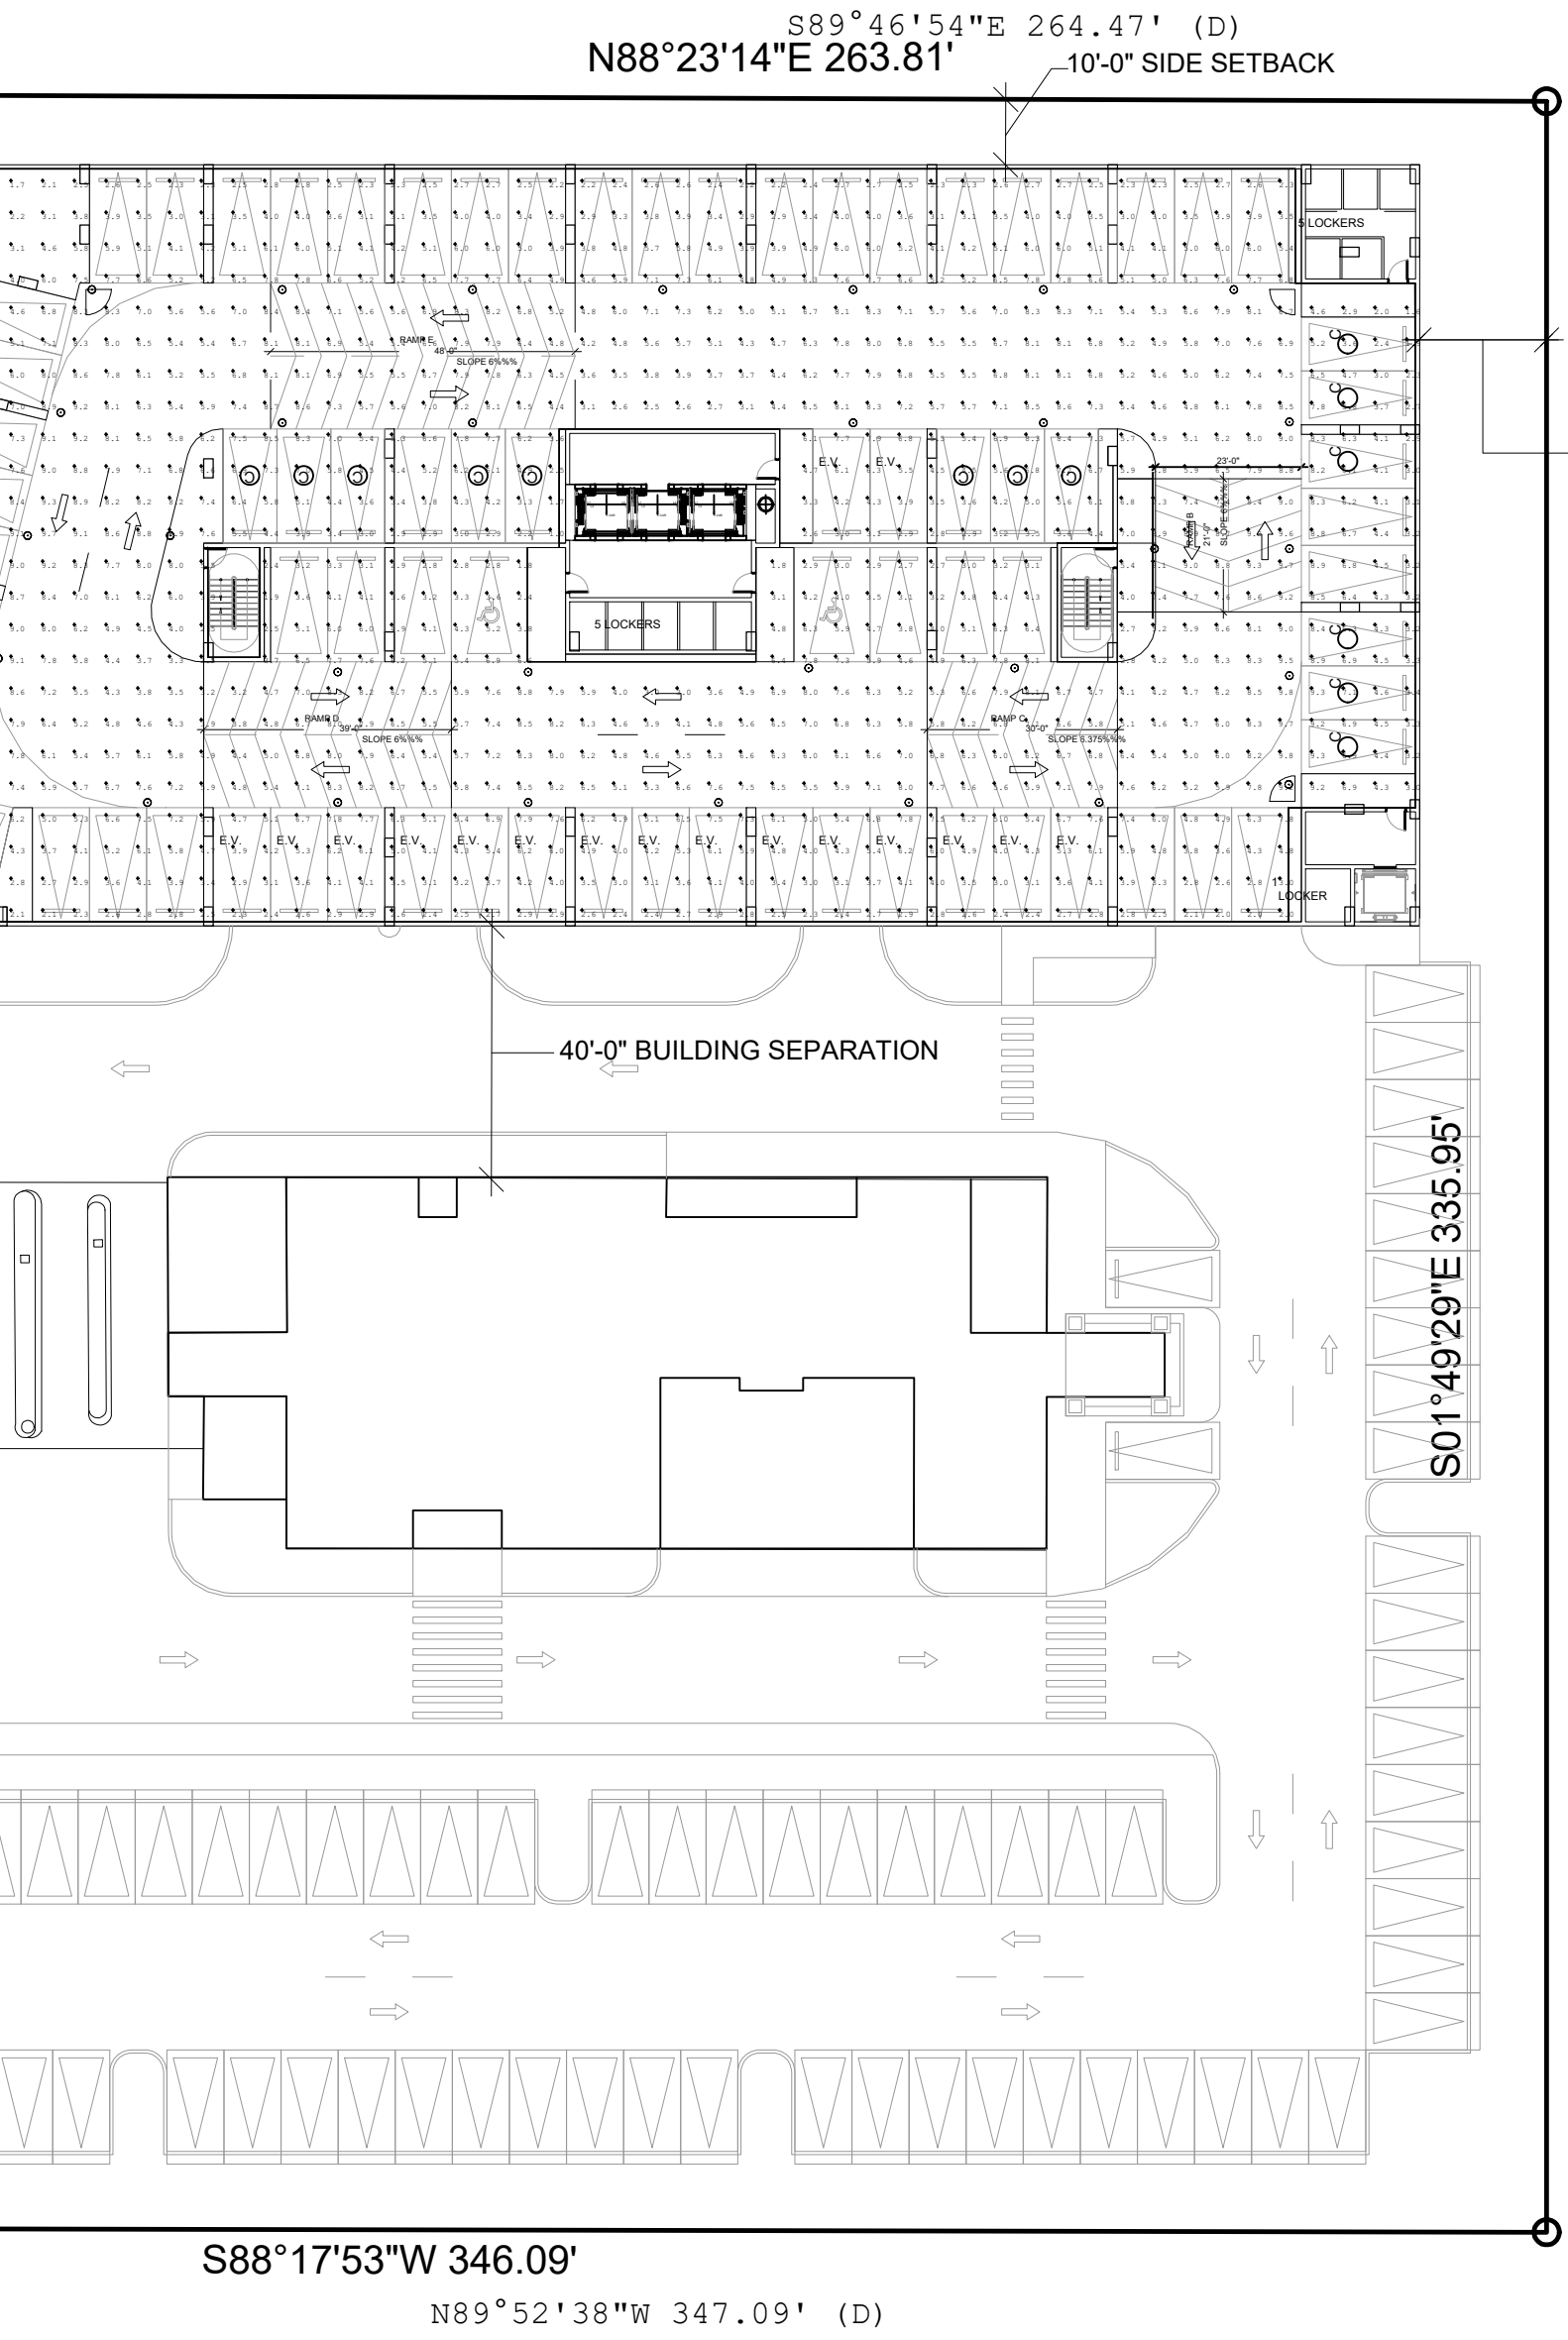

LEVEL 02  
PHOTOMETRICS - NORMAL  
SCALE: 1"= 30'-0"

Calculation Summary							
Label	CalcType	Units	Avg	Max	Min	Avg/Min	Max/Min
Parking Garage Floor	Illuminance	FC	2.95	9.1	0.3	9.83	27.00

Luminaire Schedule							
Symbol	Qty	Label	Arrangement	Description	LF	Luminaire Lumens	Total Watts
⊙	17	01	Single	Utopia Lighting LRC-30-SLED-408-00V-WB	1,900	4810	37
⊙	18	01K	Single	Utopia Lighting LRC-30-SLED-408-00V-WB (connected to generator)	2,900	4810	37
							666

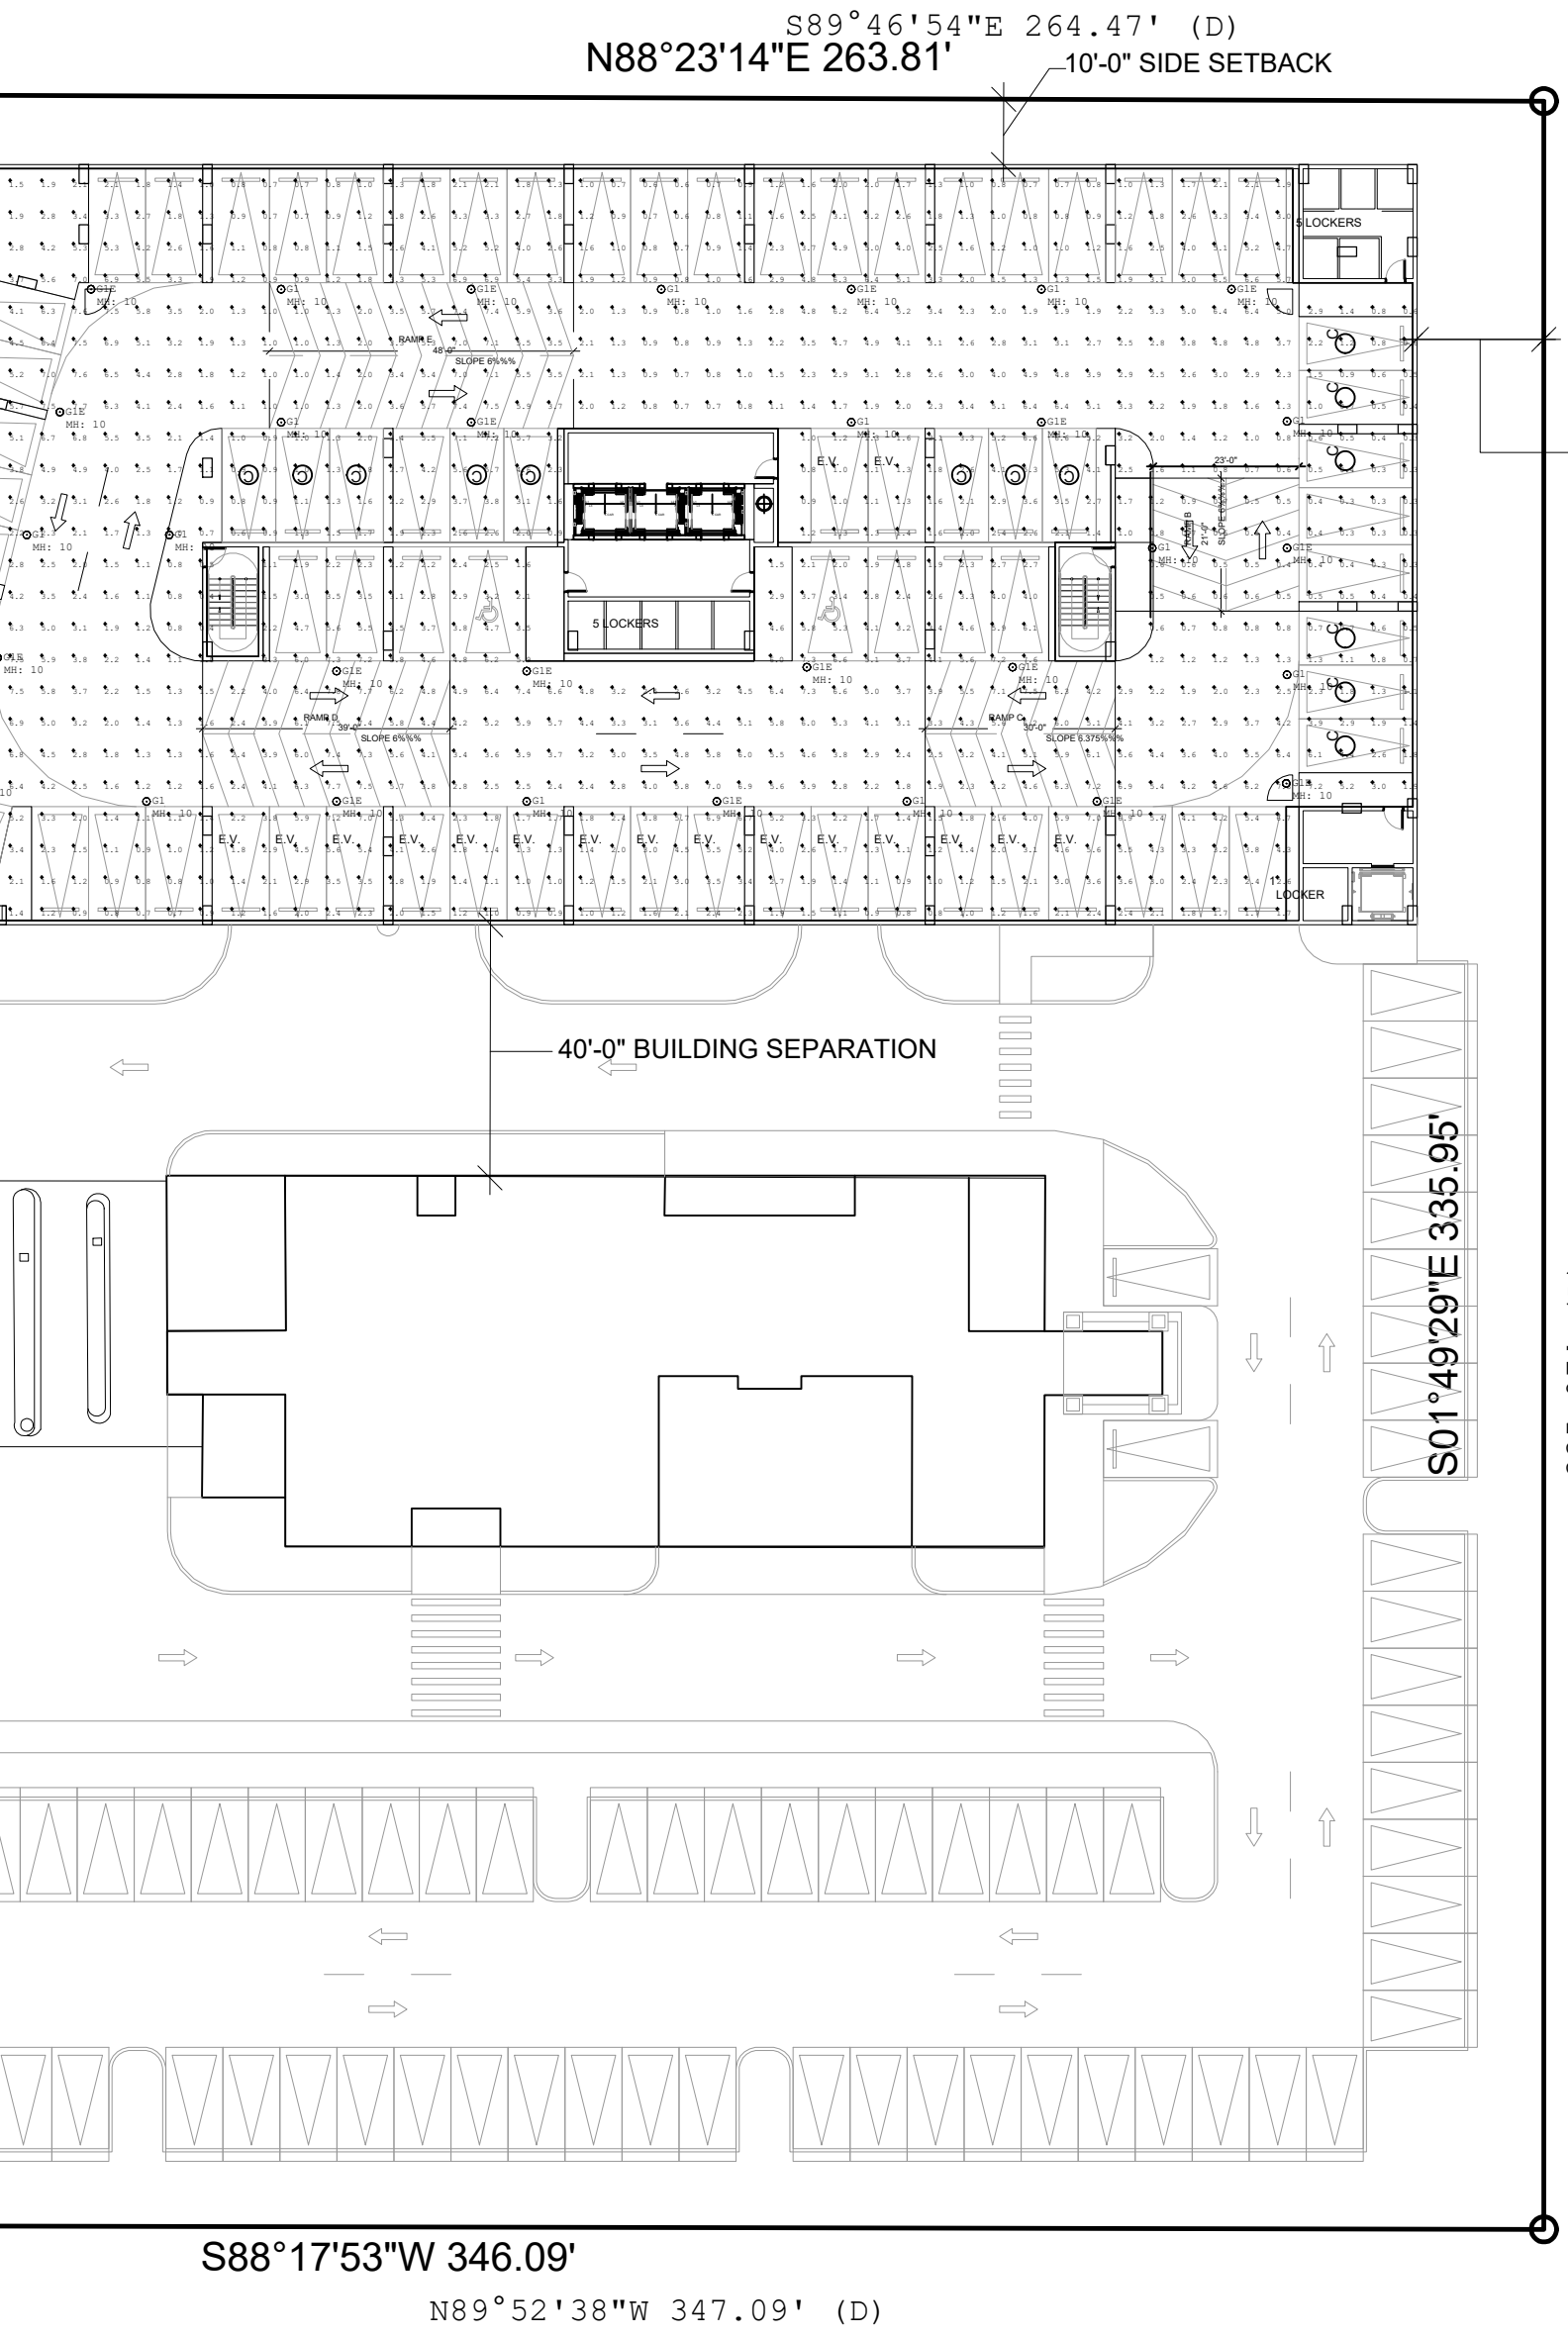

LEVEL 02  
PHOTOMETRICS - EMERGENCY  
SCALE: 1"= 30'-0"