

REV.	DATE	DESCRIPTION
01	05-13-2025	DRC SUBMITTAL

ALL MEASUREMENTS MUST BE VERIFIED BEFORE BEGINNING THE WORKS. NO MEASUREMENTS ARE TO BE SCALED DIRECTLY FROM THIS DRAWING.



Key section

Client
VERA FUND
NICK POLYUSHKIN
& YURI KHARITONENKOV
TEL: 305.833.3303


Project
**1600 S FEDERAL HIGHWAY
(MIXED-USE PROJECT)**
1600 SOUTH FEDERAL HIGHWAY,
POMPANO BEACH, FL 33062

Title LEVEL 1.5 PHOTOMETRICS	
Drawn J. WU	Field ARCHITECTURE
Verified N. TREMBLAY	Scale as shown
Approved S. L'ECUYER	Date 08-15-2025
Project Manager J. WU	Dwg. no. P-002
Project 24-838	



Calculation Summary							
Label	CalcType	Units	Avg	Max	Min	Avg/Min	Max/Min
Parking Garage Floor	Illuminance	FC	12.24	21.1	1.2	17.8	17.58
Luminaire Schedule							
Symbol	Qty	Label	Arrangement	Description	LMF	Luminaire Lumens	Luminaire Watts
○	18	01E	Single	Utopia Lighting LRC-36-SLEP-40K-18W-WS (connected to	0.900	4810	37
○	18	01E	Single	Utopia Lighting LRC-36-SLEP-40K-18W-WS (connected to	0.900	4810	37
○	11	01	Single	Utopia Lighting LRC-36-SLEP-40K-18W-WS	0.900	4810	37

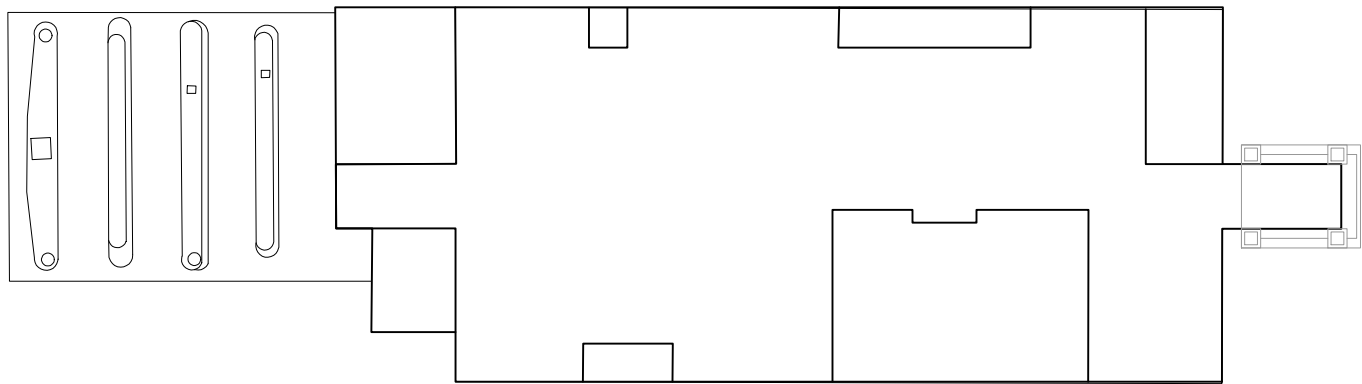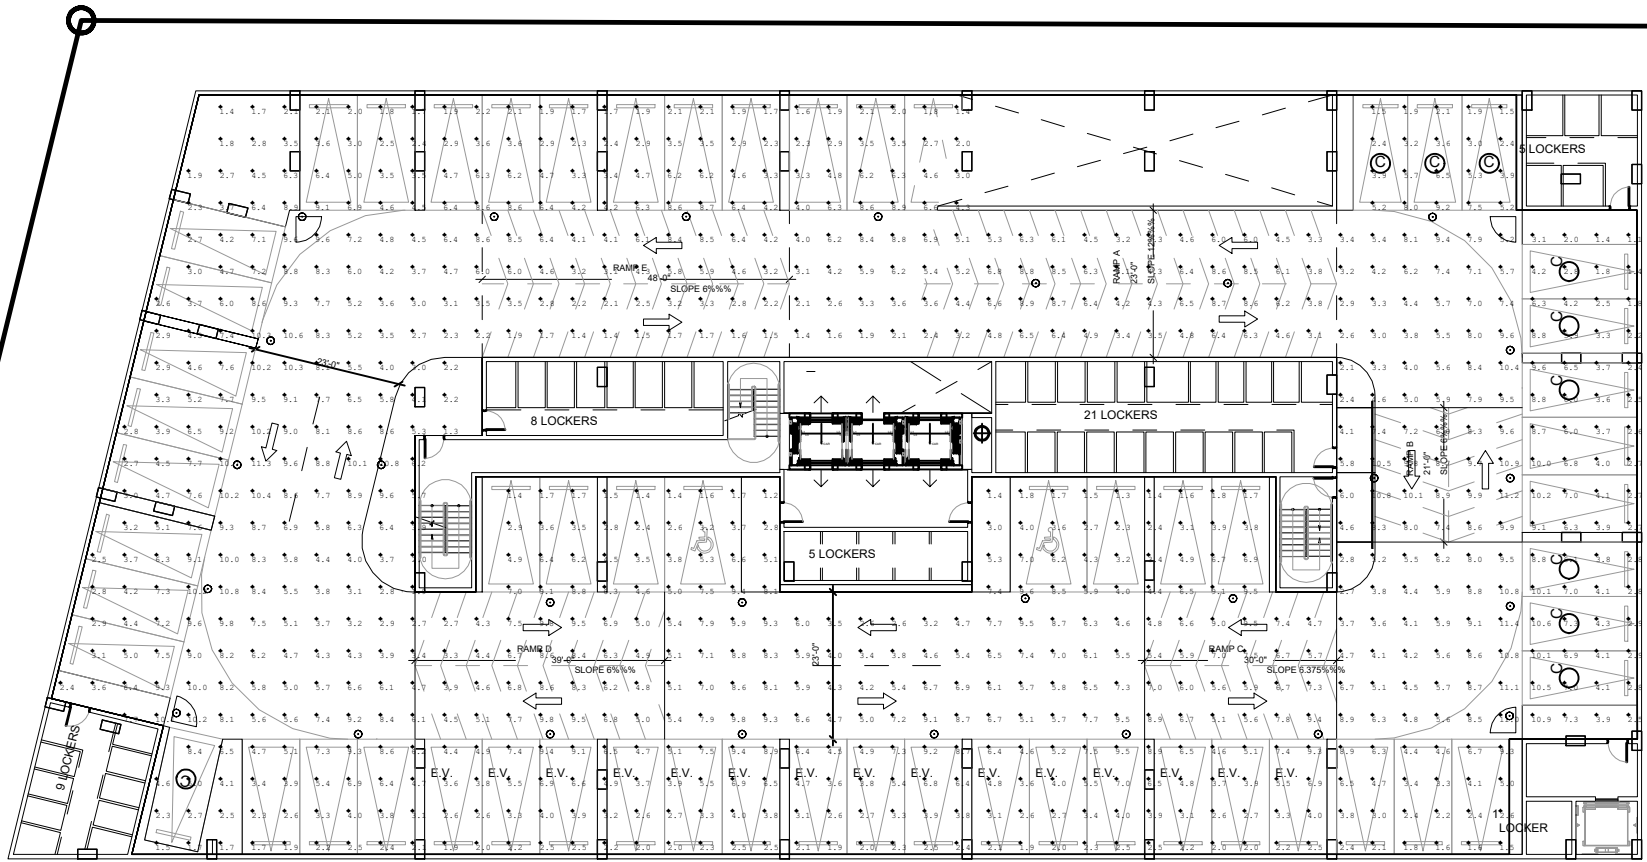

LEVEL 1.5
PHOTOMETRICS - NORMAL
SCALE: 1"= 30'-0"

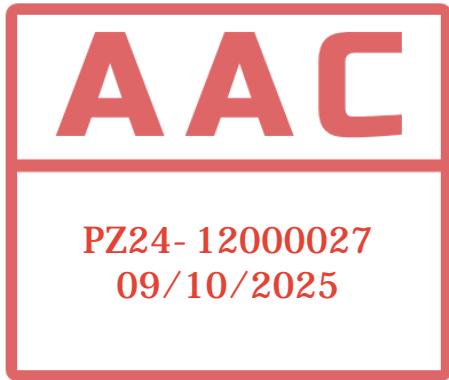

Calculation Summary							
Label	CalcType	Units	Avg	Max	Min	Avg/Min	Max/Min
Parking Garage Floor	Illuminance	FC	12.24	21.1	1.2	17.8	17.58
Luminaire Schedule							
Symbol	Qty	Label	Arrangement	Description	LMF	Luminaire Lumens	Luminaire Watts
○	18	01E	Single	Utopia Lighting LRC-36-SLEP-40K-18W-WS (connected to	0.900	4810	37
○	18	01E	Single	Utopia Lighting LRC-36-SLEP-40K-18W-WS (connected to	0.900	4810	37
○	11	01	Single	Utopia Lighting LRC-36-SLEP-40K-18W-WS	0.900	4810	37

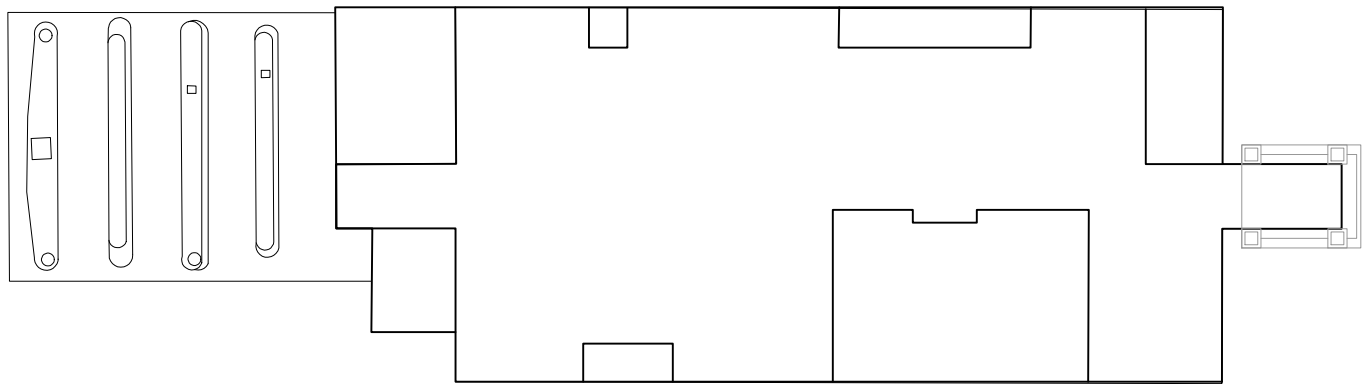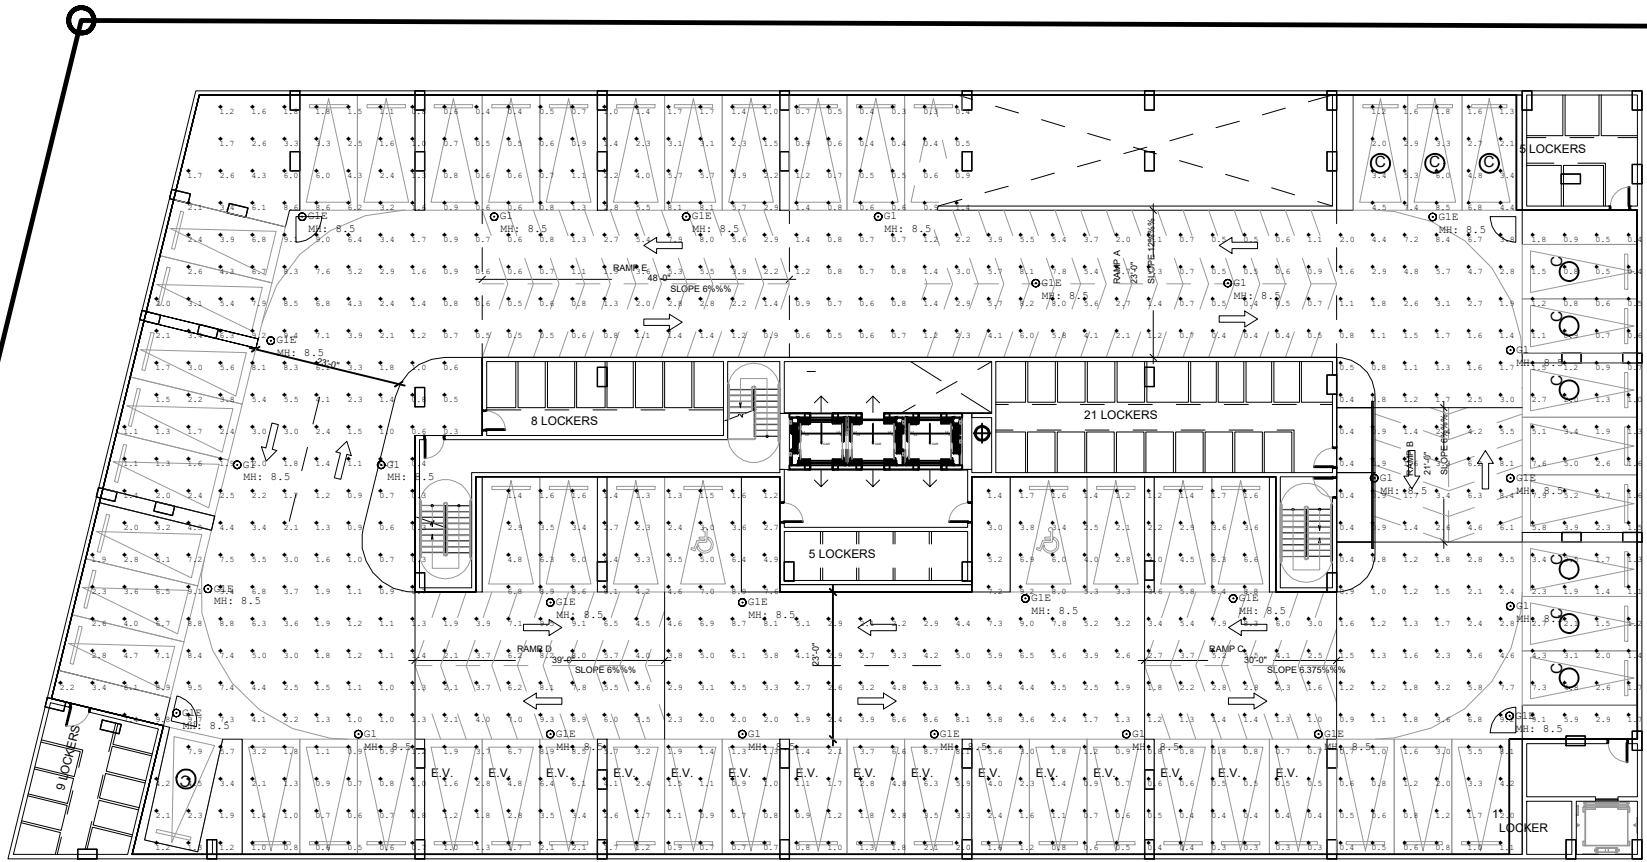

LEVEL 1.5
PHOTOMETRICS - EMERGENCY
SCALE: 1"= 30'-0"