

COPYRIGHT 2021 GALLO HERBERT ARCHITECTS  
IT IS A VIOLATION OF THE LAW FOR ANY PERSON, UNLESS ACTING UNDER THE DIRECTION OF A LICENSED ARCHITECT TO ALTER THESE PLANS AND SPECIFICATIONS. THIS DOCUMENT CONTAINS PROPERTY INFORMATION AND SHALL NOT BE USED OR REPRODUCED OR ITS CONTENTS DISCLOSED IN WHOLE OR IN PART, WITHOUT THE PRIOR WRITTEN CONSENT OF GALLO HERBERT ARCHITECTS.  
CONTRACTORS SHALL VERIFY EXISTING CONDITIONS AND CORRELATE DIMENSIONS PRIOR TO PROVIDING THE WORK DETAILED IN THESE DRAWINGS, AND SHALL PROMPTLY NOTIFY THE DESIGNER OF ANY DISCREPANCIES.



POLE MOUNTED LIGHT FIXTURE SILVER COLOR  
(NOT SHOWN HERE) CONCRETE POLES



WALL MOUNTED LIGHT FIXTURE  
SILVER COLOR. (NOT SHOWN HERE)

Luminaire Schedule							
Symbol	Qty	Label	Arrangement	LMF	Lum. Lumens	Lum. Watts	Part Number
	4	3M-22L	SINGLE	1.000	22100	132	OSQL-B-22L-40K7-3M-UL-NM-__ w/OSQ-ML-B-AA-__
	46	4M-22L	SINGLE	1.000	22100	132	OSQL-B-22L-40K7-4M-UL-NM-__ w/OSQ-ML-B-AA-__
	1	4M-22L-2	2 @ 180°	1.000	22100	132	OSQL-B-22L-40K7-4M-UL-NM-__ w/OSQ-ML-B-AA-__

Calculation Summary (Footcandles calculated using initial lumen values @ 25°C)						
Label	Units	Avg	Max	Min	Avg/Min	Max/Min
CalcPts	Fc	2.13	19.9	0.0	N.A.	N.A.
PROPERTY LINE	Fc	0.58	2.8	0.0	N.A.	N.A.
AIR SIDE	Fc	4.57	18.6	0.5	9.14	37.20
DUMPSTER ENCLOSURE	Fc	4.25	4.9	3.6	1.18	1.36
NORTH PARKING LOT	Fc	3.96	10.1	1.0	3.96	10.10
SOUTH PARKING LOT	Fc	3.31	10.0	1.0	3.31	10.00
TIE DOWN	Fc	1.10	7.8	0.0	N.A.	N.A.


Poles to be provided by others.

Additional Equipment:  
(52) OSQ-ML-B-AA\_\_ (Adjustable Arm Mount)  
(49) WM-4M\_\_ (Wall Mount Elbow)

\*\*\* CUSTOMER TO VERIFY ORDERING INFORMATION AND CATALOGUE NUMBER PRIOR TO PLACING ORDER \*\*\*

## LIGHTING WALL MOUNT DETAIL


SCALE: 1/4" = 1'-0"

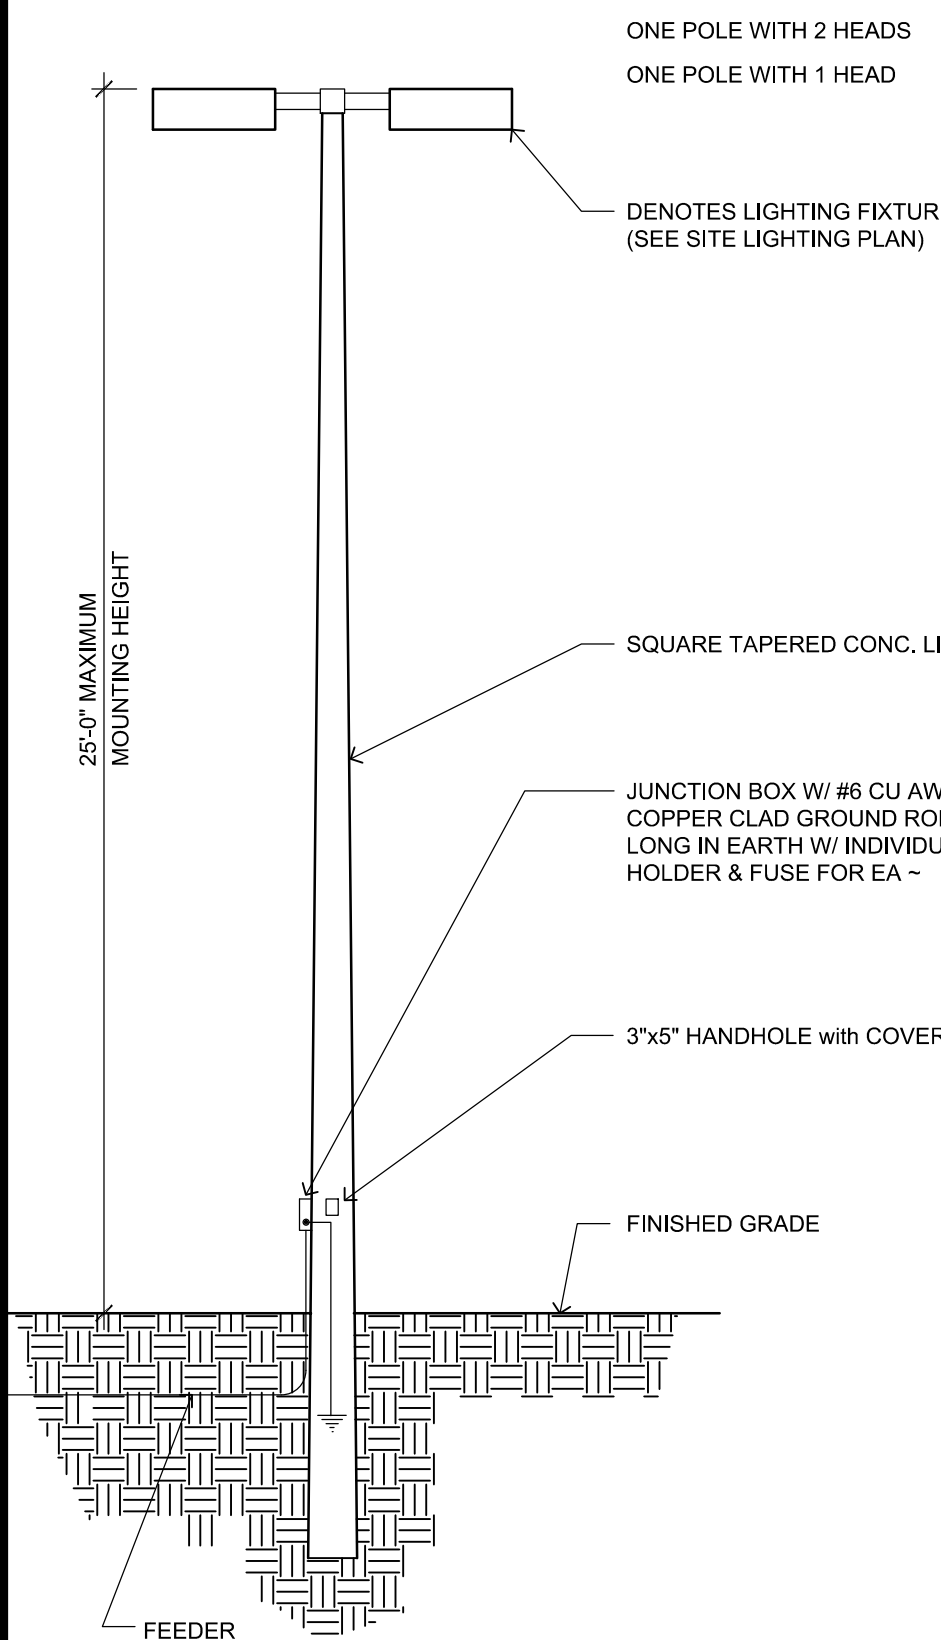


## LIGHTING STANDARD DETAIL

SCALE: 1/4" = 1'-0"

SUPPLIER OF POLES SHALL SUBMIT ENGINEERED SHOP DRAWINGS SIGNED & SEALED BY A REGISTERED PROFESSIONAL ENGINEER SIZED FOR THE EFFECTIVE PROJECTED AREA (EPA) OF THE LIGHT FIXTURES ULTIMATELY INSTALLED AND SHALL DETERMINE THE REQUIRED POLE EMBEDMENT DEPTH FOR THE CODE REQUIRED WIND VELOCITY PRESSURE

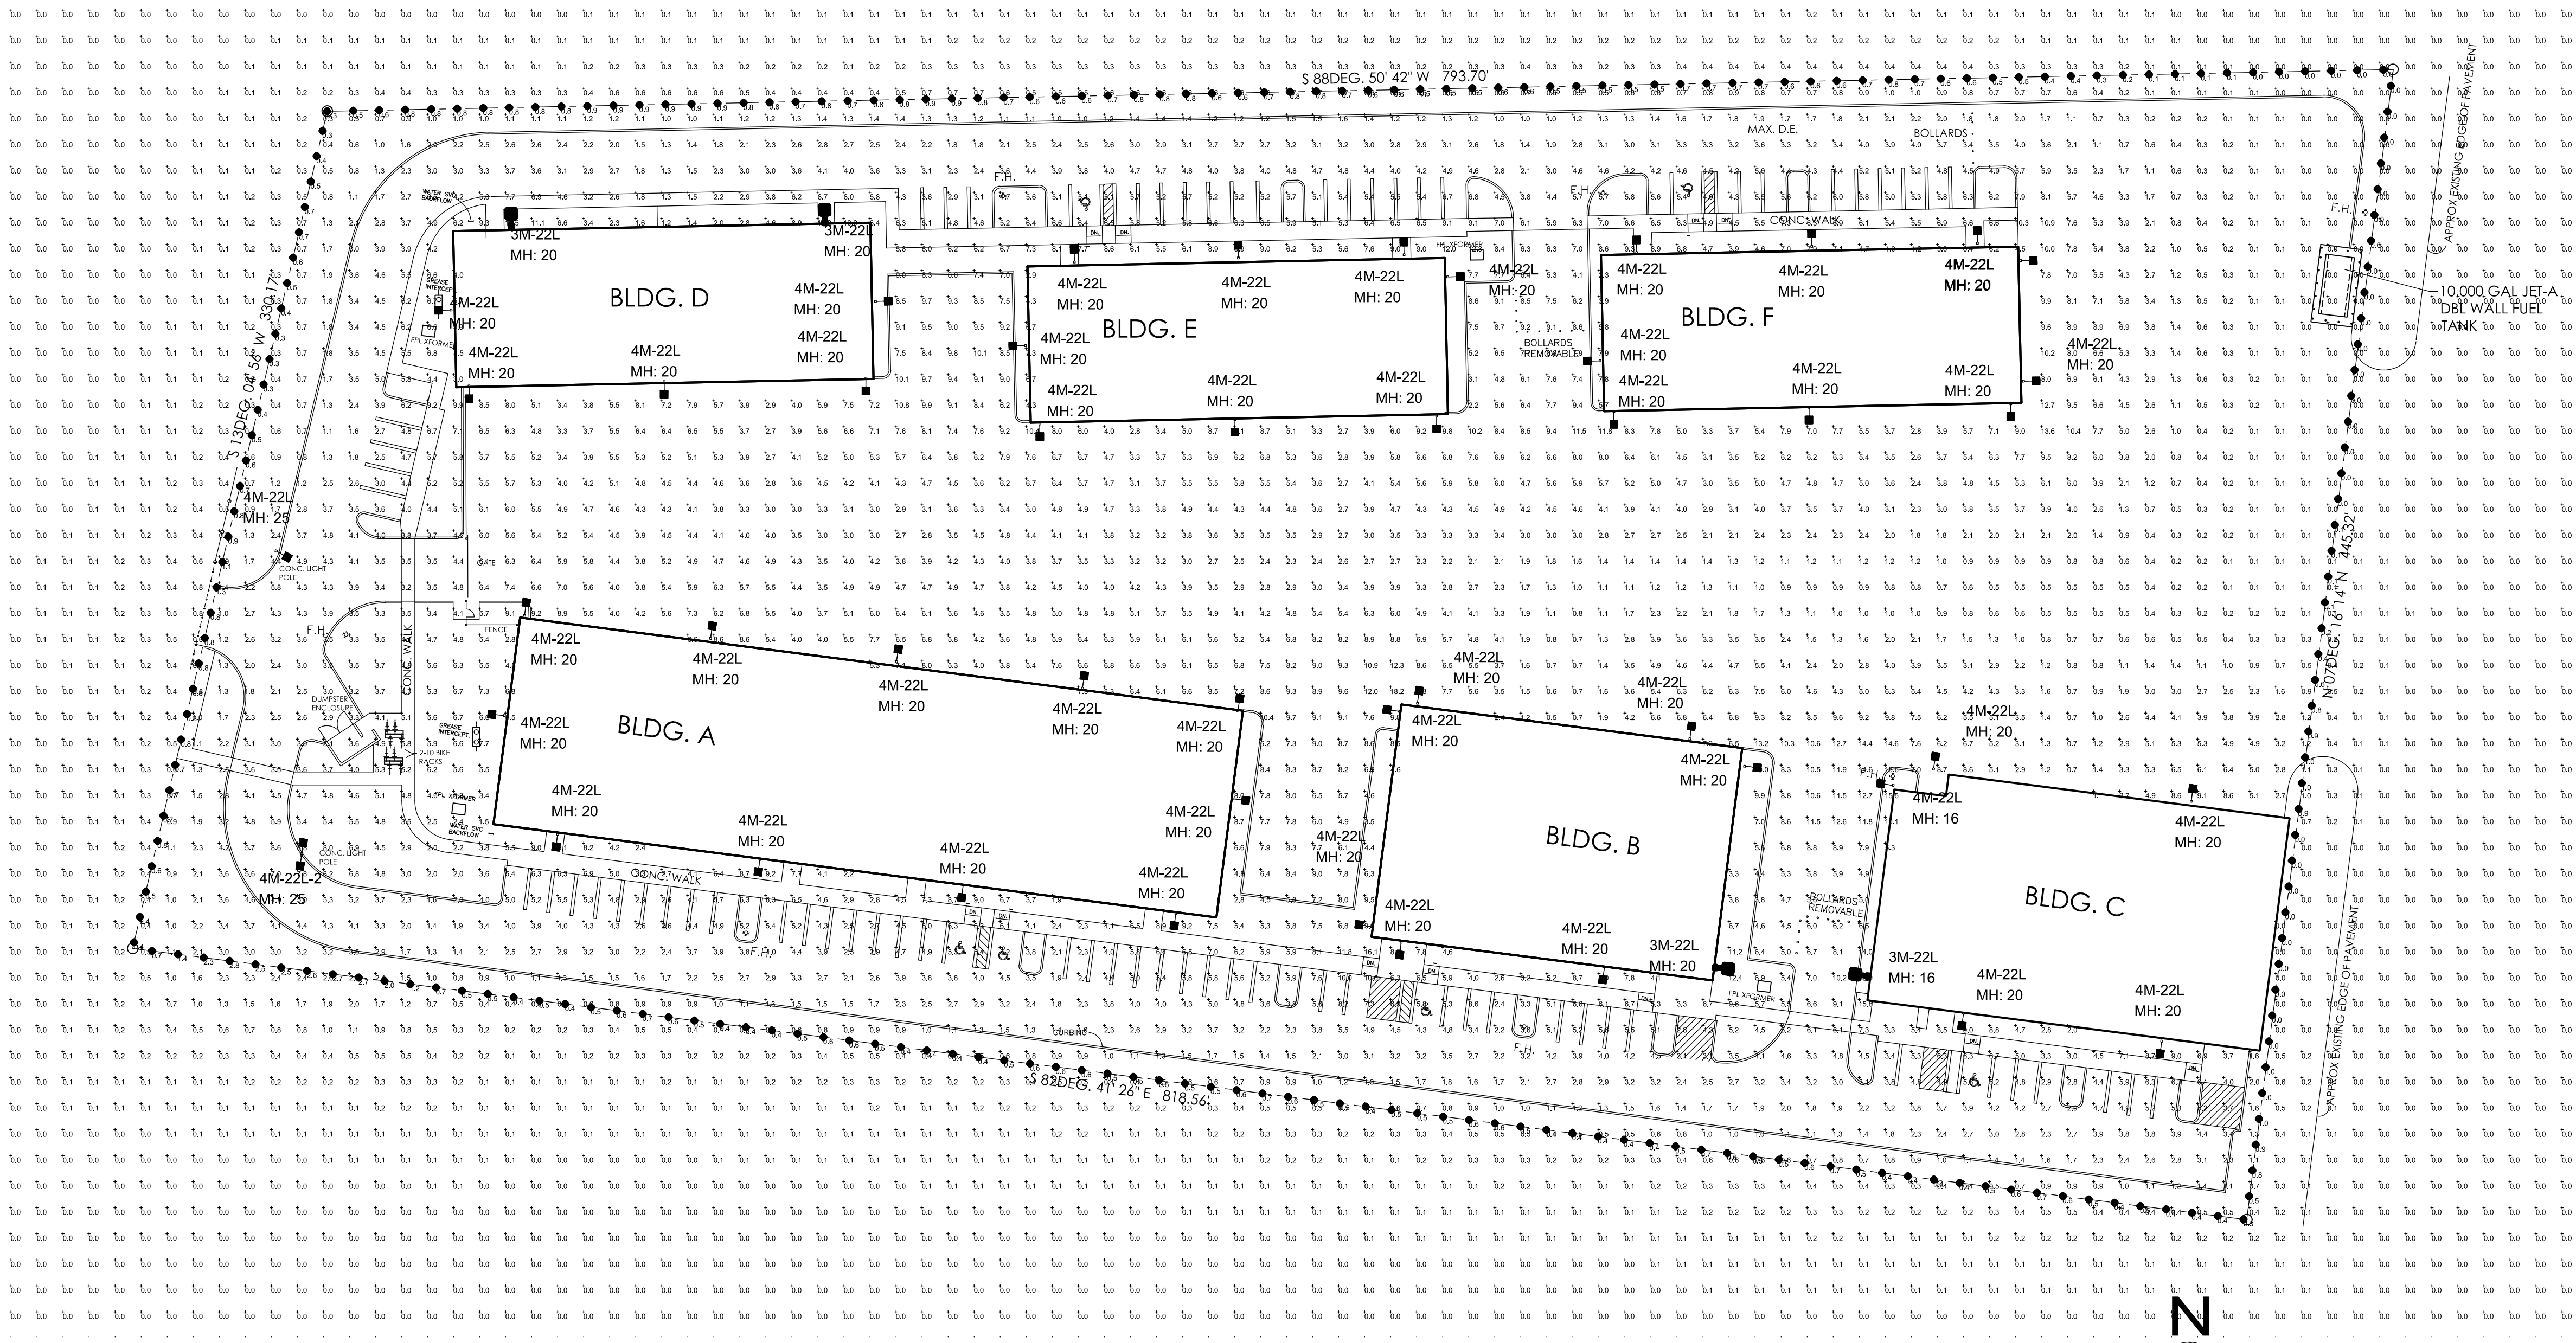

A5 SITE LIGHT PHOTOMETRIC PLAN  
1" = 40'-0"

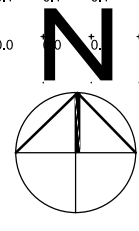

AA226001731  
WILLIAM J. GALLO FL AR008440

Brian Herbert  
Digitally signed by Brian Herbert  
Date: 2022.08.10 12:16:02 -04'00'

BRIAN P. HERBERT FL AR0015474

POMPANO BEACH AIR PARK PARCEL Y

601 NE 10TH ST.  
POMPANO BEACH  
FL 33060

POMPANO BEACH

COMPANY NAME		
REVISIONS		
No.	Description	Date
1	D.R.C. SUBMITTAL	2022-06-28
2	D.R.C. RESPONSE	2022-08-05

PROJECT STATUS  
D.R.C.  
DATE  
2021-03-24  
PROJECT NUMBER  
83-2020  
SCALE  
AS SHOWN

DRAWN BY  
JET  
CHECKED BY  
JET  
DRAWING TITLE

P&Z  
SL-101

PZ22-12000020  
11/16/2022