


PZ25- 12000046
01/21/2026

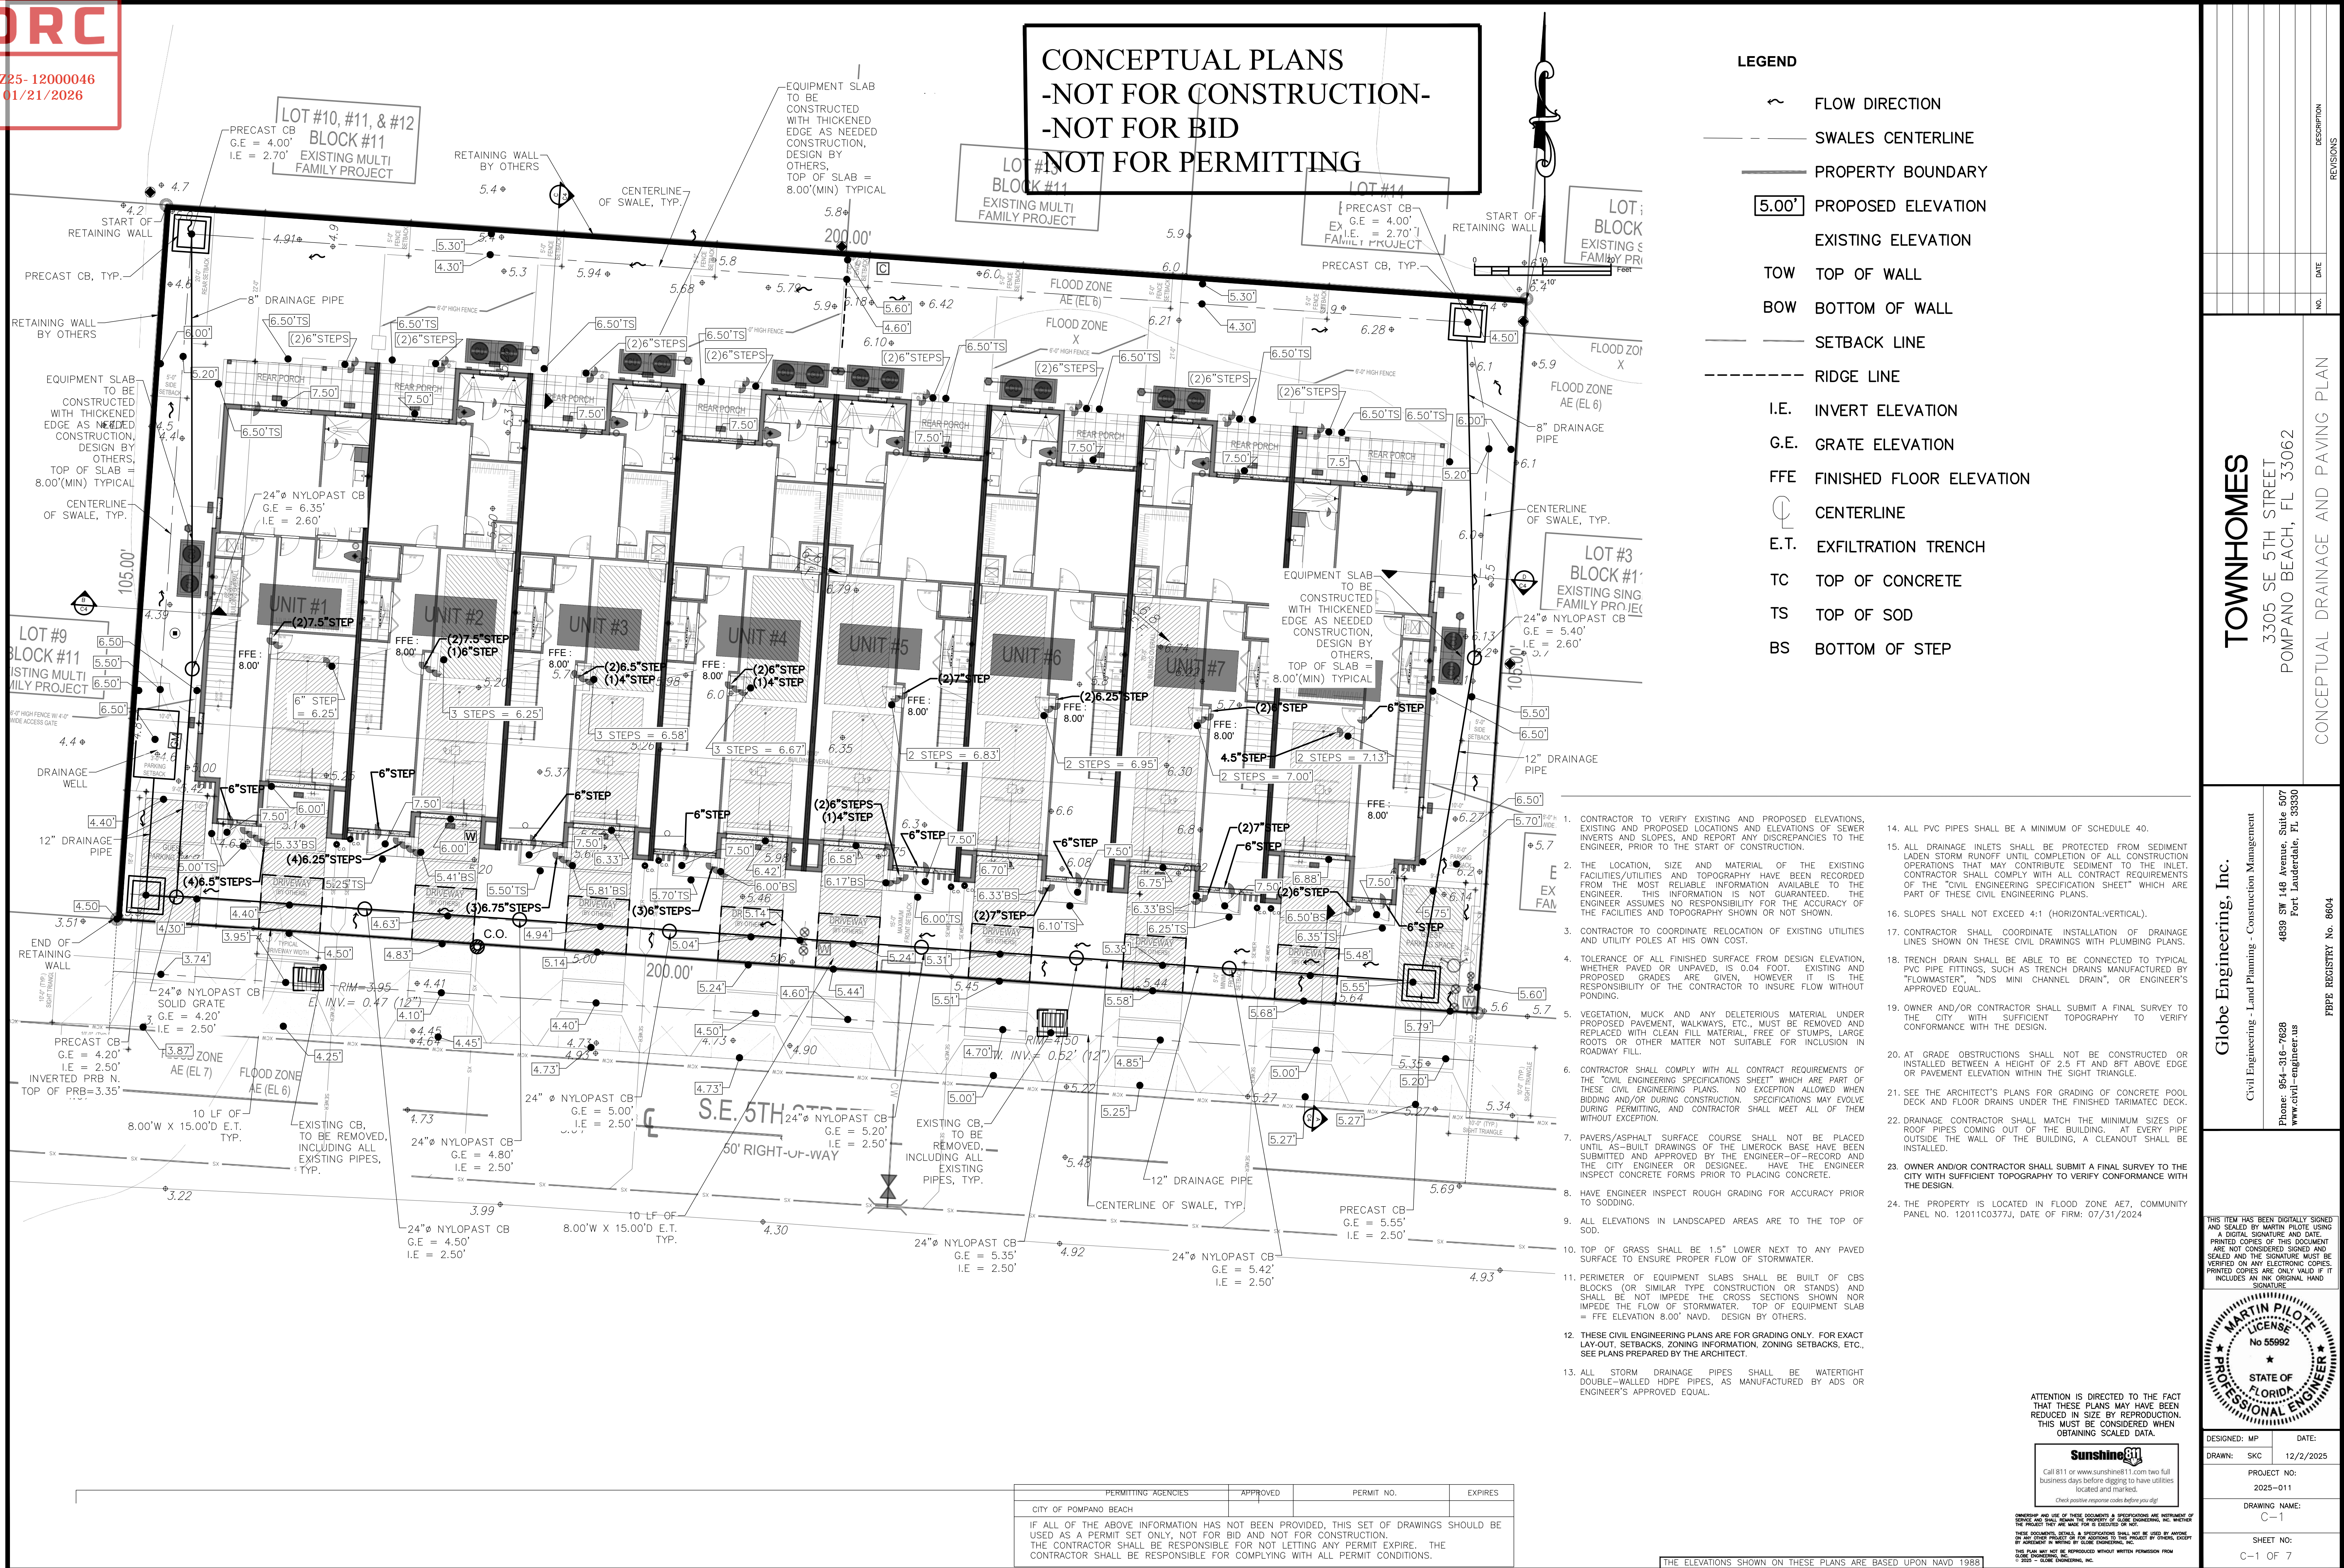

TOWNHOMES

3003 SE 31TH STREET
POMPANO BEACH, FL 33062

CONCEPTUAL DRAINAGE AND PAVING PLAN

Globe Engineering, Inc.

Civil Engineering - Land Planning - Construction Management

Phone: 954-316-7628
www.civil-engineer.us
4839 SW 148 Avenue, Suite 507
Fort Lauderdale, FL 33330

Phone: 954-316-7628
www.civil-engineer.us
4839 SW 148 Avenue, Suite 507
Fort Lauderdale, FL 33330

FBPE REGISTRY No. 8604



DESIGNED: MP	DATE:
--------------	-------

RAWN:	SKC	12/2/2025
-------	-----	-----------

PROJECT NO:

2025-011

DRAWING NAME:

C-1

SHEET NO:

C-1 OF 7

5. GLODE ENGINEERING, INC.

3 GLOBE ENGINEERING, INC.