
 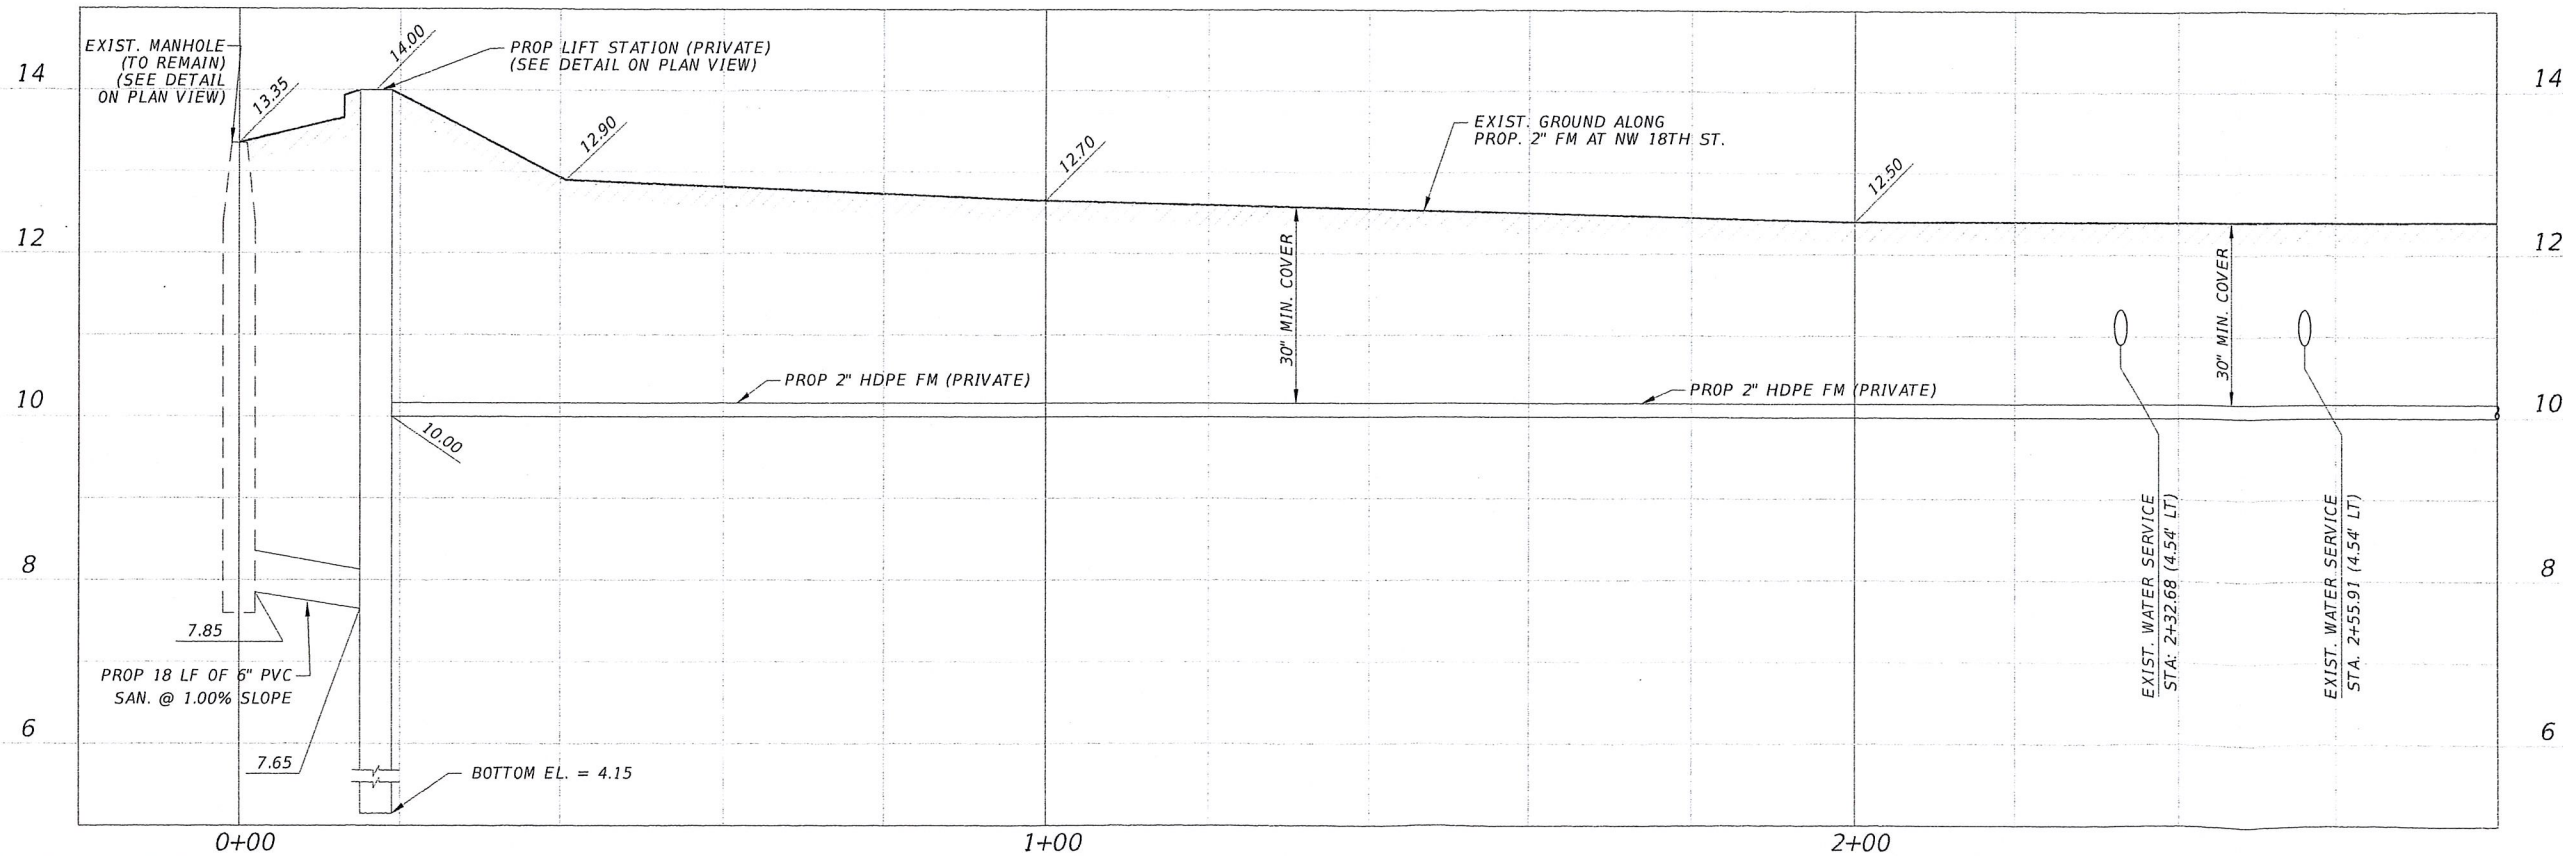


MATCH LINE - STA. 02+55



**FOR PERMITTING ONLY  
NOT FOR CONSTRUCTION**

EXHIBIT B

RUBEL SIDDIQUE, P.E.  
P.E. LICENSE NO. 67239

SEAL

SSN ENGINEERING, LLC  
1925 NW 18 STREET, STE 30  
POMPANO BEACH, FL 33069  
PH: (954) 944-3272  
FAX: (954) 933-5124  
FBPE No. C40002985  
WWW.SSNENGINEERING.COM

NO.	REVISIONS	DATE	BY

PROJECT NO.  
201605001

DATE: 08-31-2016

SCALE: AS SHOWN

DESIGNED BY: RS

DRAWN BY: RS

CHECKED BY: RS

**ADDITION OF SANITARY SEWER LIFT STATION  
FOR  
DUBLIN HOLDINGS, LLC  
1925 NW 18 STREET, POMPANO BEACH, FL 33069**

**SANITARY SEWER FORCE MAIN  
PLAN AND PROFILE**

**SHEET  
NO.  
C-300**

