


DRC

PZ22-12000009
11/16/2022

DRC

PZ22-12000009
02/01/2023

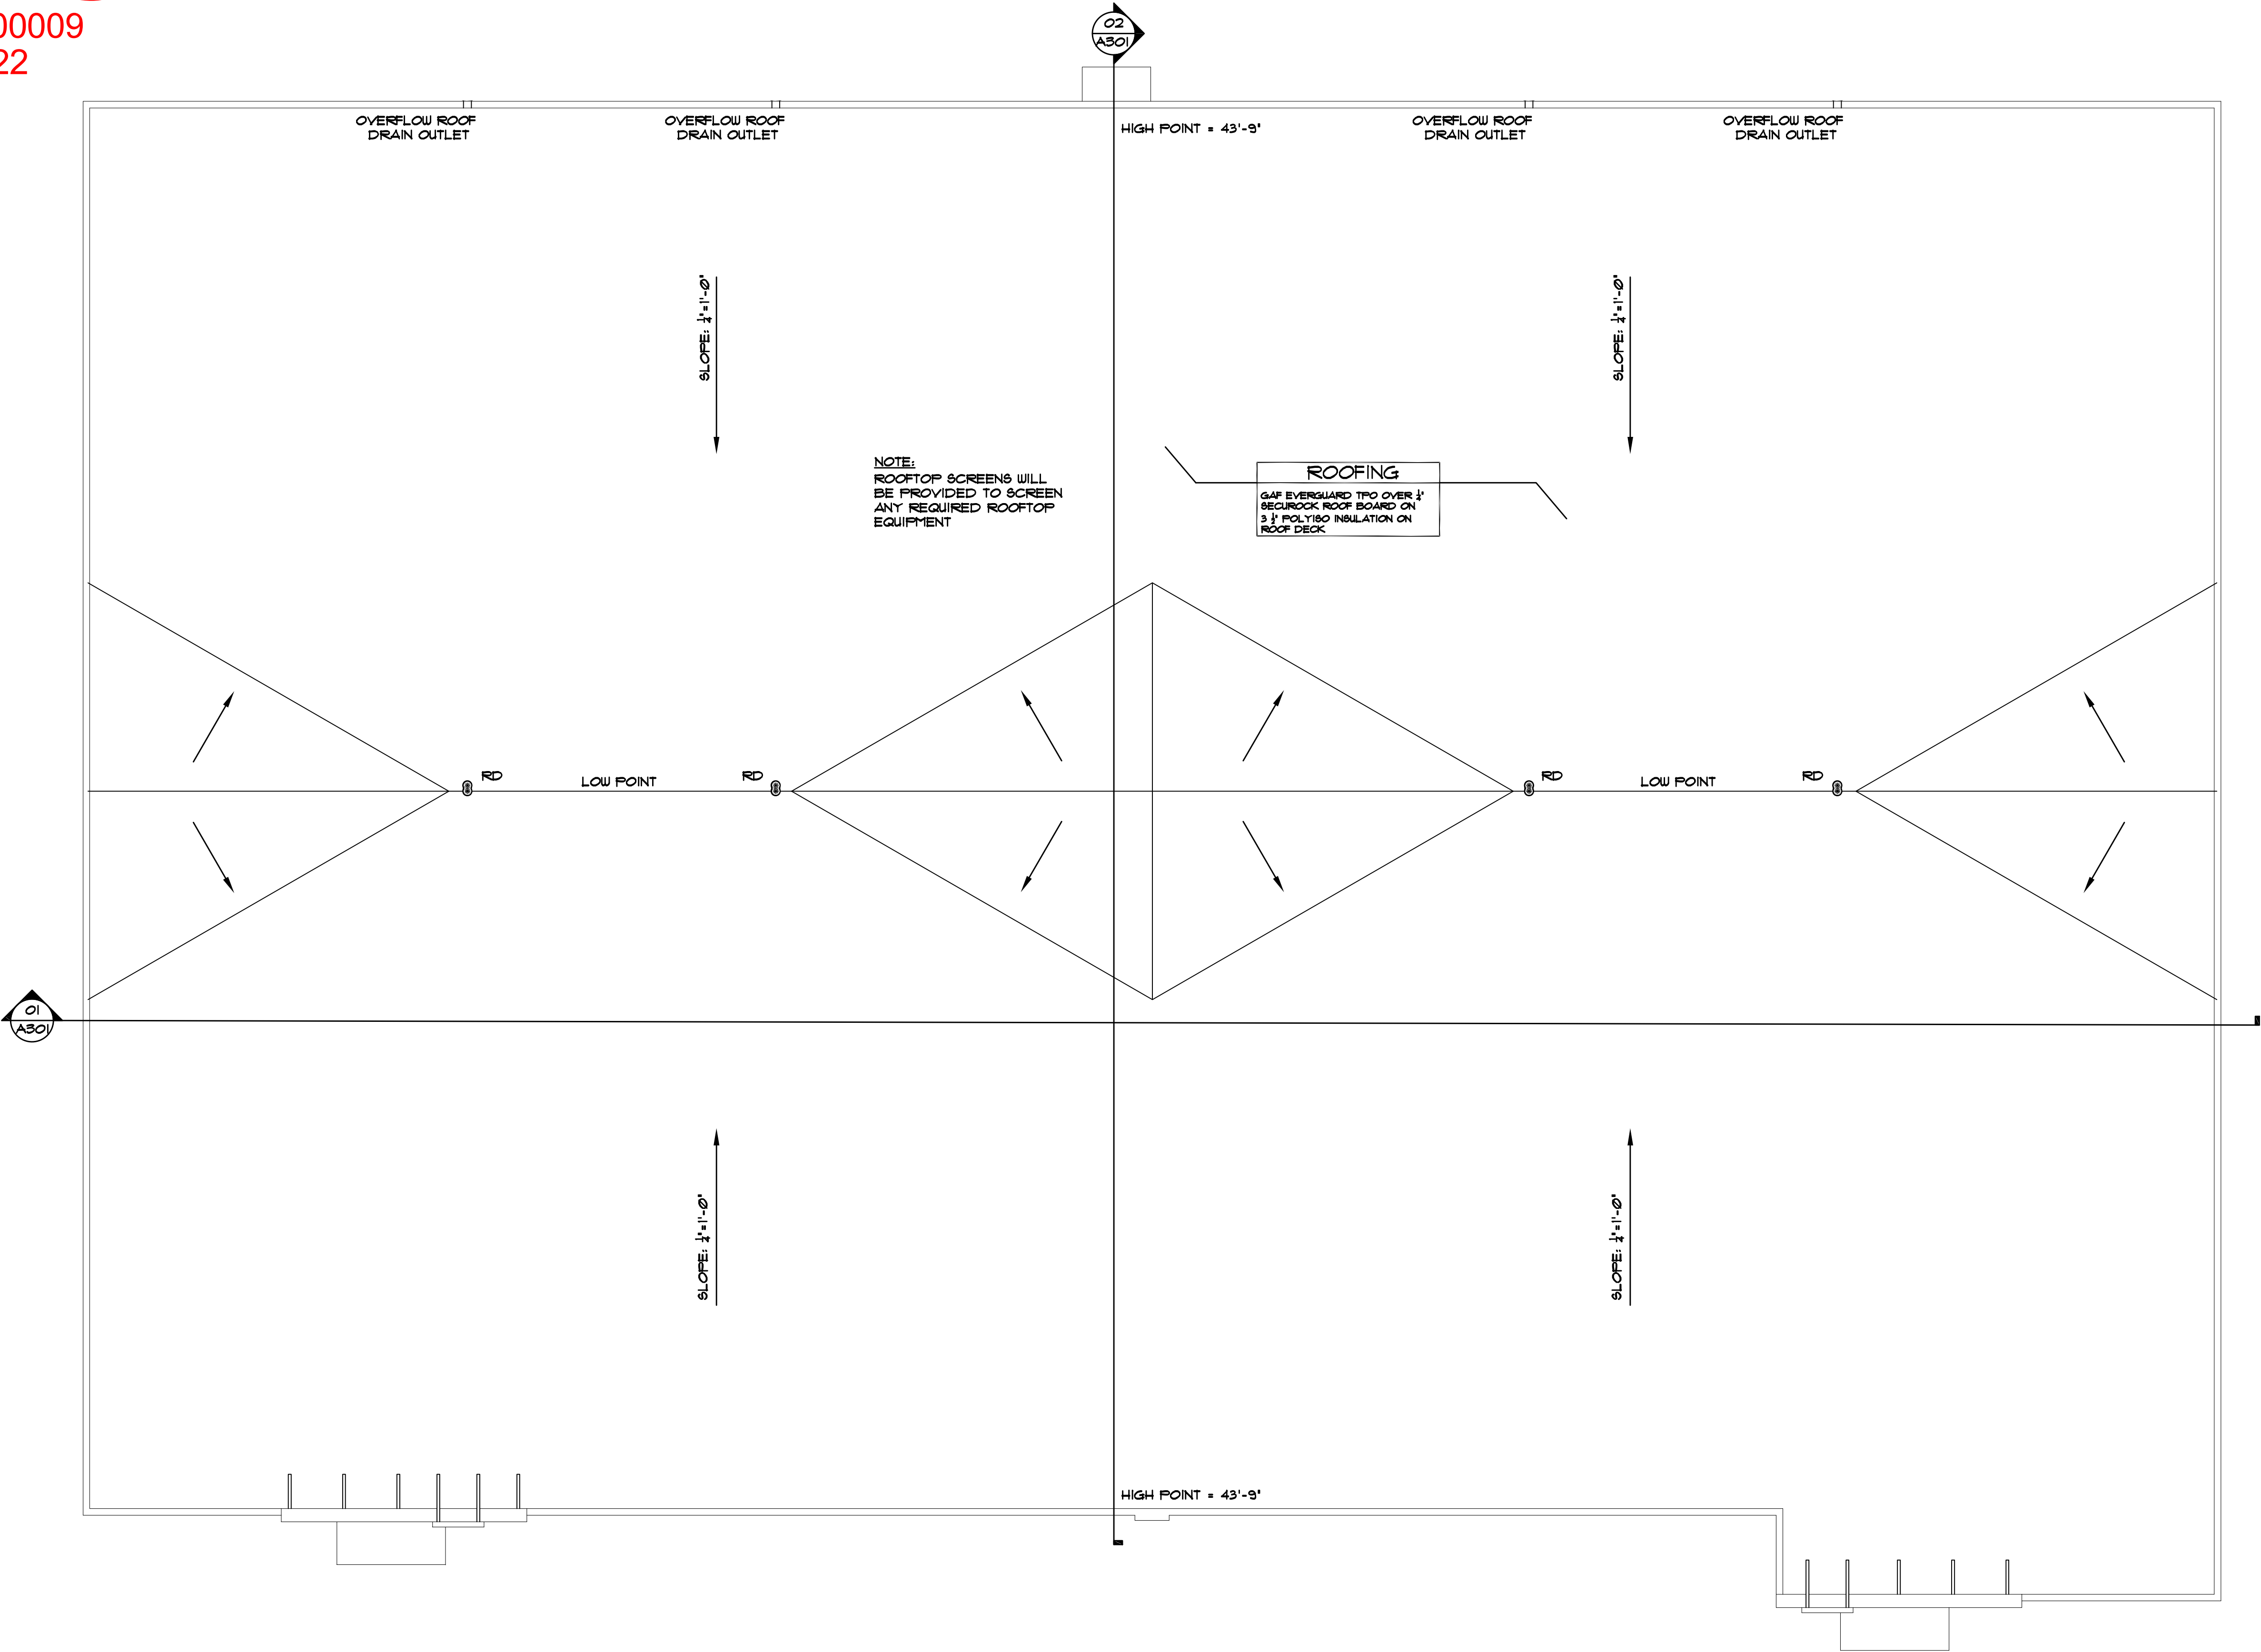

01 ROOF PLAN
SCALE: 3/32" = 1'-0"



PH: (954) 941-3329 FAX: (954) 943-7708
design kollaborative
architects / planners, inc.
MEMBER: AMERICAN INSTITUTE OF ARCHITECTS - AIA 000954
61 NE 1ST STREET, SUITE 2, POMPANO BEACH, FL 33060

Blaise E. McGinley
Architect
Digitally signed by Blaise E. McGinley
DN: cn=US, o="DK Architects and
Planners, Inc.", ou=Blaise E. McGinley,
email=blaise@dk-group.com
Reason: I am the author of this
document.
Location: your signing location here
Date: 2022.09.28 13:07:08
Data: 20220928130708+0000

PROPOSED SITE DEVELOPMENT
ALLIANCE HP MANAGEMENT
2700 GATEWAY DRIVE
POMPANO BEACH, FL 33069

DATE	04/01/2022	
PERMIT	00/00/00	00/00/00
CONSTR	00/00/00	00/00/00
PROJECT NO.	22003	
BY	REVISIONS	DATE

SHEET NO.
A102
PRINTED: 9/28/2022 1:07 PM