


Calculation Summary								
Label	Fixture Type		Units	Avg	Max	Min	Avg/Min	Max/Min
Parking Garage Floor	Illuminance		FC	12.3	12.3	12.3	12.3	12.3

Luminaire Schedule								
Symbol	Qty	Label	Arrangement	Description	LMF	Luminaire Lumen	Luminaire Watts	Total Watts
○	13	01	Single	Geopia Lighting LRC-30-SLED-40K-UVV-W8	0.900	4810	37	481
○	18	01E	Single	Geopia Lighting LRC-30-SLED-40K-UVV-W8 (Connected to Generator)	0.900	4810	37	666

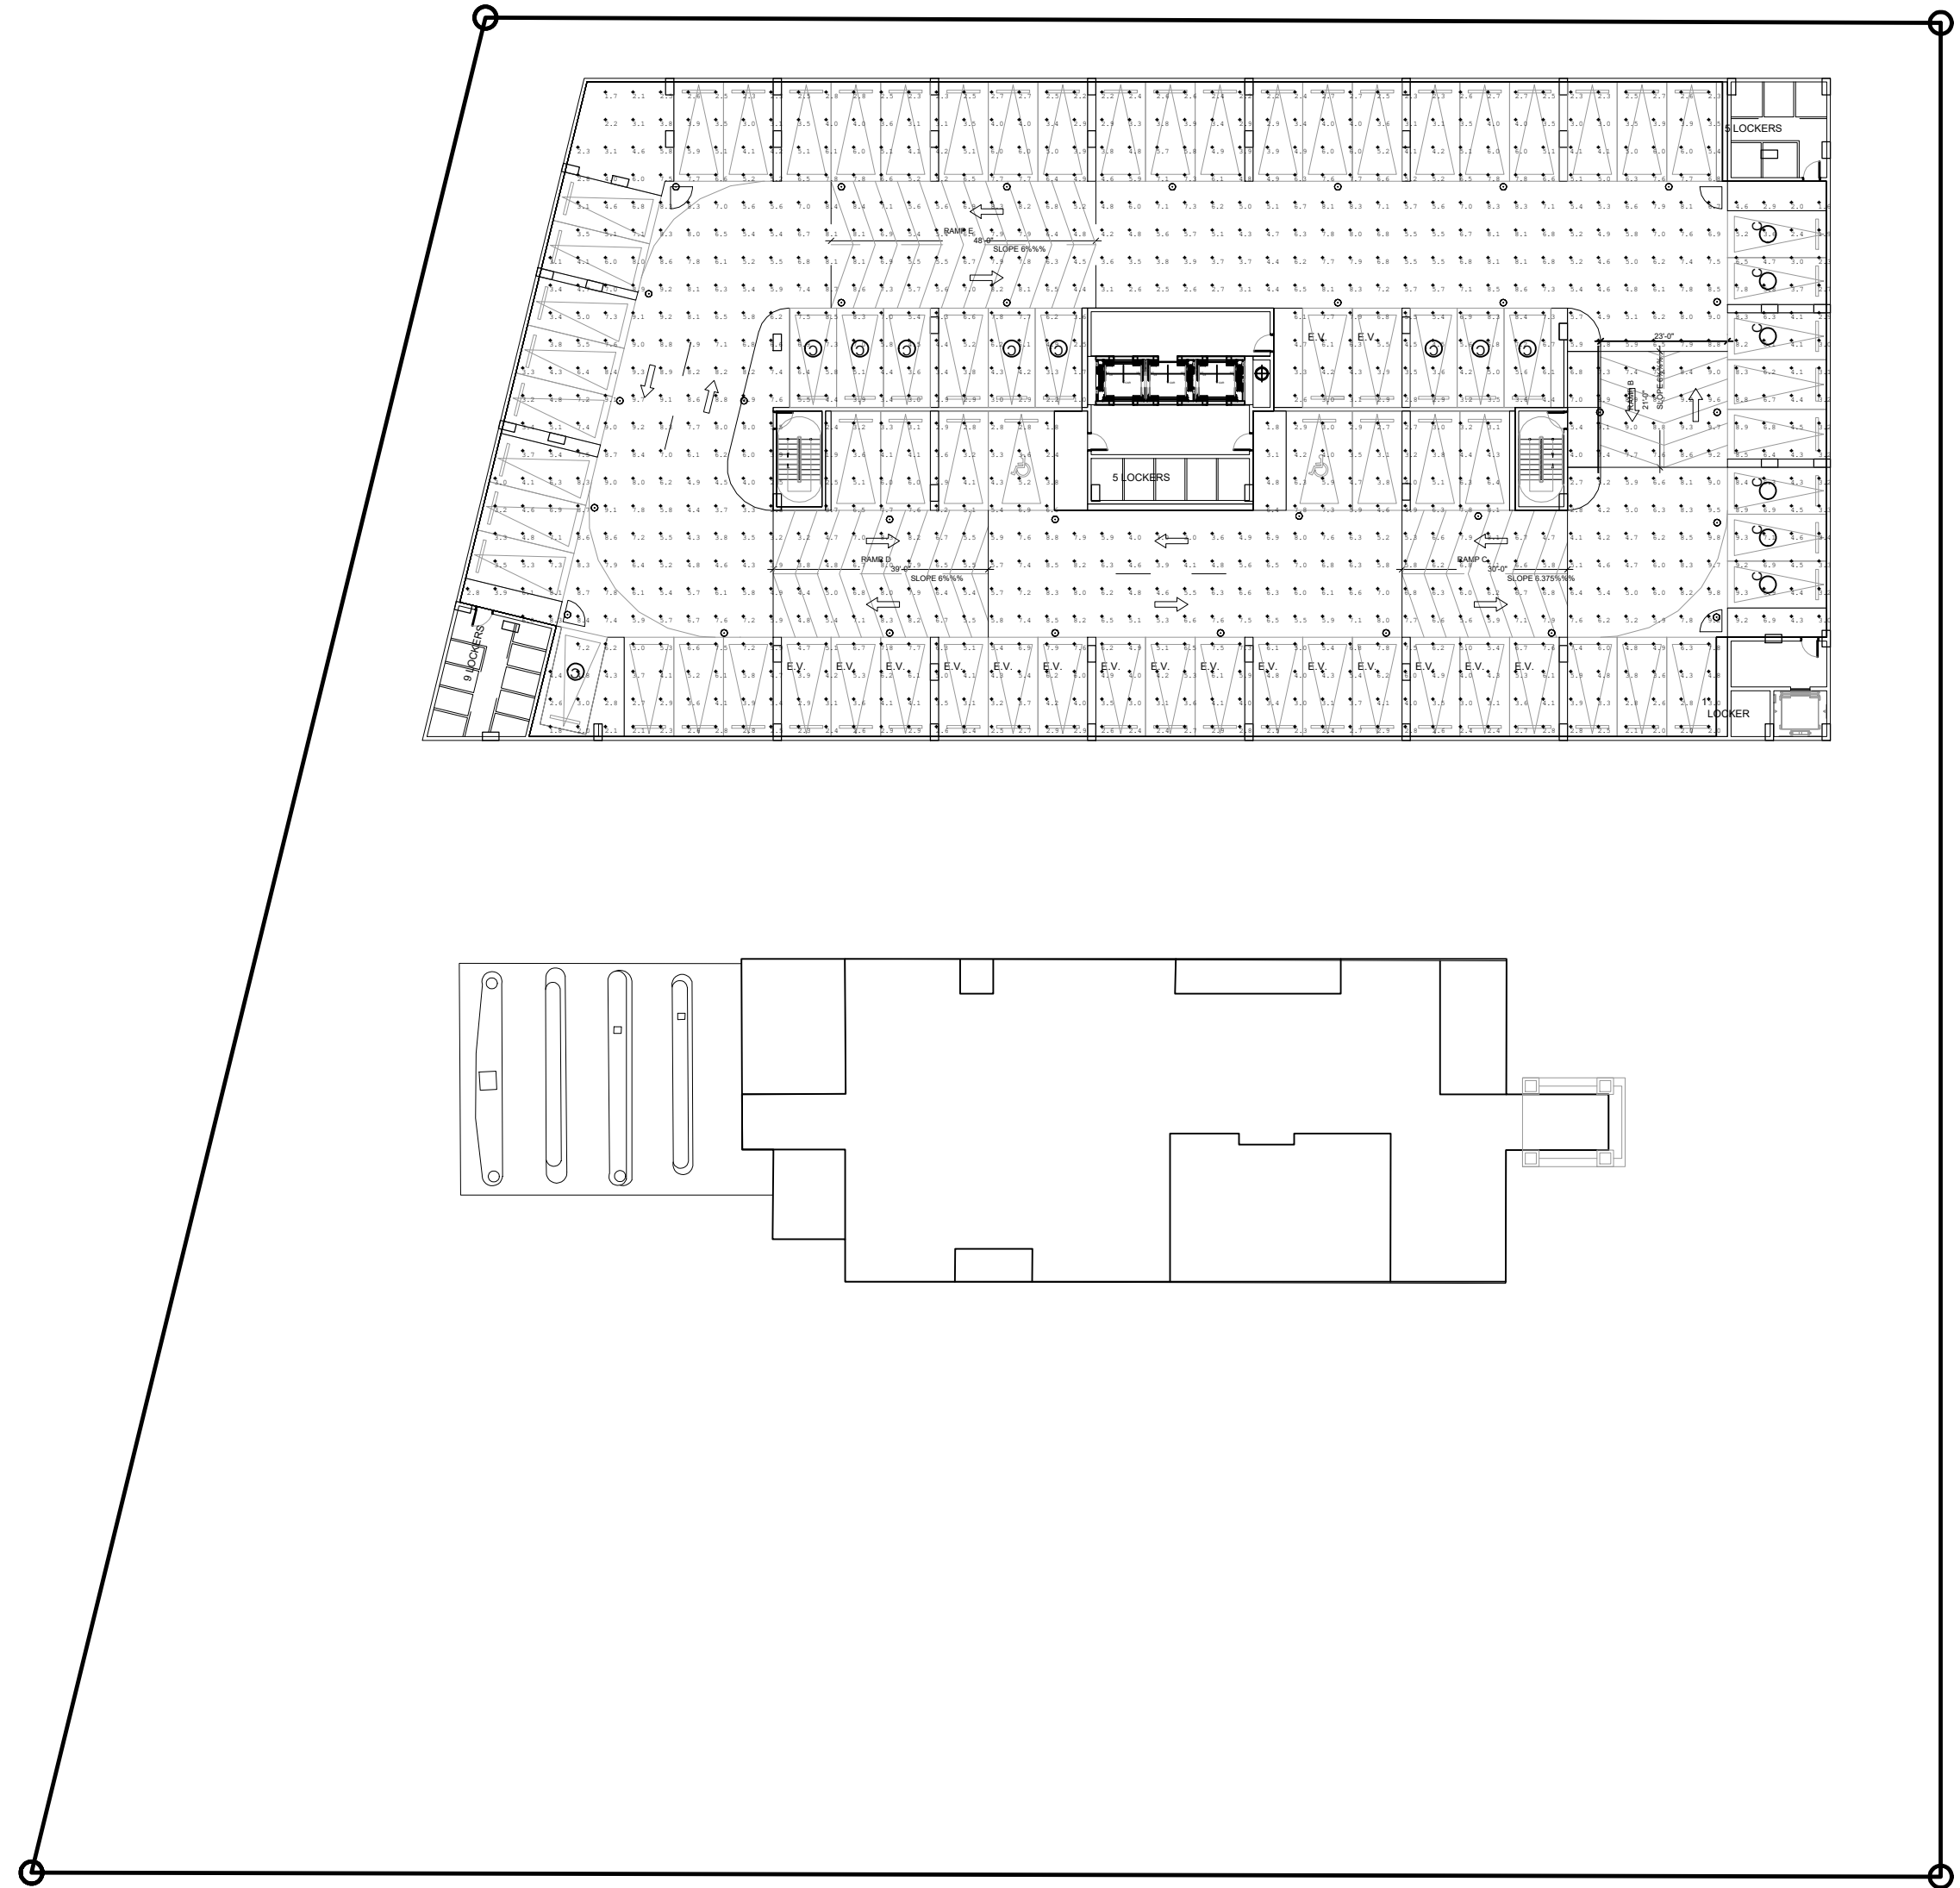


01
P-003

LEVEL 02
PHOTOMETRICS - NORMAL
SCALE: 1"= 30'-0"

Calculation Summary								
Label	Fixture Type		Units	Avg	Max	Min	Avg/Min	Max/Min
Parking Garage Floor	Illuminance		FC	12.3	12.3	12.3	12.3	12.3

Luminaire Schedule								
Symbol	Qty	Label	Arrangement	Description	LMF	Luminaire Lumen	Luminaire Watts	Total Watts
○	13	01	Single	Geopia Lighting LRC-30-SLED-40K-UVV-W8	0.900	4810	37	481
○	18	01E	Single	Geopia Lighting LRC-30-SLED-40K-UVV-W8 (Connected to Generator)	0.900	4810	37	666

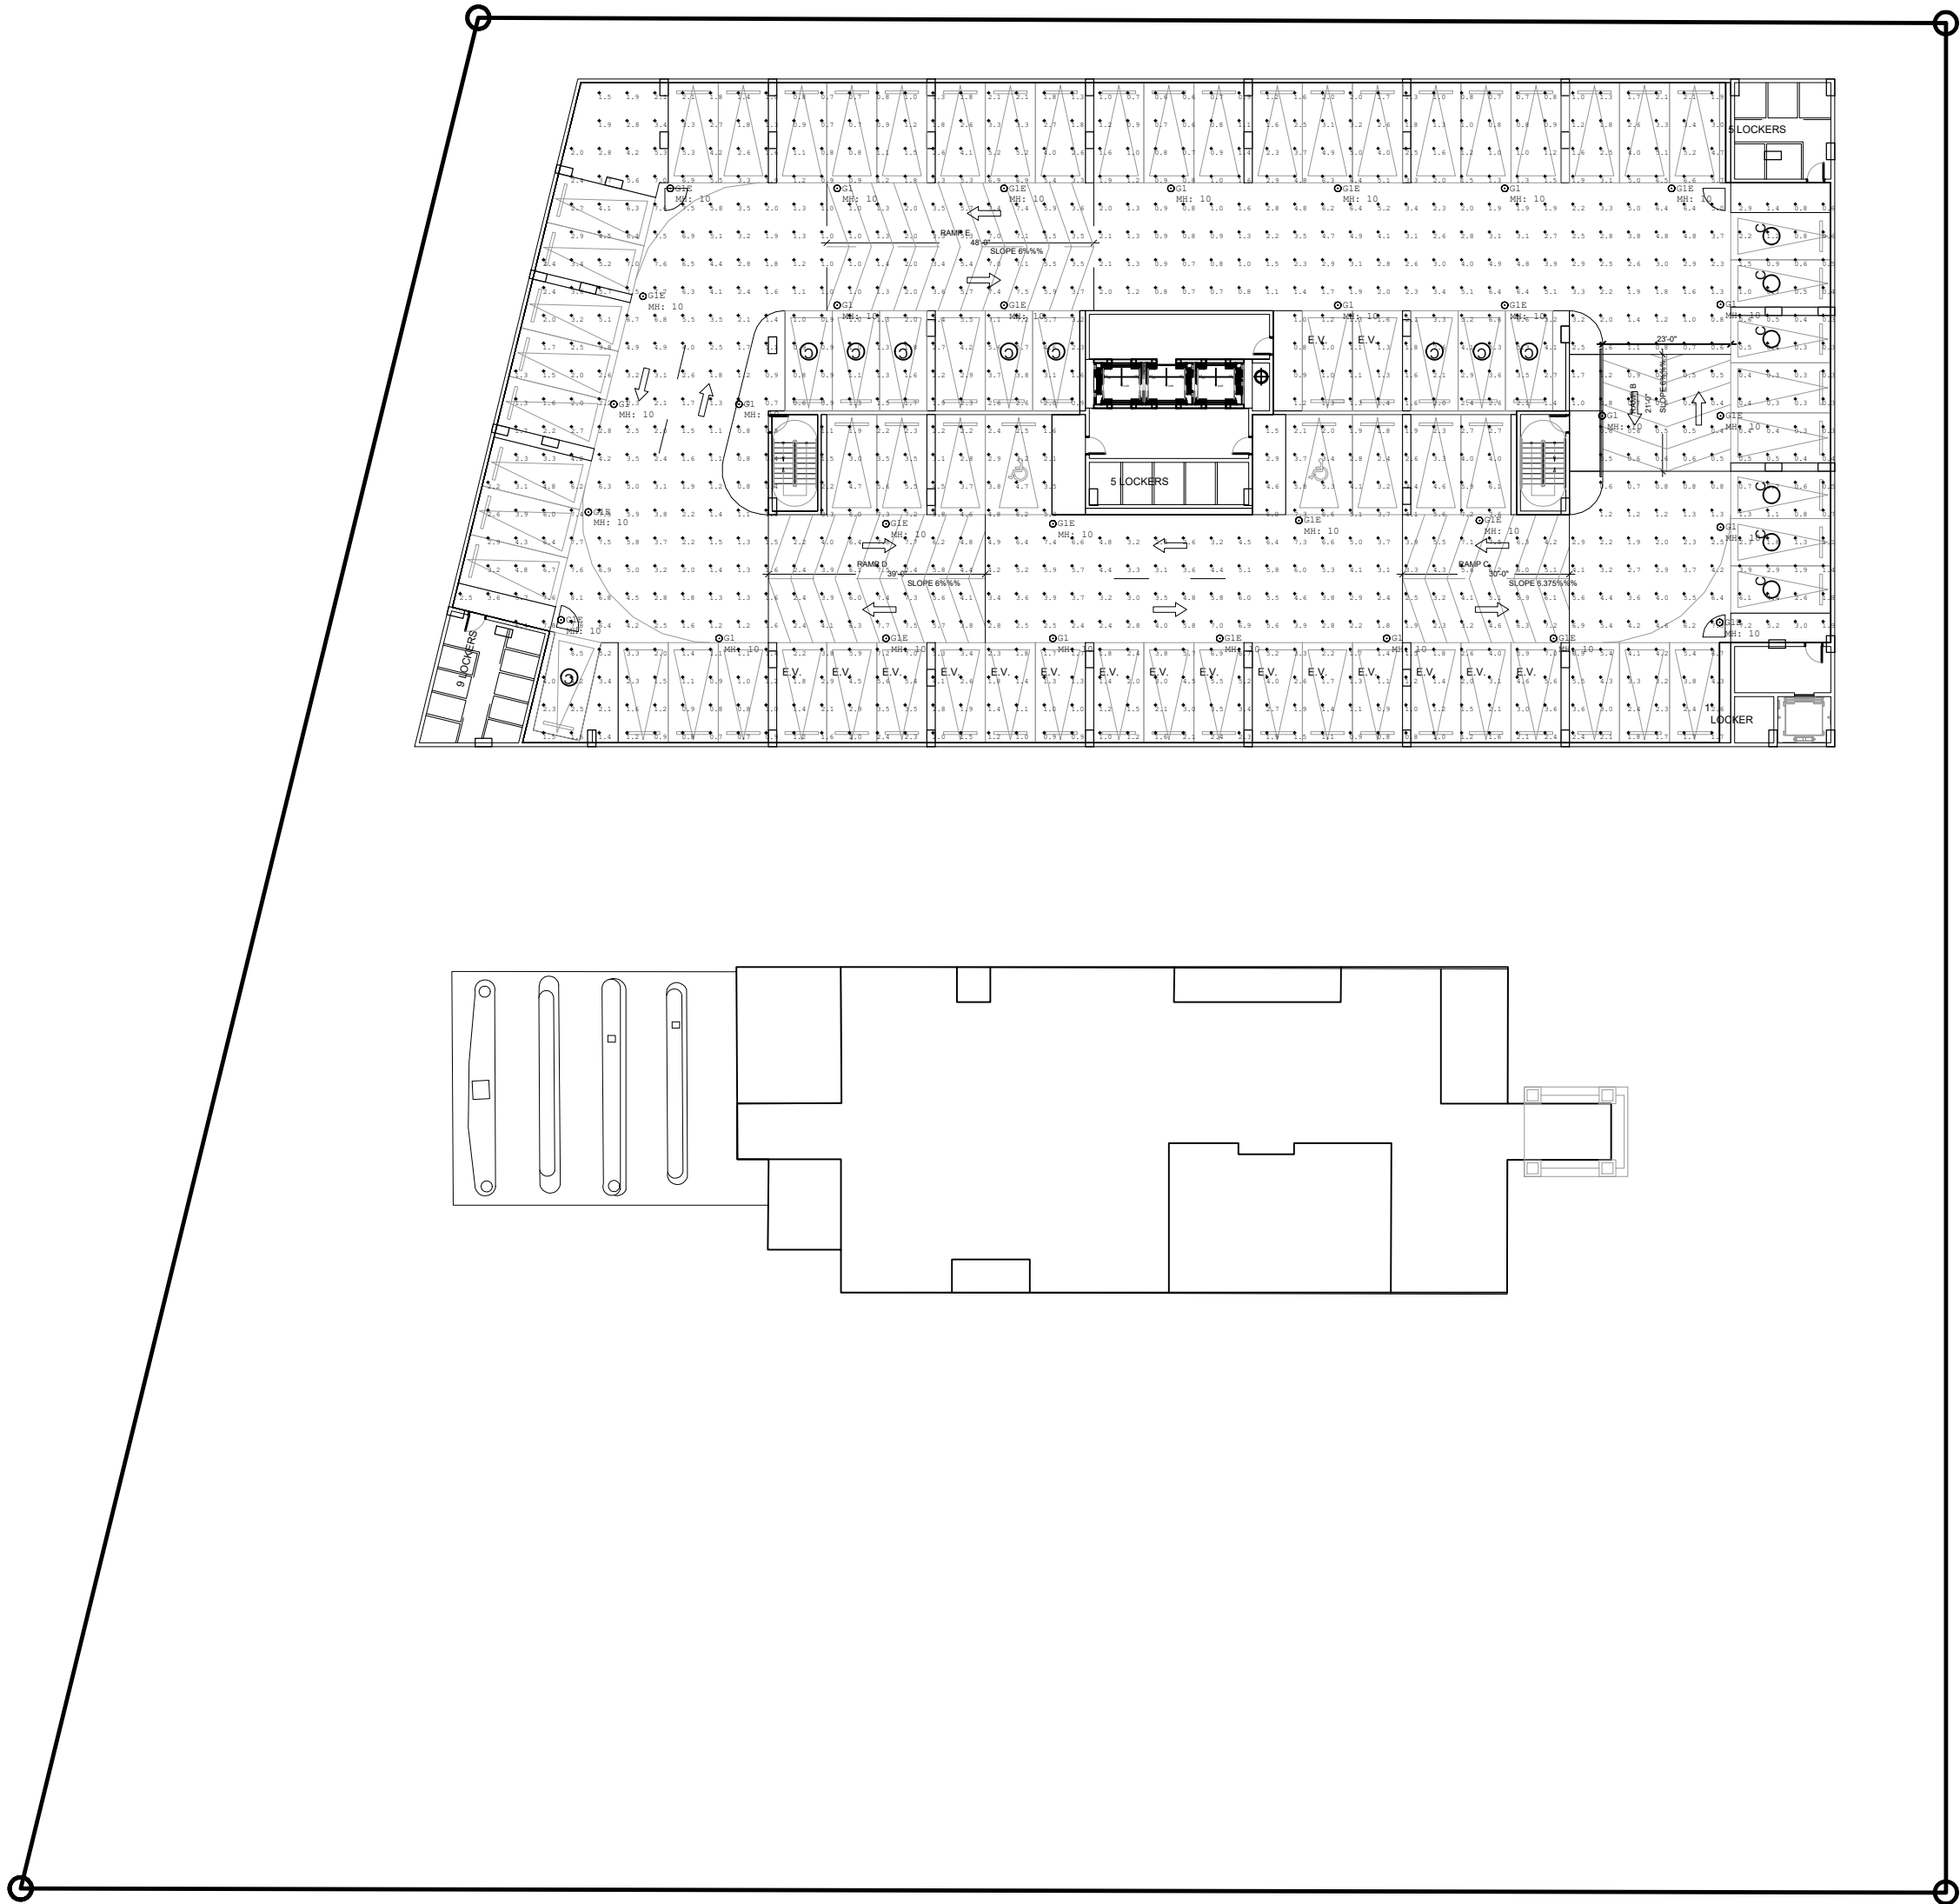

01
P-003

LEVEL 02
PHOTOMETRICS - EMERGENCY
SCALE: 1"= 30'-0"


SEAL

TO THE BEST OF MY KNOWLEDGE, THE PLANS AND SPECIFICATIONS COMPLY WITH THE APPLICABLE MINIMUM BUILDING CODES AND THE APPLICABLE FIRE-SAFETY STANDARDS AS DETERMINED BY THE LOCAL AUTHORITY IN ACCORDANCE WITH THIS SECTION AND 633 FLORIDA STATUTES.

STEPHANE L'ECUYER
AR 93637

ISSUE FOR:

DRC SUBMITTAL

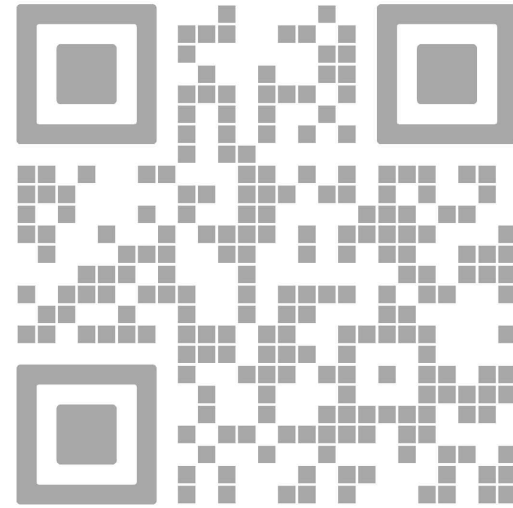

REV.	DATE	DESCRIPTION
01	05-13-2025	D.R.C. SUBMITTAL

ALL MEASUREMENTS MUST BE VERIFIED BEFORE BEGINNING THE WORKS. NO MEASUREMENTS ARE TO BE SCALED DIRECTLY FROM THIS DRAWING.

Key section

Client

VERA FUND
NICK POLYUSHKIN
& YURI KHARITONENKOV
TEL: 305.833.3303

Project

**1600 S FEDERAL HIGHWAY
(MIXED-USE PROJECT)**

1600 SOUTH FEDERAL HIGHWAY,
POMPAÑO BEACH, FL 33062

Title	
LEVEL 02 PHOTOMETRICS	
Drawn J. WU	Field ARCHITECTURE
Verified N. TREMBLAY	Scale as shown
Approved S. L'ECUYER	Date 05-28-2025
Project Manager J. WU	Dwg. no. P-003
Project 24-838	