



PROPOSED AREA FOR ROOFTOP MECHANICAL UNITS
ROOFTOP MECHANICAL EQUIPMENT SCREEN: PROVIDE
ALUMINUM OR GALVANIZED STEEL LOUVERED SCREEN
SYSTEM, HURRICANE RATED PER FBC WIND LOAD
REQUIREMENTS. SCREEN HEIGHT TO FULLY CONCEAL ROOF
TOP EQUIPMENT (+/- 6'-6") FROM ALL PUBLIC VANTAGE
POINTS

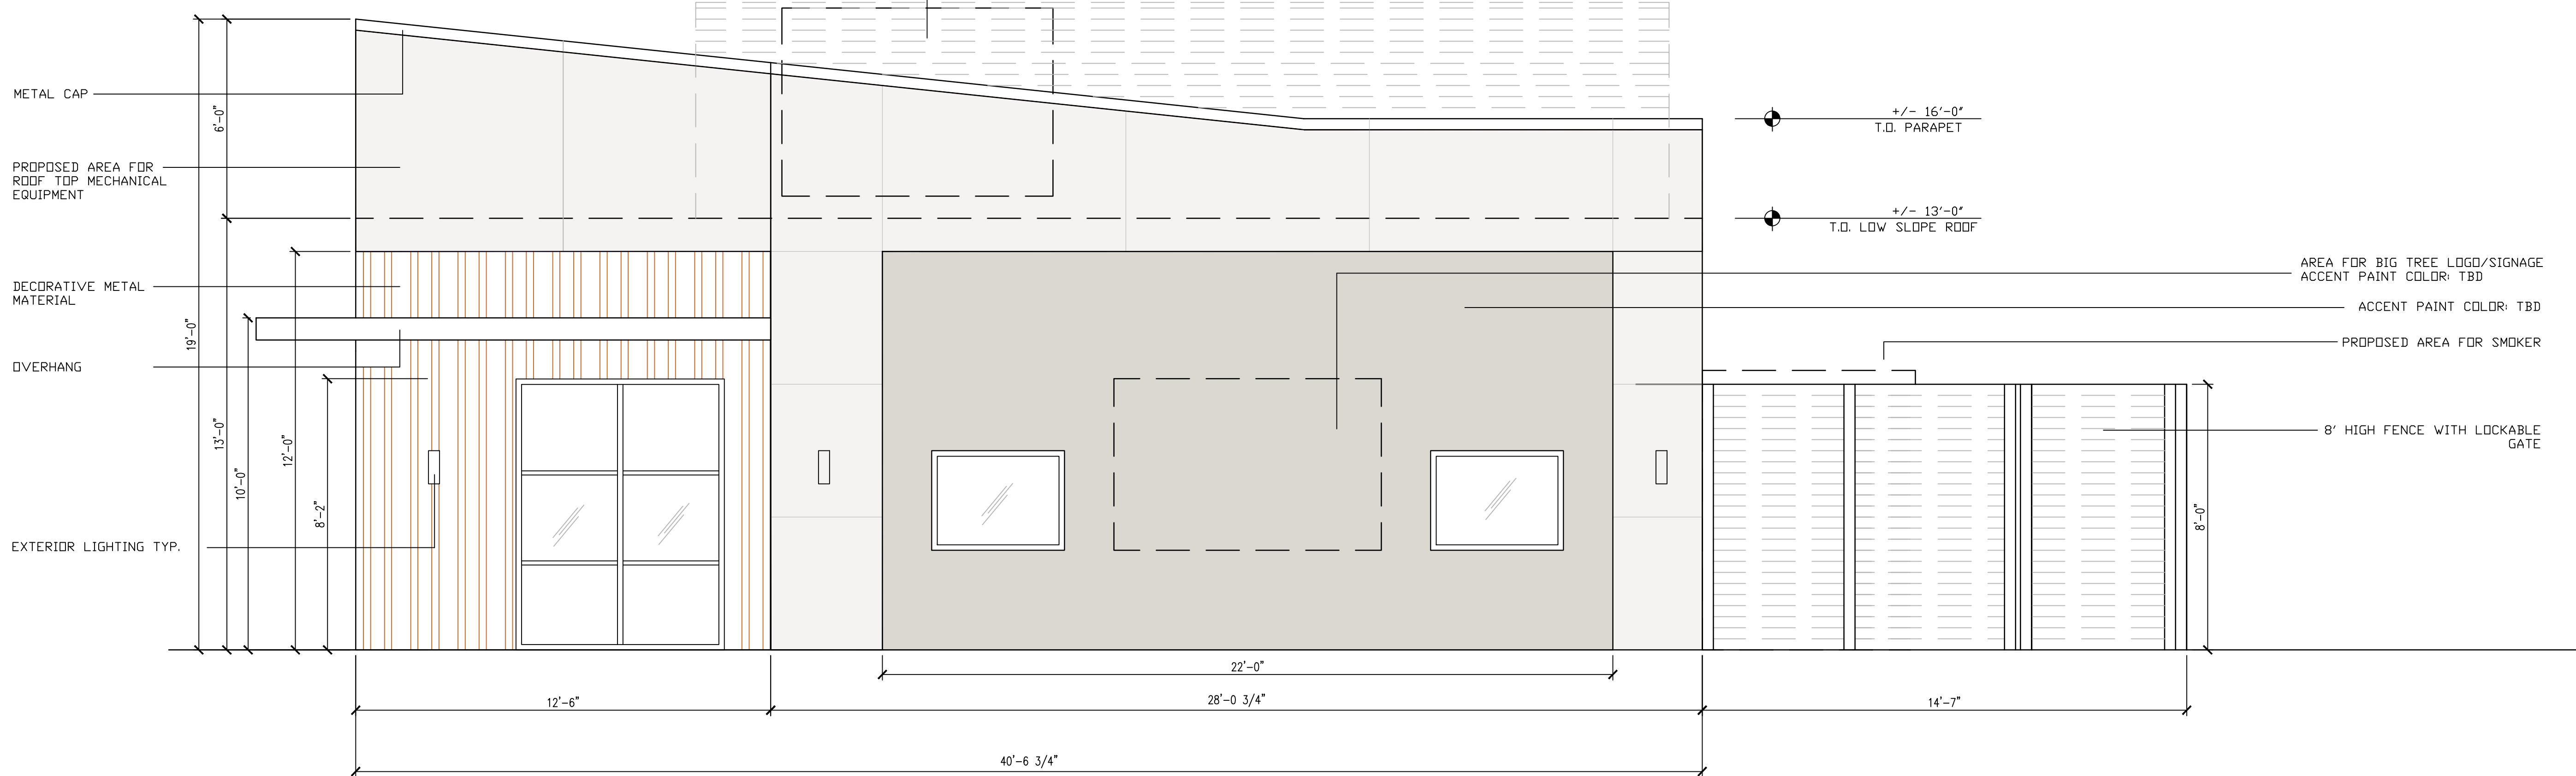

01

WEST EXTERIOR ELEVATION

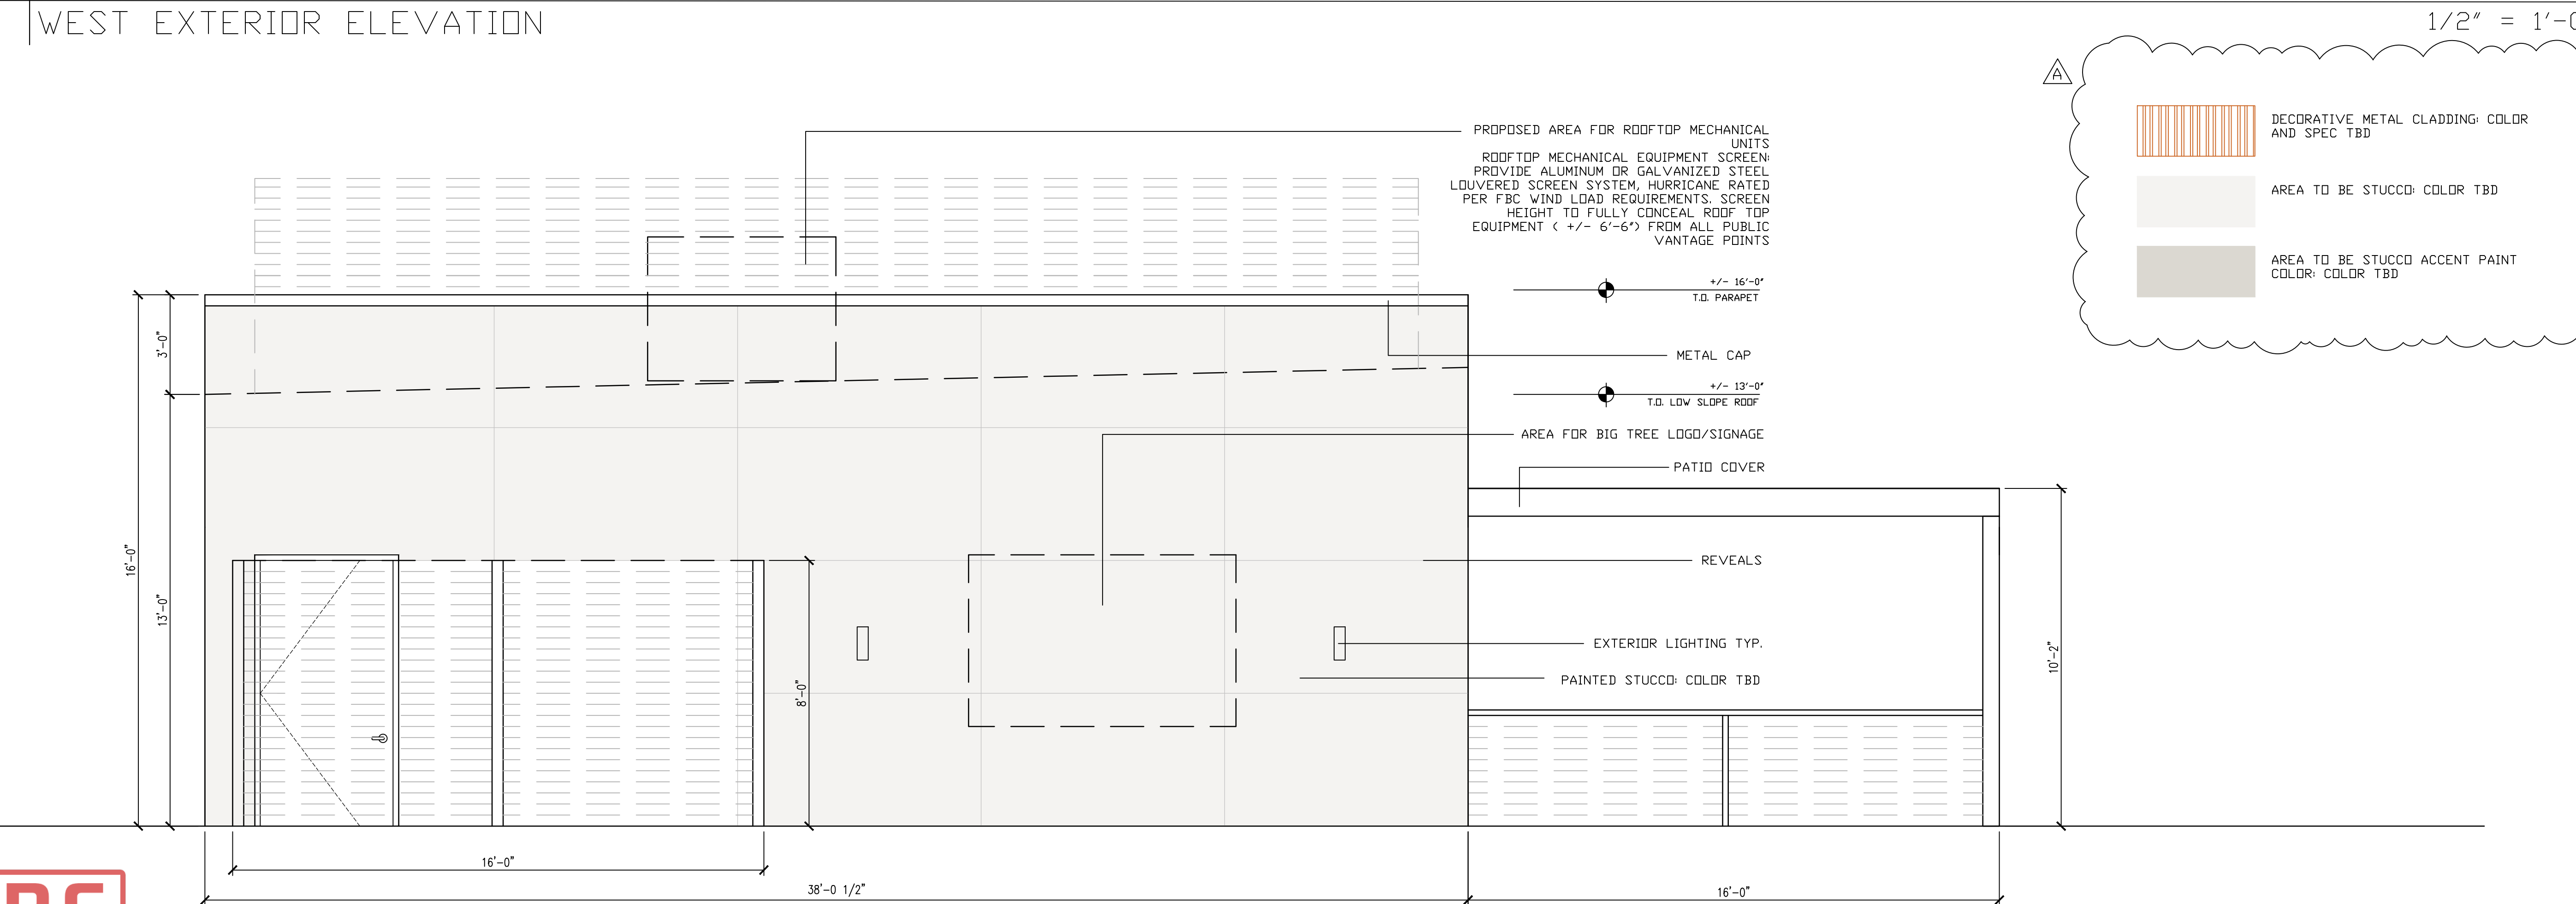

DRC

PZ23-12000012
12/03/2025

SOUTH EXTERIOR ELEVATION

STUDIO US
[DESIGN]

361 N UNIVERSITY DRIVE
PLANTATION, FLORIDA 33324


BIG TREE BBQ
NW 5TH STREET
POMPANO BEACH, FLORIDA 33069

REVISIONS

No.	DATE	DESCRIPTION
1	10/16/25	DRC REVISIONS

CONSTRUCTION DOCUMENTS

PROJECT NUMBER: 2023-16
ISSUE DATE:
DRAWN BY: SNB
CHECKED BY: SNB
FILENAME: 2023-16 BIG TREE BBQ

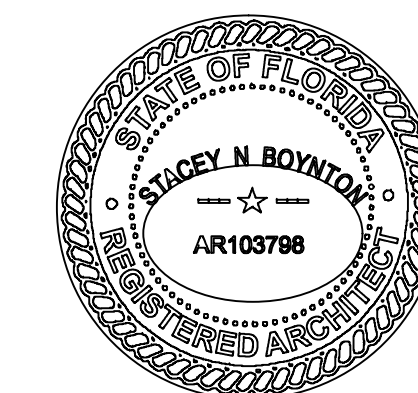

A-3.1
SHEET

1/2" = 1'-0"