

DRG

TI

PZ25-12000021
01/07/2026

ARCHITECTS
Associates, Inc. AA26001933

ARCHITECTURE | PLANNING | INTERIOR DESIGN

14125 NW 80th Avenue Suite 303
Miami Lakes - Florida - 33016
info@dtiarchitect.com
www.dtiarchitect.com

STATE OF FLORIDA
CARLOS PIZARRO
AR0013079
REGISTERED ARCHITECT

Carlos Pizarro, R.A.
AR - 0013079

Revisions:

08.11.2025BSO & ZONING

12.01.2025REVISION

OWNER / DEVELOPER:

RED LINK MANAGEMENT
CORP

2750 NE 185TH ST. #304
AVENTURA, FLORIDA 33180

PROJECT:

FOLIO 4942-03-27-0012
PROPOSED SHELL BLDG @
2100 WEST ATLANTIC BLDG

2100 W ATLANTIC BLVD
POMPANO BEACH, FLORIDA 33069

Job Number: 24109.01

File name:

Issued Date: 05-14-2025

Drawn by: A.S


Checked by: T.R.

SHEET NAME

SITE
LIGHTING
PHOTOMETRIC

SHEET NUMBER

SP- 1.2

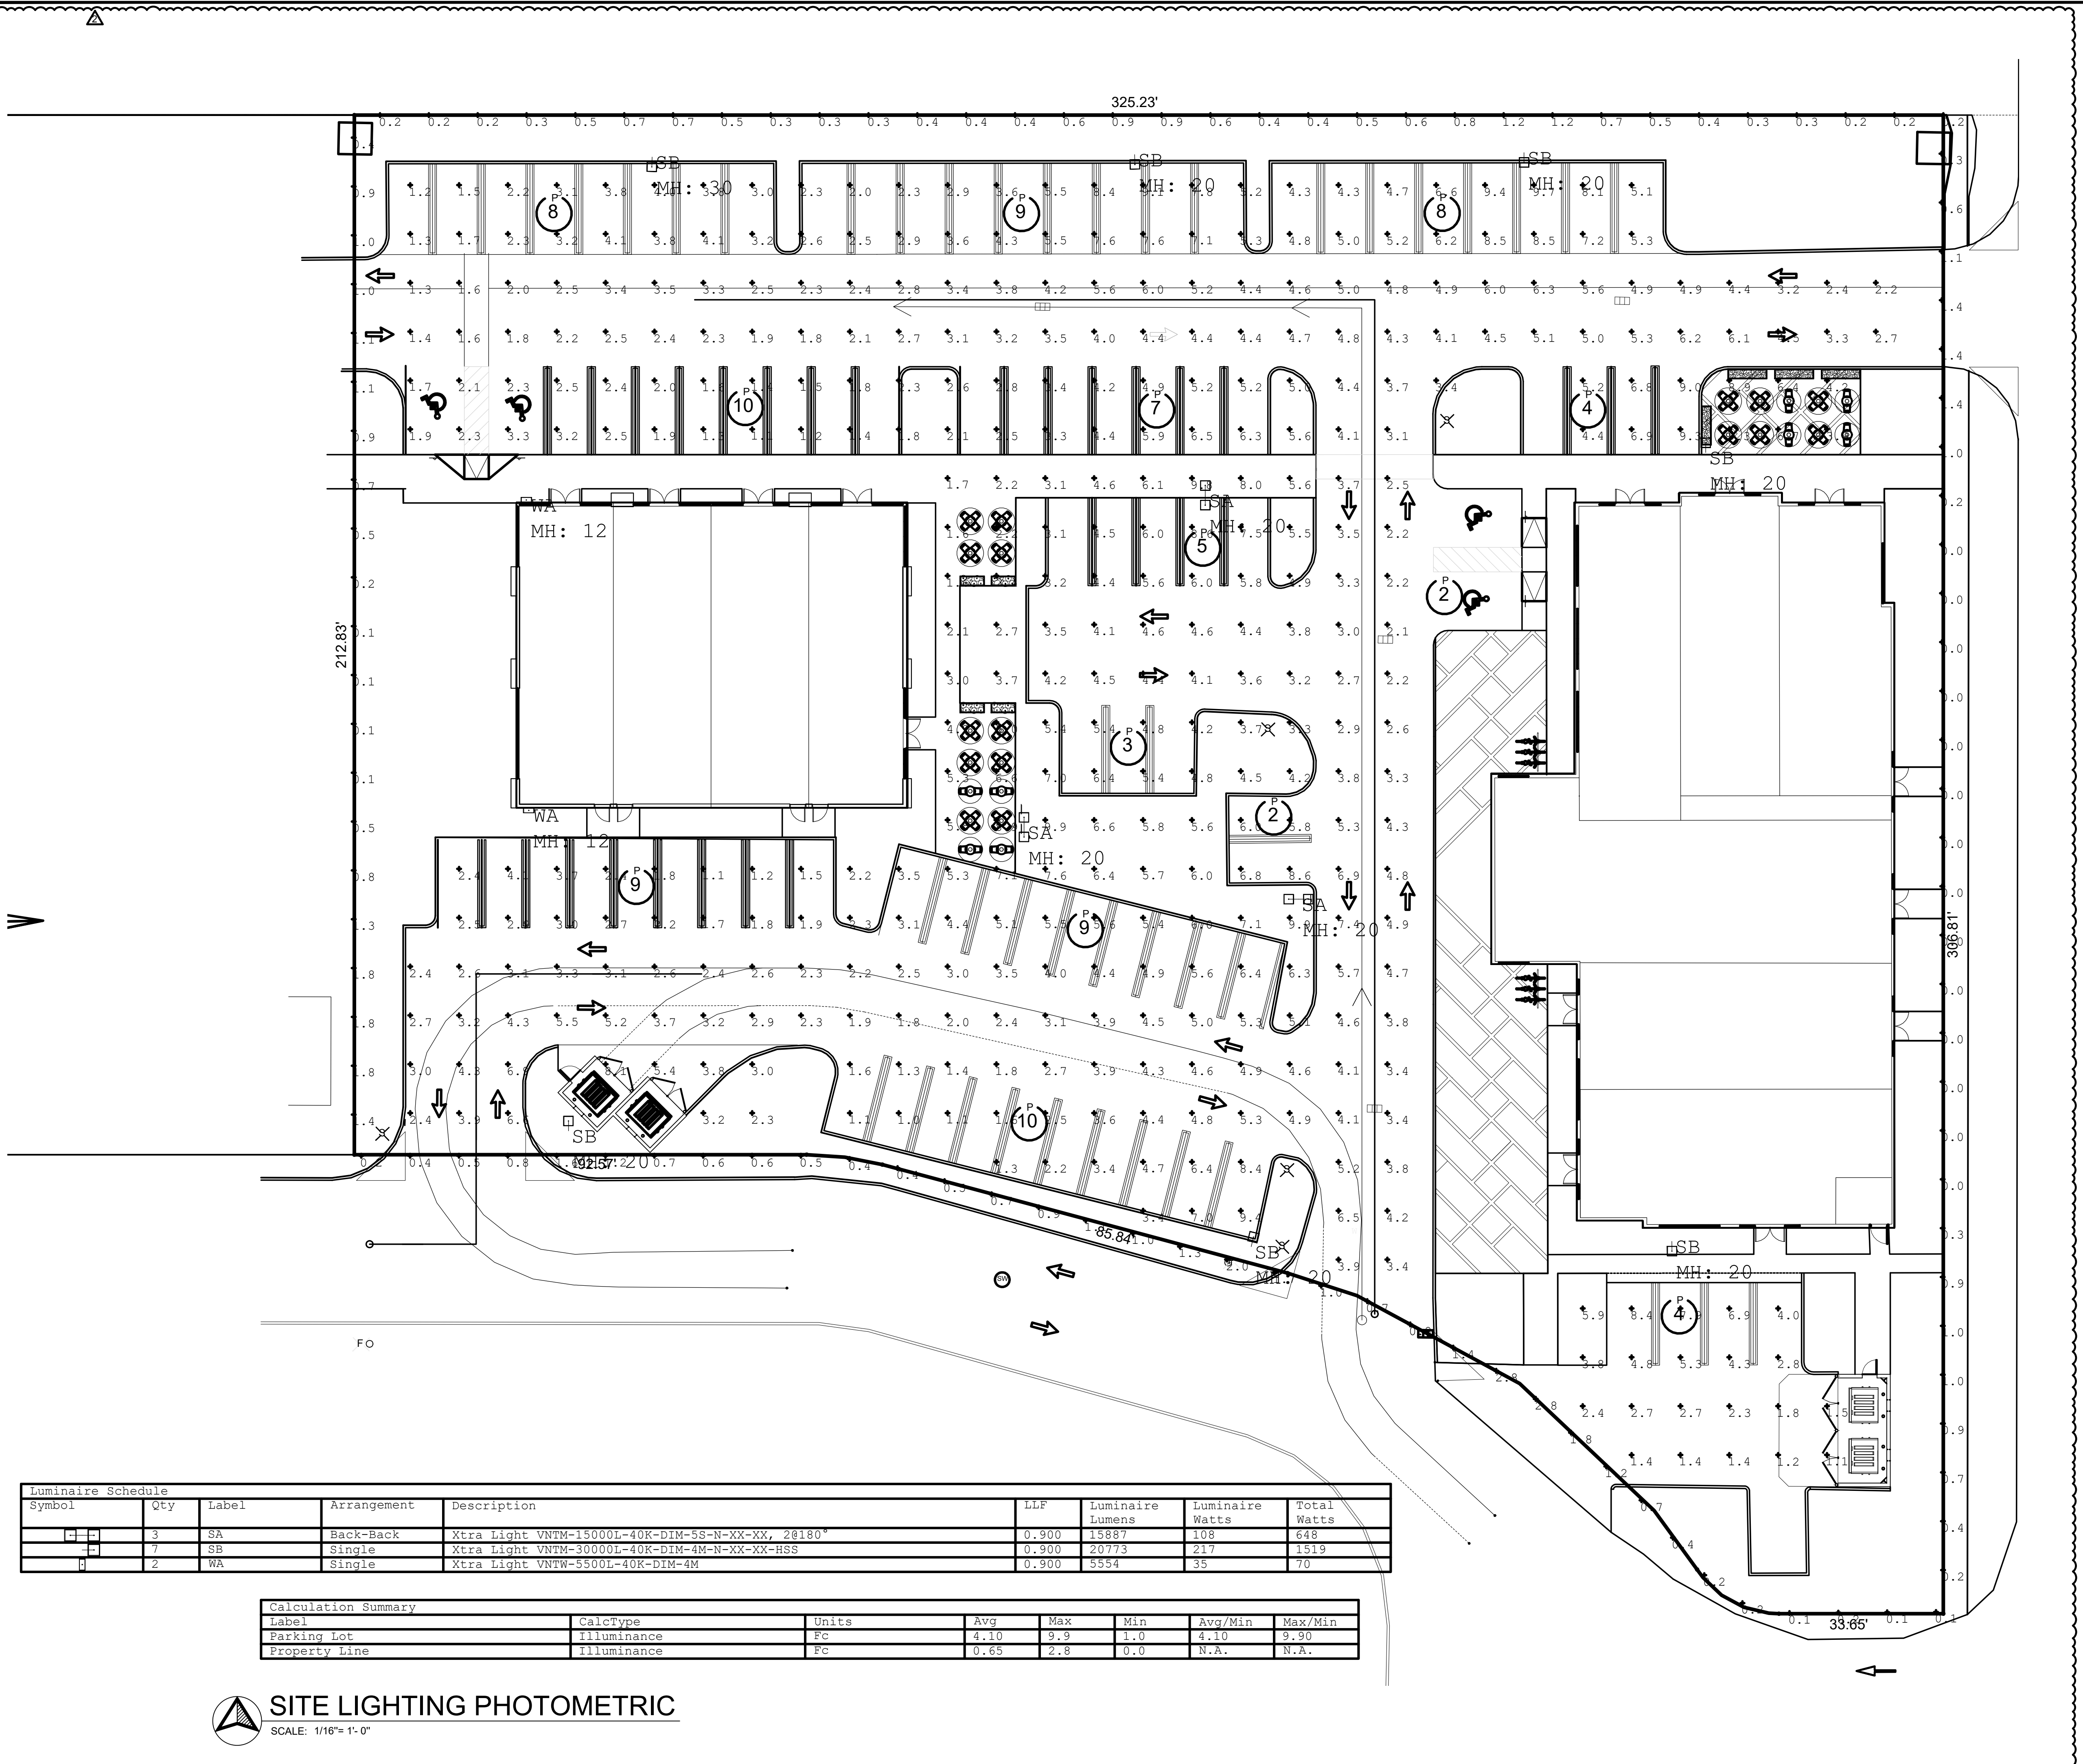

| Luminaire Schedule | | | | | LLF | Luminaire Lumens | Luminaire Watts | Total Watts |
|--------------------|-----|-------|-------------|---|-------|------------------|-----------------|-------------|
| Symbol | Qty | Label | Arrangement | Description | | | | |
| | 3 | SA | Back-Back | Xtra Light VNTM-15000L-40K-DIM-5S-N-XX-XX, 2@180° | 0.900 | 15887 | 108 | 648 |
| | 7 | SB | Single | Xtra Light VNTM-30000L-40K-DIM-4M-N-XX-XX-HSS | 0.900 | 20773 | 217 | 1519 |
| | 2 | WA | Single | Xtra Light VNTM-5500L-40K-DIM-4M | 0.900 | 5554 | 35 | 70 |

| Calculation Summary | | | | | | | | |
|---------------------|-------------|-------|------|-----|-----|---------|---------|--|
| Label | CalcType | Units | Avg | Max | Min | Avg/Min | Max/Min | |
| Parking Lot | Illuminance | Fc | 4.10 | 9.9 | 1.0 | 4.10 | 9.90 | |
| Property Line | Illuminance | Fc | 0.65 | 2.8 | 0.0 | N.A. | N.A. | |

SITE LIGHTING PHOTOMETRIC
SCALE: 1/16"= 1'- 0"