



CHRISTOPHER W. THOMPSON ET AL. 333

This item has been digitally signed and sealed by Craig W. Thompson, P.E. on the date adjacent to the seal. Signature must be verified on any electronic copies.

LUMINAIRE SCHEDULE							
SYMBOL	LABEL	DESCRIPTION	LLF	LUMINAIRE LUMENS	LUMINAIRE WATTS	MANUFACTURER	MOUNTING HEIGHT
	A	RL412-550L-DMTR-120-5CCT-80-WH	0.950	612	8.00879	ELITE	9
	B	623-9LED14-30K	0.950	897	9.6	INDESSA LIGHTING	8

CALCULATION SUMMARY						
LABEL	UNITS	AVG	MAX	MIN	AVG/MIN	MAX/MIN
PROPERTY LINE	Fc	0.62	3.3	0.0	N.A.	N.A.
SITF	Fc	1.36	6.7	0.0	N.A.	N.A.

Client: **RIVER DEV, LLC**  
Project: **RIVERSIDE TOWNHOMES**  
Address: **117 S RIVERSIDE DRIVE,  
POMPANO BEACH, FL, 33062**

Job No: \_\_\_\_\_  
 Drawn By: \_\_\_\_\_  
 Scale: **AS SHOWN**  
 Date: **05-16-2025**

**ARCH  
TEK**


4001 N Ocean Boulevard #B704  
Boca Raton, FL 33431

Architect:

[illegible]

PHOTOMETRIC  
SITE PLAN -  
ELECTRICAL

E-102

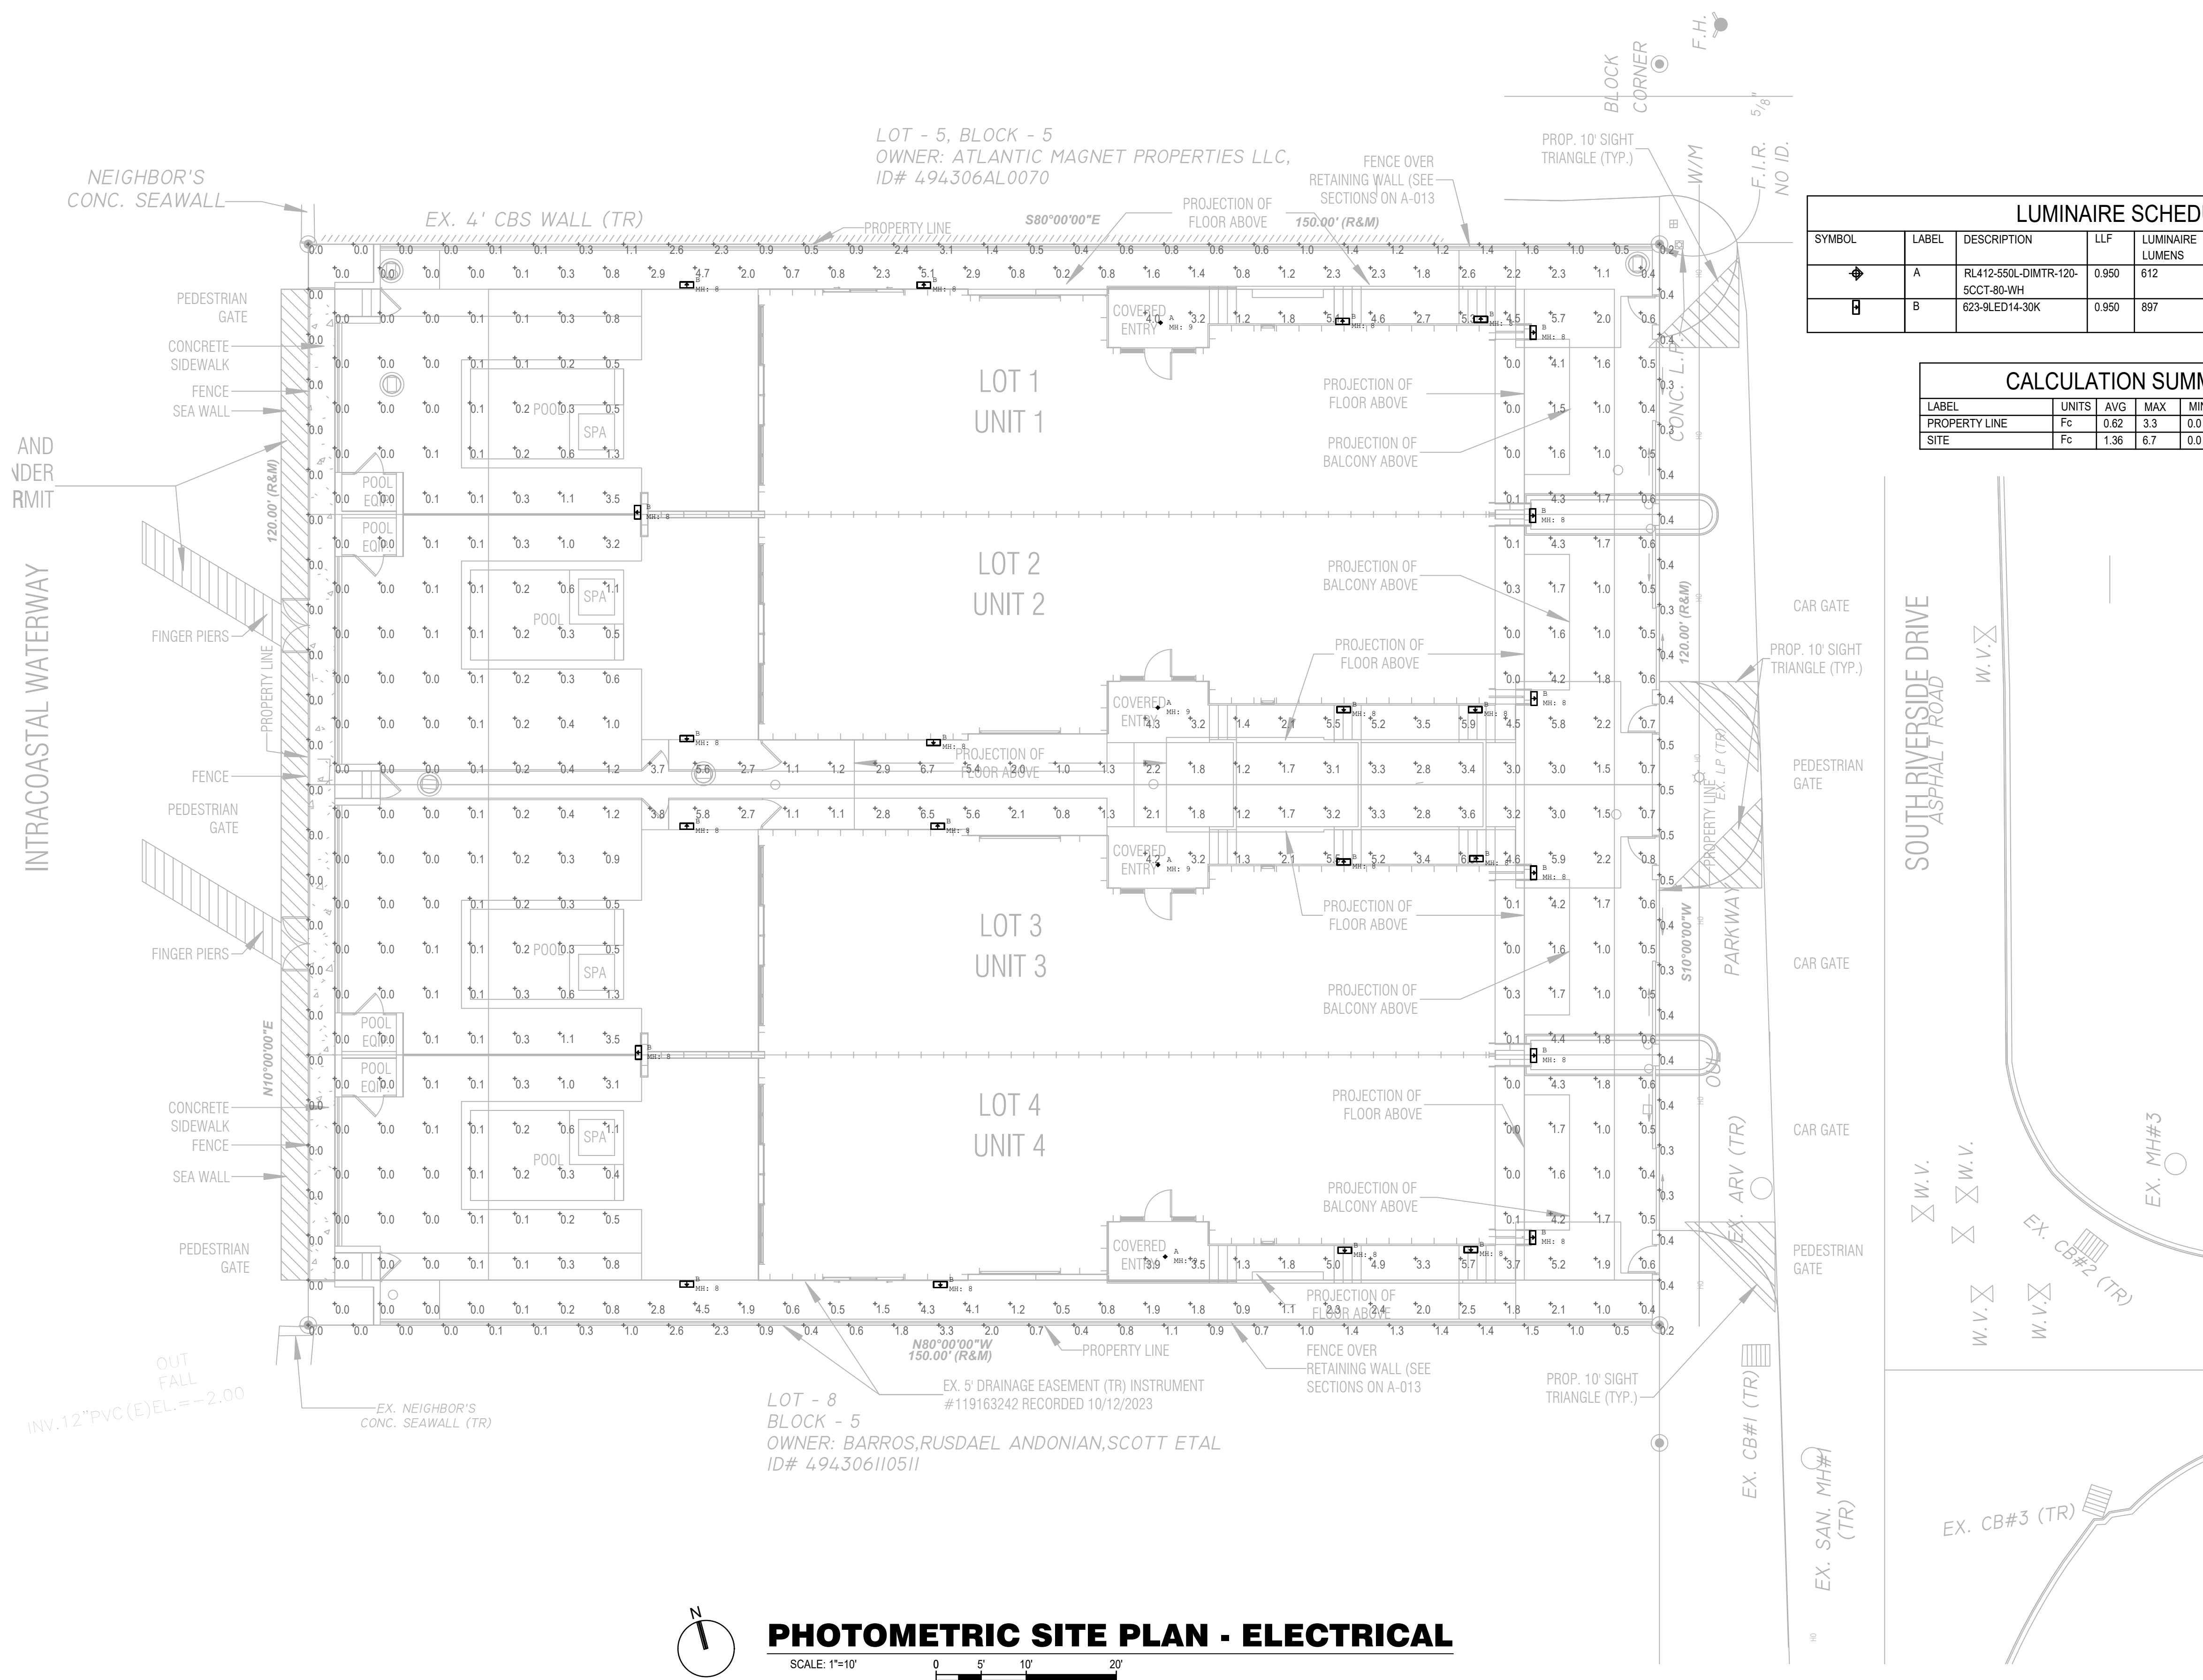

## PHOTOMETRIC SITE PLAN - ELECTRICAL

SCALE: 1"=10'

**SGM**  
ENGINEERING

**935 LAKE BALDWIN LANE  
ORLANDO, FL. 32814  
TEL: 407-767-5188  
FAX: 407-767-5772  
CA-00006208**

WWW.SGMENGINEERING.COM

SGM #: 2024-413 COPYRIGHT © 2022 SGM ENGINEERING, INC