



PROPOSED AREA FOR ROOFTOP MECHANICAL UNITS  
ROOFTOP MECHANICAL EQUIPMENT SCREEN: PROVIDE  
ALUMINUM OR GALVANIZED STEEL LOUVERED SCREEN  
SYSTEM, HURRICANE RATED PER FBC WIND LOAD  
REQUIREMENTS. SCREEN HEIGHT TO FULLY CONCEAL ROOF  
TOP EQUIPMENT ( +/- 6'-6" ) FROM ALL PUBLIC VANTAGE  
POINTS

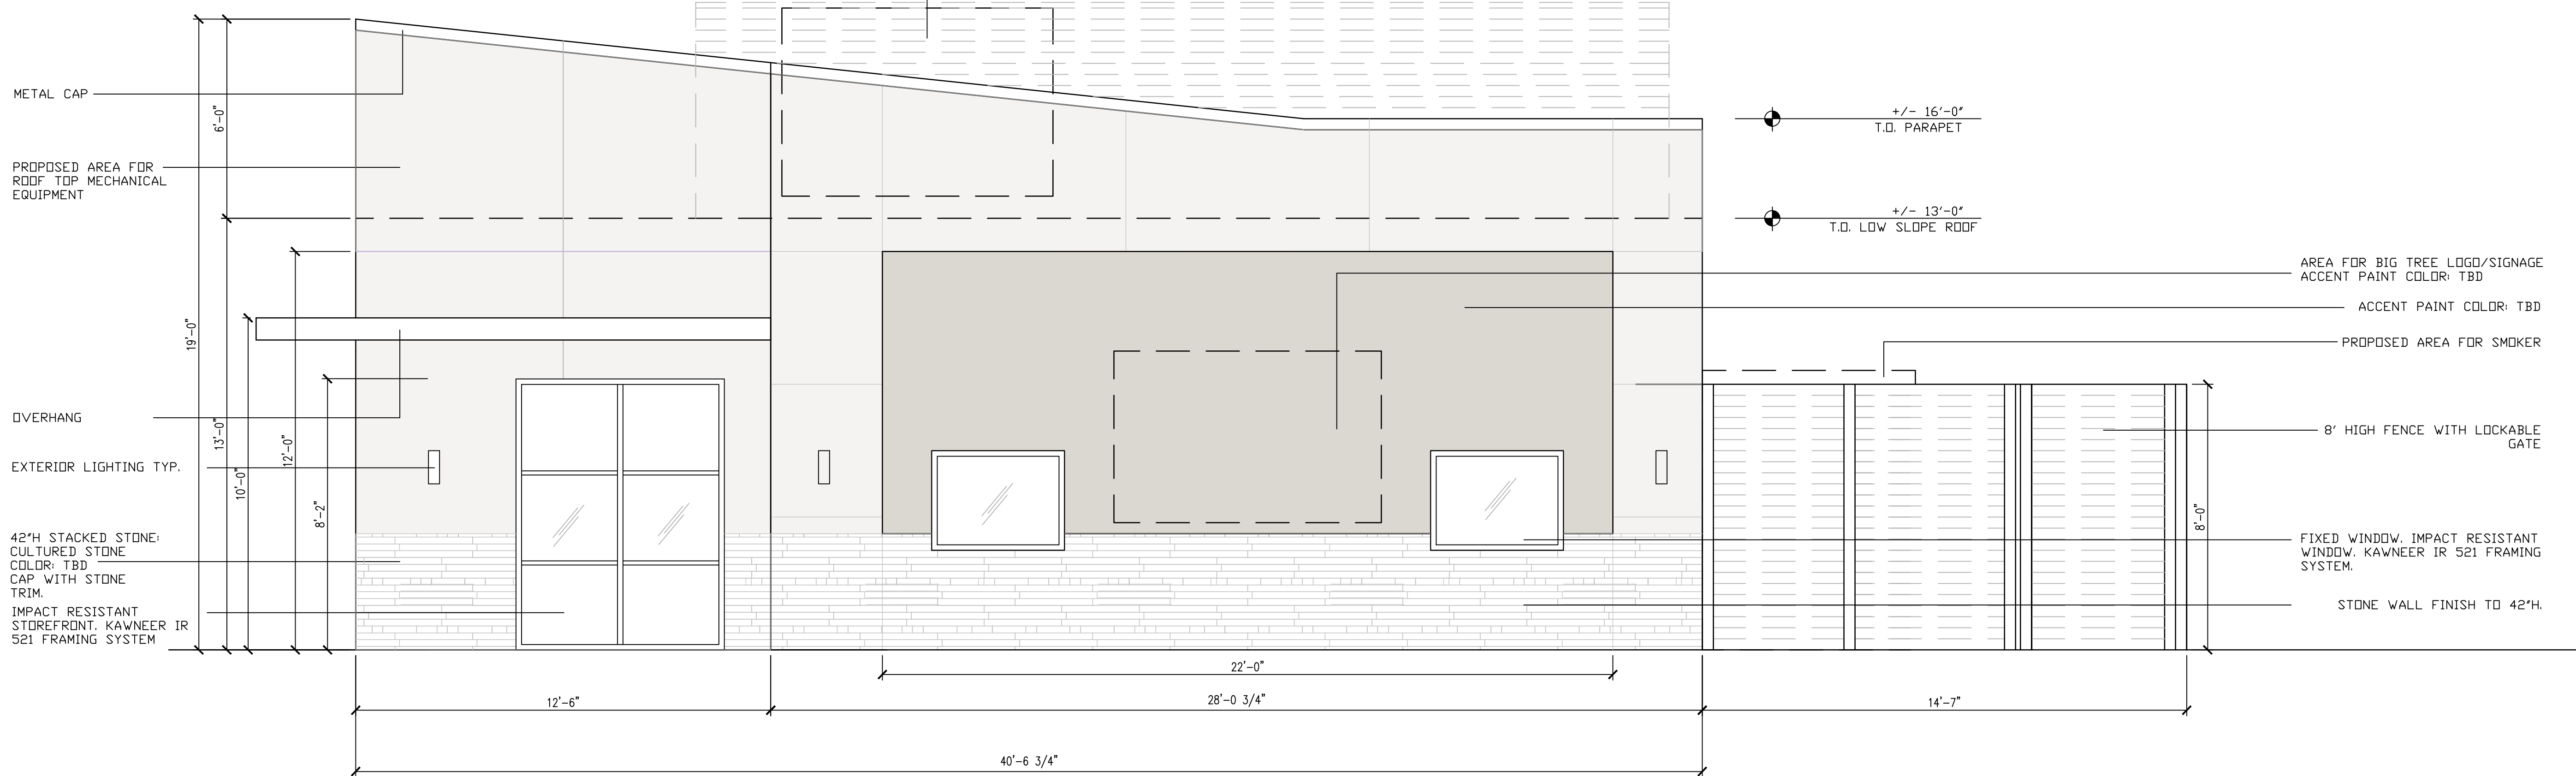

01

## WEST EXTERIOR ELEVATION

1/2" = 1'-0"

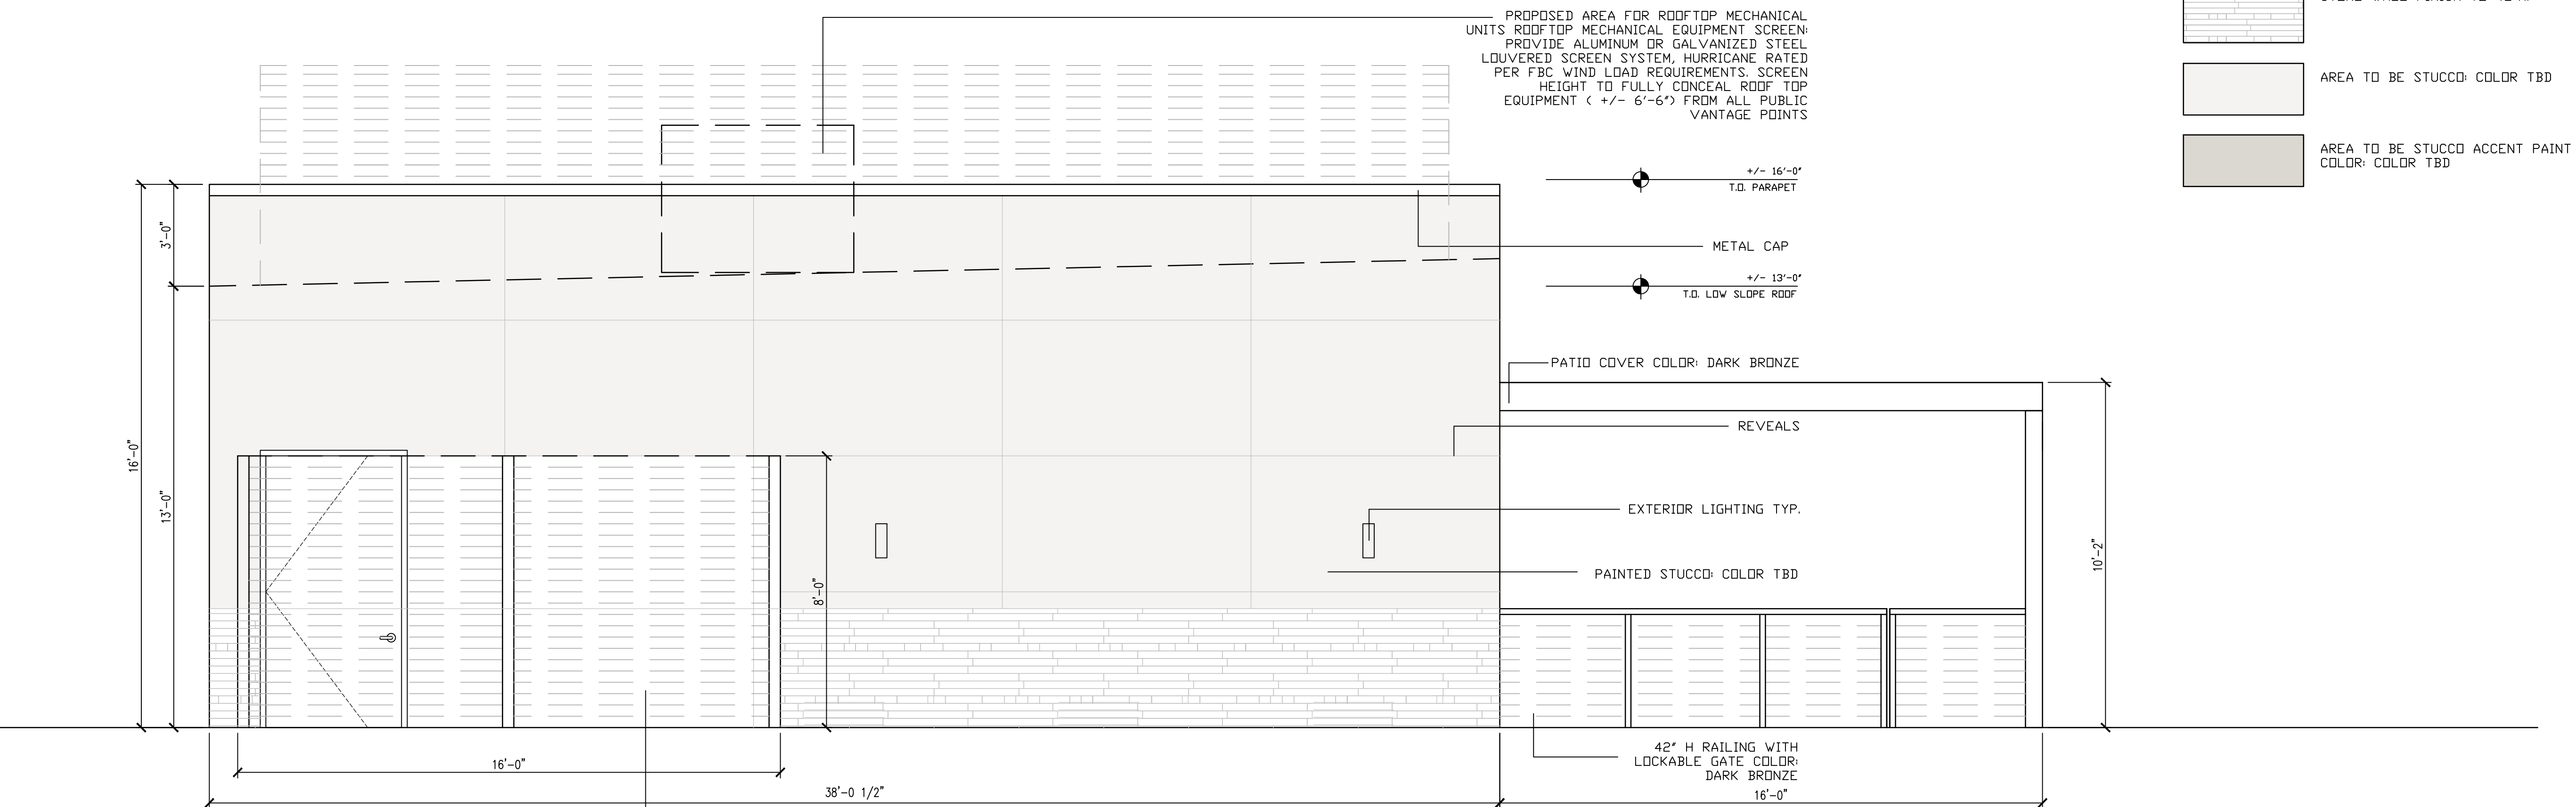

02

## SOUTH EXTERIOR ELEVATION

1/2" = 1'-0"

STUDIO US  
[ DESIGN ]

361 N UNIVERSITY DRIVE  
PLANTATION, FLORIDA 33324


BIG TREE BBQ  
NW 5TH STREET  
POMPANO BEACH, FLORIDA 33069

### REVISIONS

No.	DATE	DESCRIPTION

### CONSTRUCTION DOCUMENTS

PROJECT NUMBER: 2023-16
ISSUE DATE:
DRAWN BY: SNB
CHECKED BY: SNB
FILENAME: 2023-16 BIG TREE BBQ

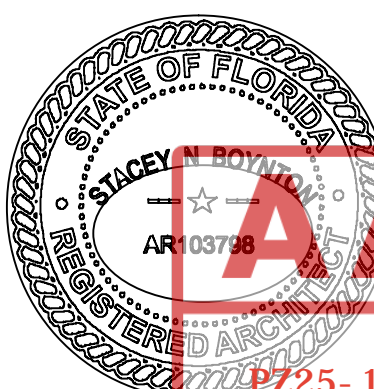

A-3.1  
SHEET

PZ25-12000012  
02/03/2026