




1 SITE LIGHTING PLAN
SCALE: 1/32" = 1'-0" (24 x 36 sheet)

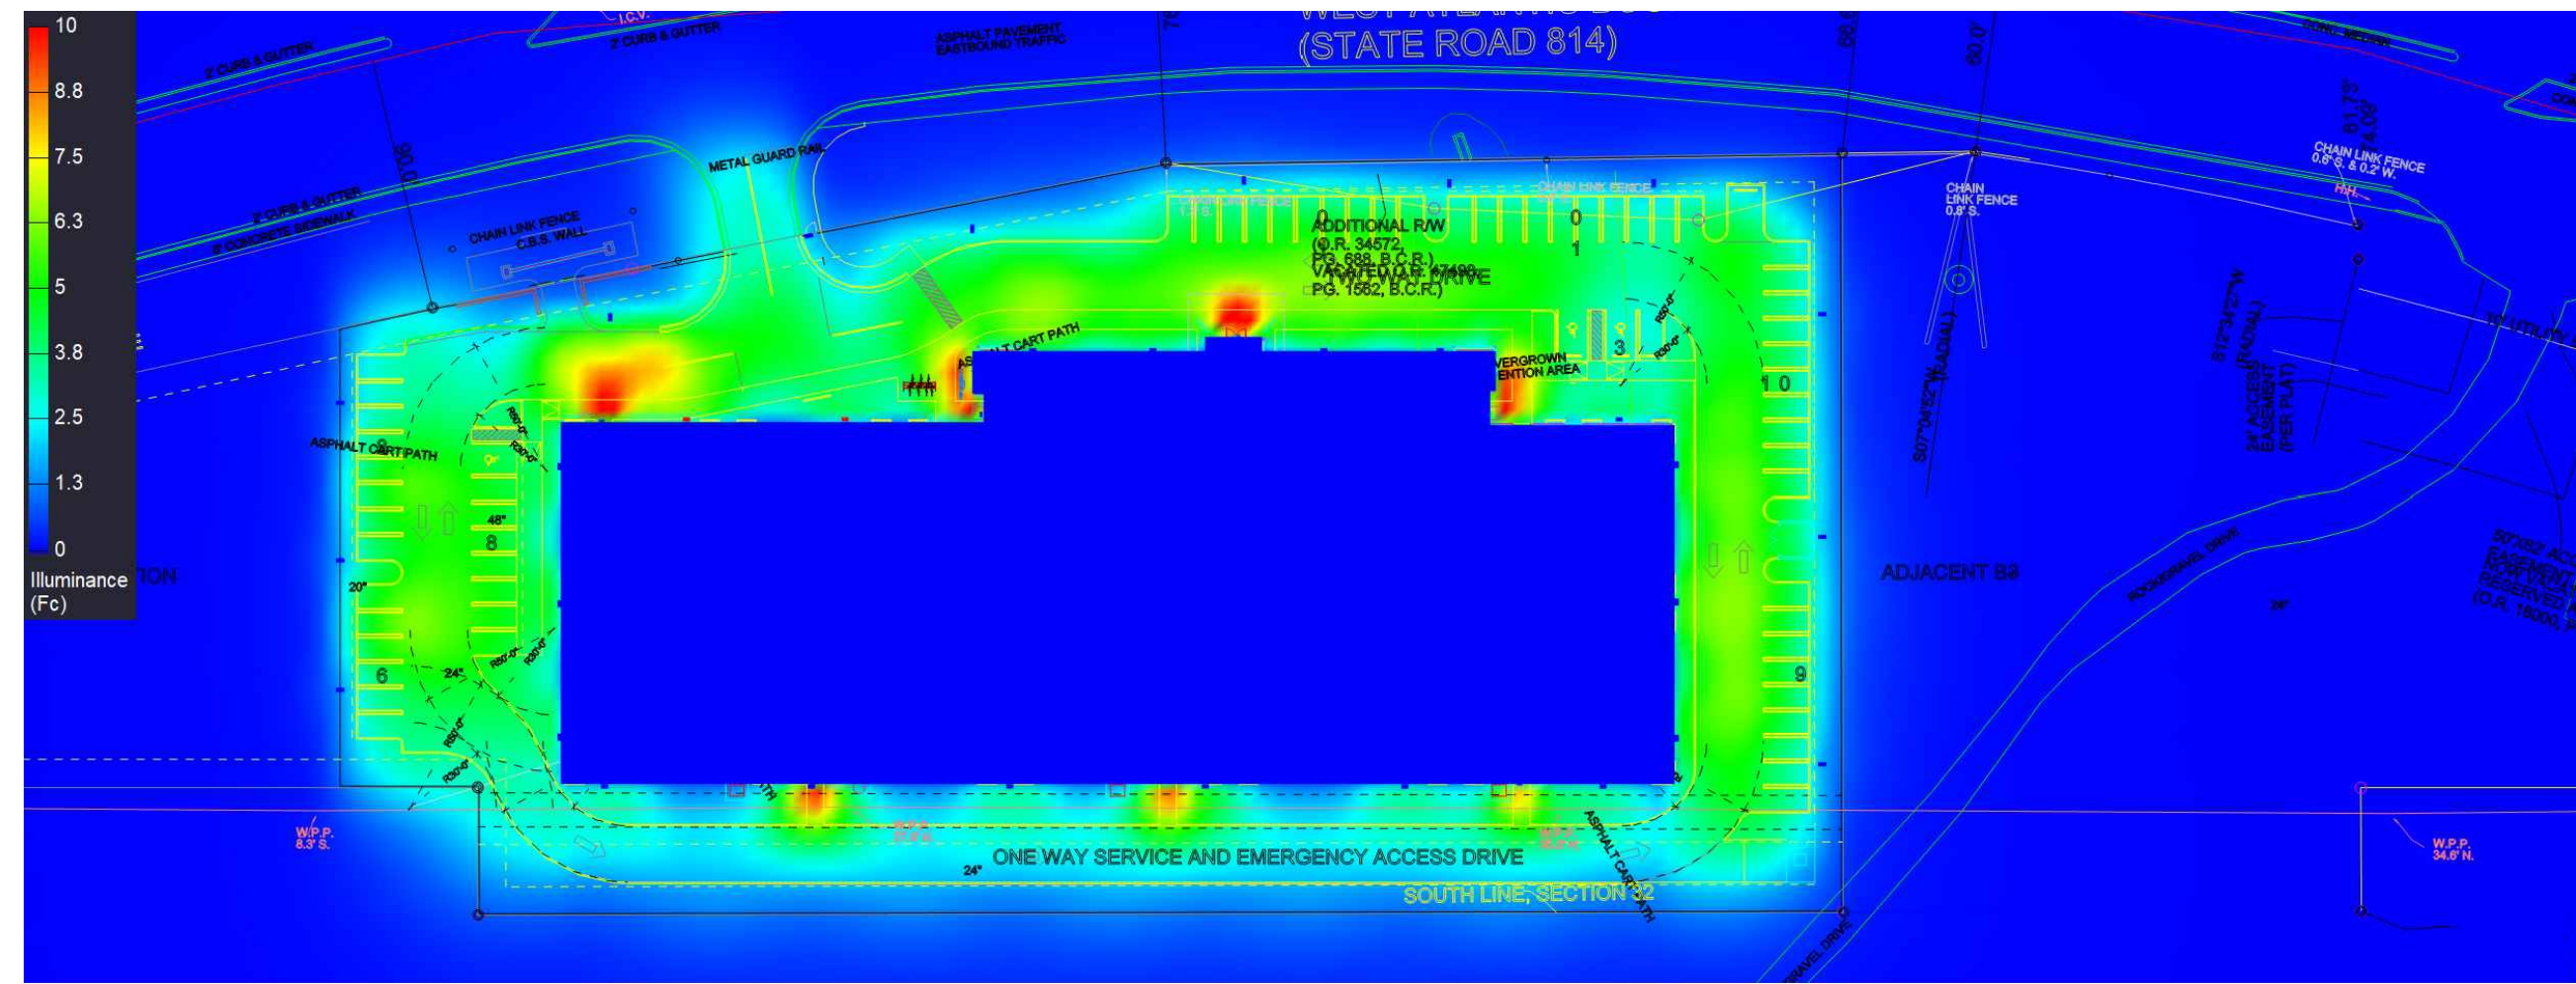

2 PSEUDO COLOR PLAN VIEW RENDERING
SCALE: NTS

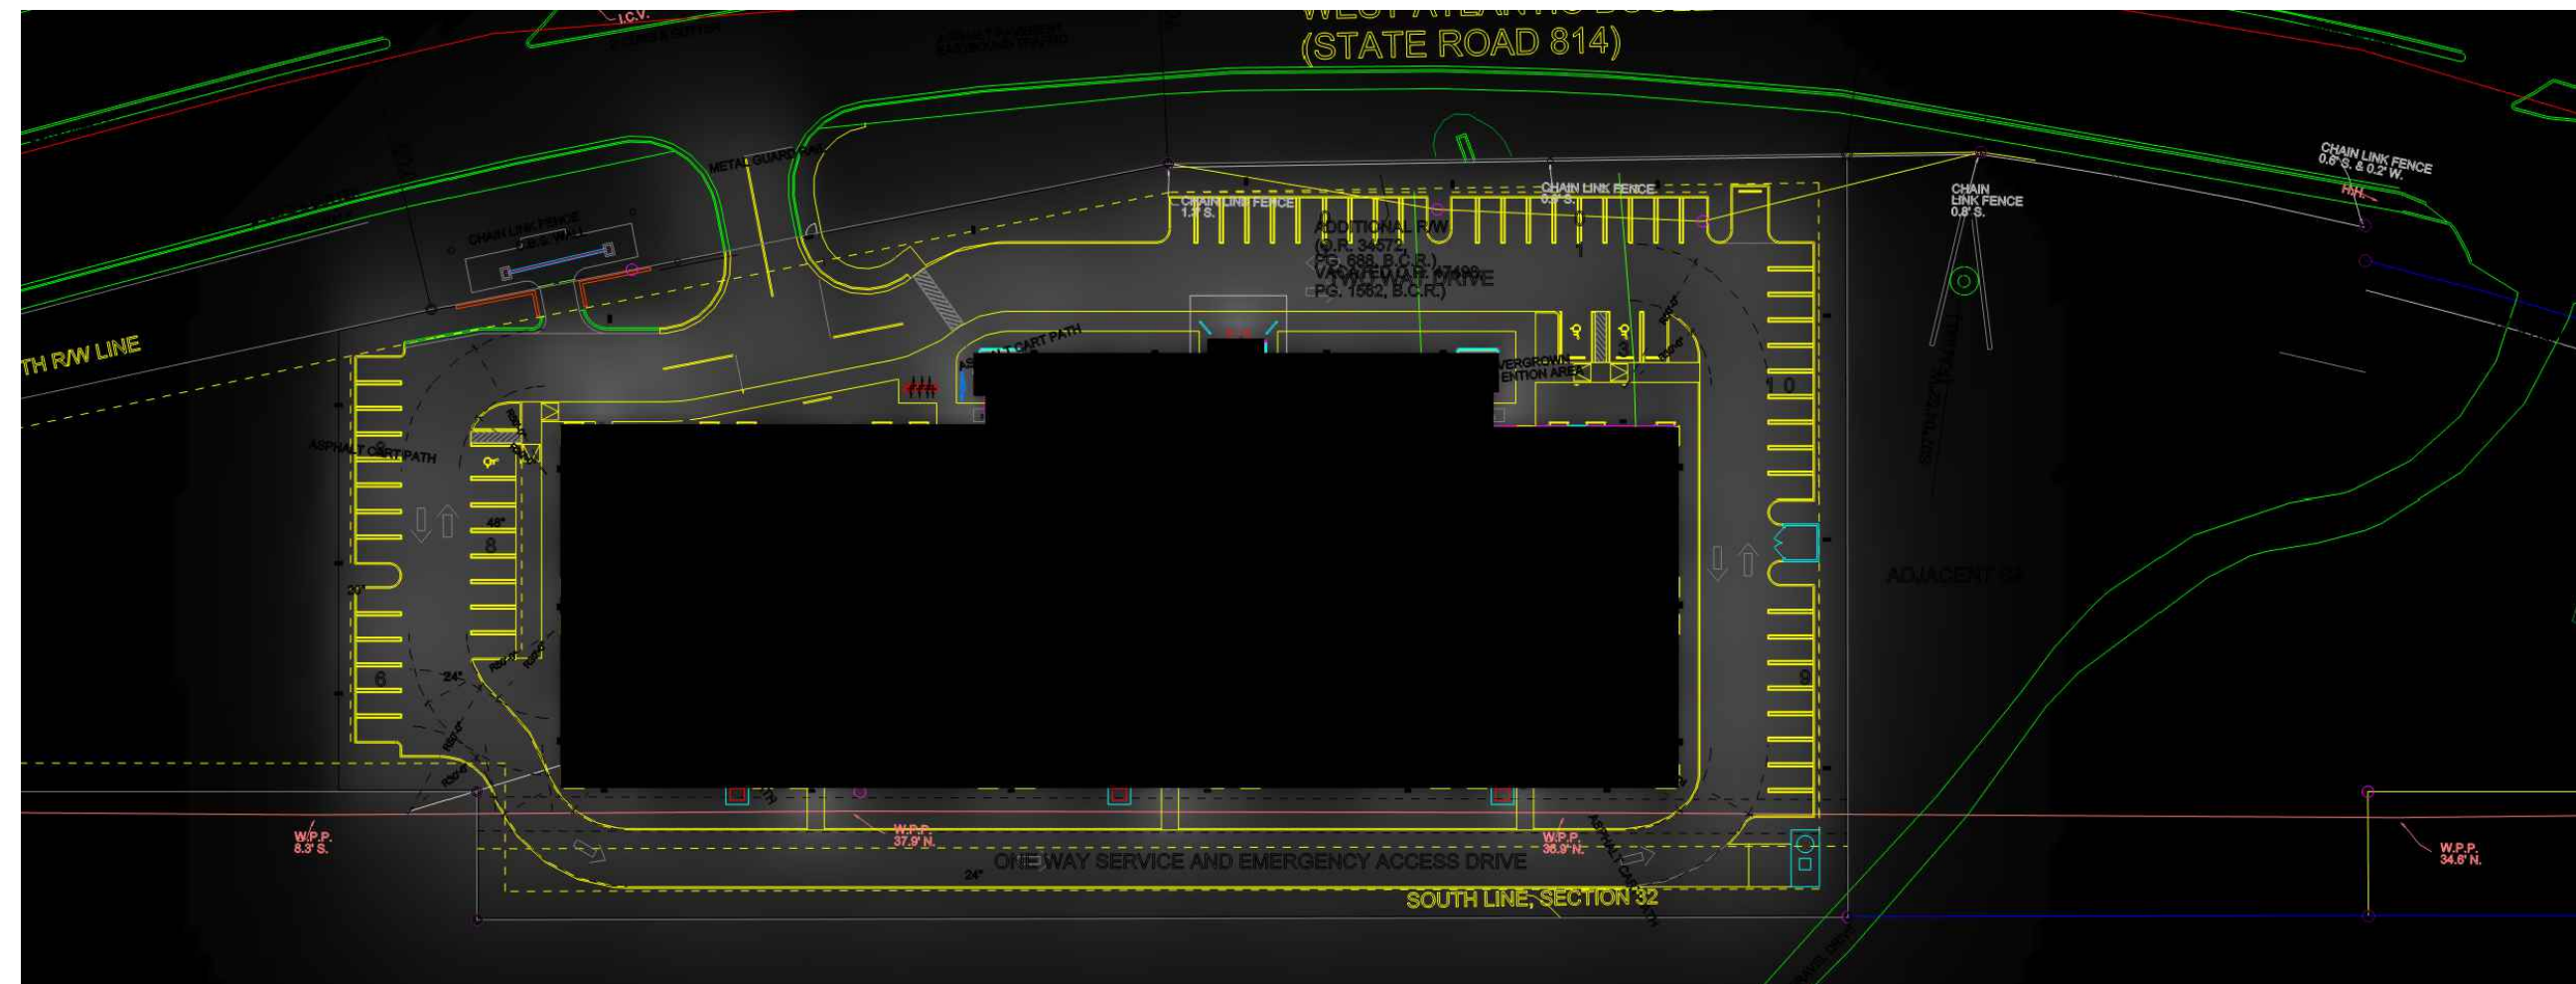

3 GRAYSCALE PLAN VIEW RENDERING
SCALE: NTS

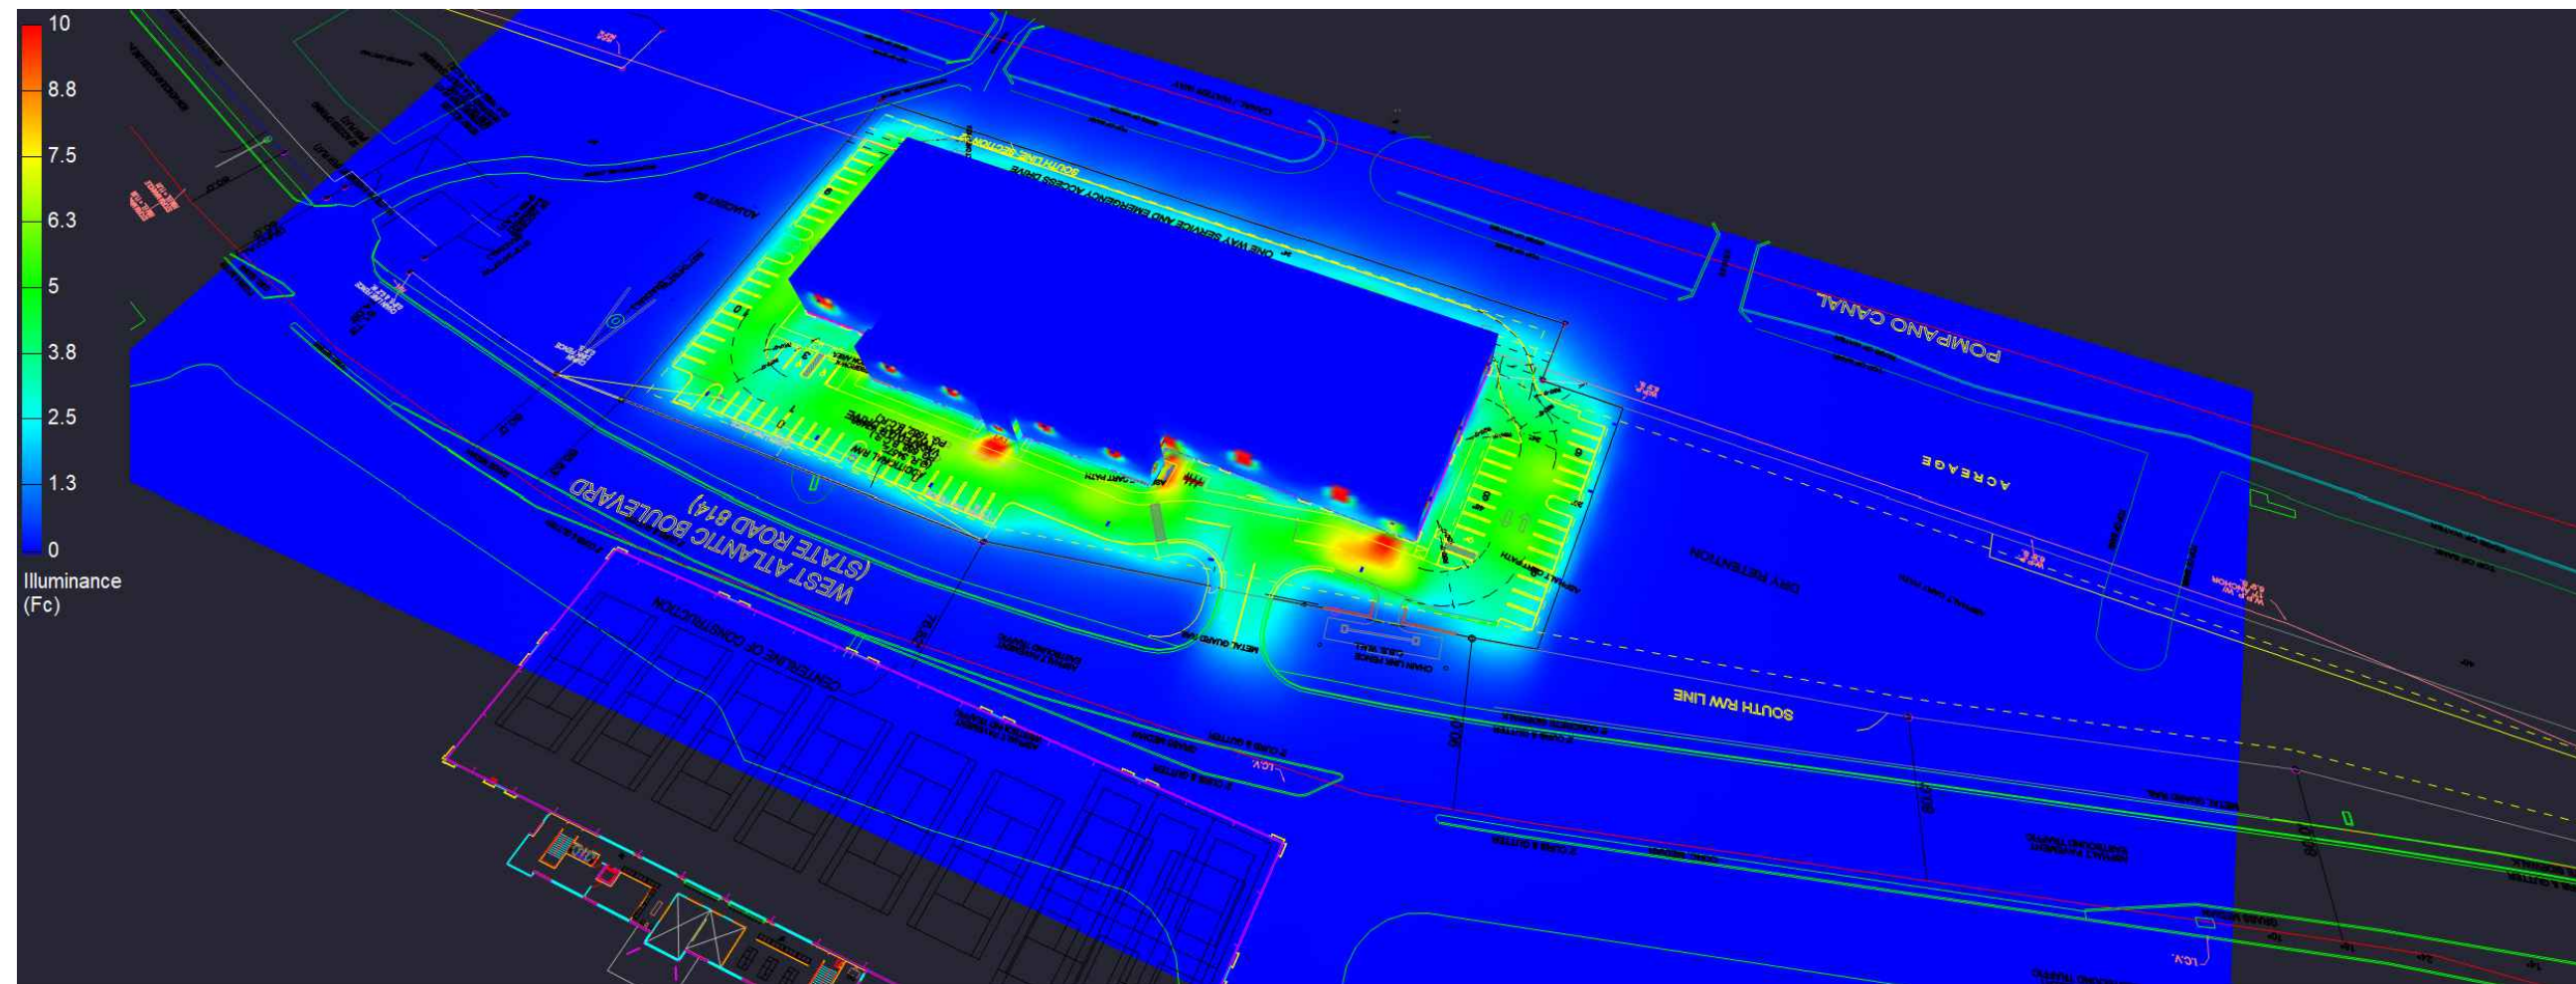

4 ISOMETRIC PSEUDO COLOR RENDERING
SCALE: NTS

National Lighting Program Vendor
For pricing and technical assistance contact:
CBMC INC
317-626-1590
Pete Miller - Program Manager- pmiller@cbmcinc.com
Jennifer Karesh-Project Manager - jkaresh@cbmcinc.com
William Proctor - Project Engineer - wproctor@cbmcinc.com

DRAWING INDEX:
SL1: SITE LIGHTING PLAN AND RENDERINGS
SL2: PHOTOMETRY
SL3: LIGHTING CONTROLS AND DETAILS

All electrical work shall comply with National, State, and Local codes including and not limited to the National Electric Code, NEPA 101 Life Safety Code, ASHREA and/or IECC Energy Codes.
The information contained in this document is proprietary to CBMC Lighting Solutions. This document is prepared for a specific site and incorporates calculations based on data available from the client at the time of preparation. Any use of this document for any other purpose without the written permission of CBMC Lighting Solutions is prohibited. The contents of this document are not to be reproduced in whole or in part without the written permission of CBMC Lighting Solutions. Copyright © 2023 CBMC Lighting Solutions all rights reserved.

CBMC LIGHTING SOLUTIONS
5855 KOPETSKY DR. SUITE G. | INDIANAPOLIS, IN 46217
317-780-8350 | WWW.CBMCINC.COM

SEE MORE

This lighting pattern represents illumination levels calculated from laboratory data taken under controlled conditions in accordance with IESNA approved methods. Actual performance of any manufacturer's luminaire may vary due to variation in electrical voltage, tolerance in lamps and LED lumen package, location adjustments, and other variable field conditions.

Contractor to check and verify all dimensions on site before commencing any work shown.

RWB Linares ARCHITECTURE
1600 SOUTH DIXIE HWY., SUITE 400
BOCA RATON, FLORIDA 33432
PHONE 561-391-0081 FAX 561-391-0085
EMAIL mail@rwb-arch.com

FLORIDA INDOOR TENNIS
Lighting Plan & Renderings
POMPANO BEACH, FLORIDA

| | | | | |
|-------------|---------|-------------|---------------|----------|
| Scale: | NTS | Project No: | 0823498-SL-R1 | Revision |
| Date: | 12/7/23 | Drawing No: | | |
| Drawn By: | WP | | | |
| Checked By: | PM / JK | | | |

SL1

1

PZ23-12000009
01/17/2024