


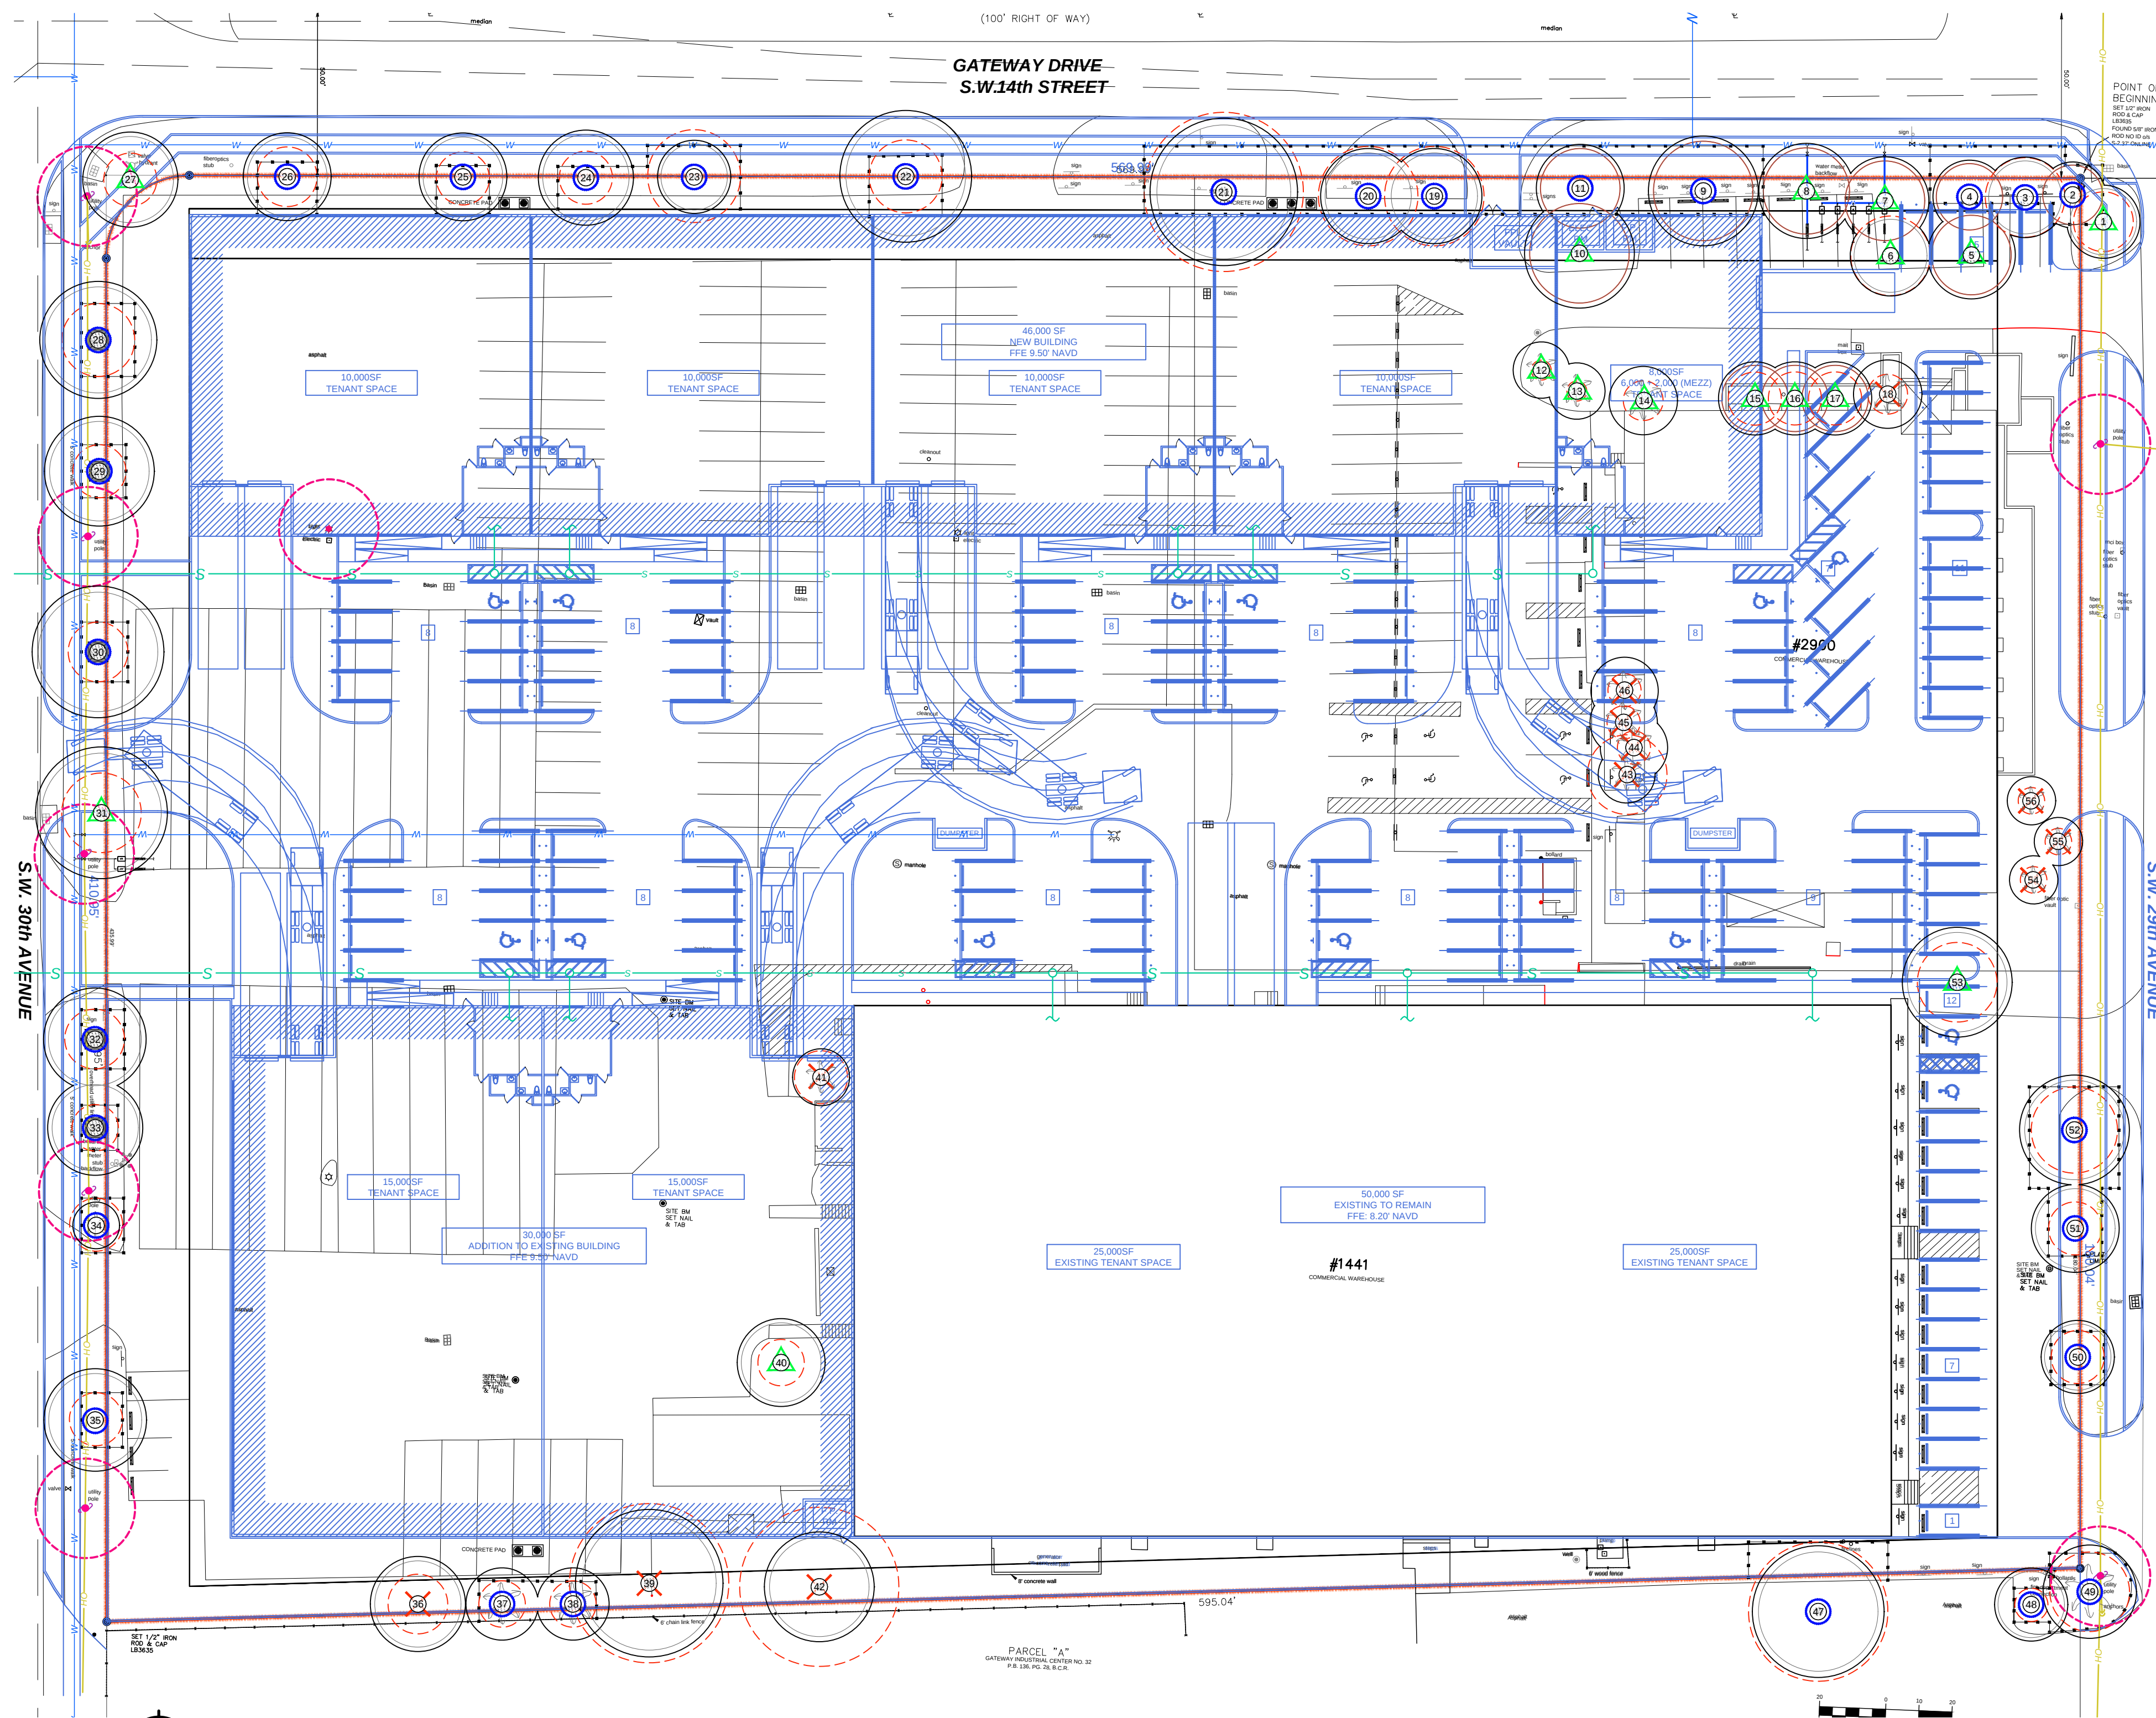


EXISTING TREE DISPOSITION PLAN

SCALE: 0 8 16 24 feet




1/8" = 1'-0"

 
TREE DISPOSITION LEGEND



 
Existing tree or palm to be transplanted



Existing tree or palm to be removed

 

Existing tree and palm to remain in their existing location and be protected during construction, no construction or excavation shall be permitted within the dripline of the trees.

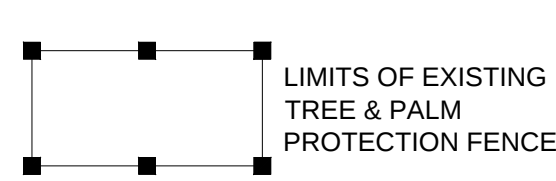

LIMITS OF EXISTING TREE & PALM PROTECTION FENCE



PROPOSED BUILDING & PAVED AREAS



TREE PROTECTION ZONE

EXISTING TREE DISPOSITION LIST													
No.	Scientific Name	Common Name	DBH (in)	Height (ft)	Canopy (ft)	TPZ Radius (ft)	CRZ Radius (ft)	PALM CT (ft)	Specimen *	Condition (%)	Disposition	Mitigation required Tree Canopy Lost (SQ.FT)	Tree Bond value (ft to Remain or Relocate)
1	Swietenia mahagoni	Mahogany	13	24	22	8	6			30%	Relocate		
2	Swietenia mahagoni	Mahogany	16	24	19	10	5			30%	Relocate		
3	Swietenia mahagoni	Mahogany	30	41	43	16	8		Yes	40%	Relocate		
4	Swietenia mahagoni	Mahogany	23	42	39	15	8		Yes	30%	Relocate		
5	Swietenia mahagoni	Mahogany	29	43	45	18	9		Yes	20%	Relocate		
6	Swietenia mahagoni	Mahogany	23	41	38	12	8		Yes	40%	Relocate		
7	Swietenia mahagoni	Mahogany	20	40	39	12	8		Yes	70%	Relocate		\$ 4,013
8	Swietenia mahagoni	Mahogany	24	41	39	14	8		Yes	40%	Relocate		
9	Swietenia mahagoni	Mahogany	28	49	48	16	9		Yes	30%	Relocate		
10	Swietenia mahagoni	Mahogany	25	39	38	14	8		Yes	40%	Relocate		
11	Swietenia mahagoni	Mahogany	35	43	55	18	12		Yes	50%	Relocate		
12	Sabal palmetto	Cabbage palm	7	26	16	4	2	18		80%	Relocate		
13	Sabal palmetto	Cabbage palm	7	26	16	4	2	18		80%	Relocate		
14	Sabal palmetto	Cabbage palm	16	26	16	4	2	18		80%	Relocate		
15	Swietenia mahagoni	Mahogany	20	39	36	15	8		Yes	70%	Relocate		\$ 4,013
16	Swietenia mahagoni	Mahogany	18	44	42	12	8		Yes	70%	Relocate		\$ 3,612
17	Swietenia mahagoni	Mahogany	19	51	42	12	8		Yes	70%	Relocate		\$ 3,812
18	Swietenia mahagoni	Mahogany	20	-	-	-	-			0%	Remove	0	
19	Swietenia mahagoni	Mahogany	20	34	39	12	8		Yes	70%	Relocate		\$ 4,013
20	Swietenia mahagoni	Mahogany	21	41	36	12	8		Yes	70%	Relocate		\$ 4,214
21	Swietenia mahagoni	Mahogany	31	39	39	18	12		Yes	40%	Relocate		
22	Bucida buceras	Black olive	19	36	39	12	8		Yes	70%	Relocate		\$ 3,058
23	Bucida buceras	Black olive	8	26	24	6	4			70%	Relocate		
24	Quercus virginiana	Live oak	14	32	26	8	6			70%	Relocate		
25	Quercus virginiana	Live oak	14	29	36	8	6			70%	Relocate		
26	Quercus virginiana	Live oak	16	29	39	10	6			70%	Relocate		
27	Quercus virginiana	Live oak	16	29	39	10	6			70%	Relocate		
28	Quercus virginiana	Live oak	19	26	34	10	6		Yes	70%	Relocate		\$ 3,716
29	Quercus virginiana	Live oak	12	25	34	8	6			70%	Relocate		
30	Quercus virginiana	Live oak	16	26	34	10	6			70%	Relocate		
31	Quercus virginiana	Live oak	19	29	34	12	8		Yes	40%	Relocate		
32	Quercus virginiana	Live oak	14	24	28	8	6			70%	Relocate		
33	Quercus virginiana	Live oak	12	24	29	8	6			60%	Relocate		
34	Sabal palmetto	Cabbage palm	16	18	16	6	4	14		80%	Relocate		
35	Quercus virginiana	Live oak	14	28	34	-	-			0%	Relocate		
36	Acacia auriculiformis	Earleaf Acacia	23	42	39	-	-			0%	Remove	N/A	
37	Sabal palmetto	Cabbage palm	14	23	16	6	4	16		80%	Relocate		
38	Sabal palmetto	Cabbage palm	16	24	16	6	4	16		80%	Relocate		
39	Acacia auriculiformis	Earleaf Acacia	26	43	39	-	-			0%	Remove	N/A	
40	Quercus virginiana	Live oak	13	32	36	8	6			70%	Relocate		
41	Sabal palmetto	Cabbage palm	16	24	16	6	4	16		80%	Relocate	201	
42	Acacia auriculiformis	Earleaf Acacia	24	43	39	-	-			0%	Remove	N/A	
43	Sabal palmetto	Cabbage palm	19	26	16	6	4	16	Yes	80%	Remove	201	\$ 587
44	Syagrus romanzoffiana	Queen palm	12	19	22	8	4			70%	Remove	380	
45	Syagrus romanzoffiana	Queen palm	12	22	22	8	4			70%	Remove	380	
46	Syagrus romanzoffiana	Queen palm	12	24	22	8	4			70%	Remove	380	
47	Quercus virginiana	Live oak	24	43	51	16	10		Yes	70%	Relocate		\$ 4,732
48	Quercus virginiana	Live oak	9	24	16	6	4			80%	Relocate		
49	Sabal palmetto	Cabbage palm	14	24	16	6	4	16		80%	Relocate		
50	Bucida buceras	Black olive	14	36	28	8	6			70%	Relocate		
51	Bucida buceras	Black olive	14	36	28	8	6			70%	Relocate		
52	Bucida buceras	Black olive	22	39	31	14	10		Yes	70%	Relocate		\$ 3,500
53	Quercus virginiana	Live oak	19	39	42	12	8		Yes	70%	Relocate		\$ 3,716
54	Sabal palmetto	Cabbage palm	6	24	16	4	2	18		80%	Remove	201	
55	Sabal palmetto	Cabbage palm	6	25	16	4	2	18		80%	Remove	201	
56	Sabal palmetto	Cabbage palm	6	24	16	4	2	18		80%	Remove	201	
Total to be removed and mitigated =												2,146	SQ. FT.

* DBH greater than 18"

NOTES:

- Trees must be protected during the entire project until completion.
- No tree/palm roots or plants shall be cut or damaged due to construction activities on site. If there are any tree/palm root conflicts.
- Tree protection barriers must be installed and inspected prior to final to any site work commencing.
- Visibility and unobstructed working space must be maintained from fire apparatus access routes to fire protection and life safety appliances/equipment. The only landscaping should be grass or mulch no plants or shrubs. These include but not limited to: Fire hydrants, fire department connections (FDC), post indicating valves (PIV), fire sprinkler risers, fire alarm control panels and electrical room locations require a minimum 36-inch clearance path to and on all sides. Fire hydrants require 36-inch clear space each side and rear with a 60-inch wide clear access from the fire apparatus access to fire hydrant. (NFPA 1-2021 Ch. 18 Sec. 18.5.7).
- Pre-Construction meeting with Urban Forestry is required before any plant material is installed on site.
- Irrigation system shall provide 100% coverage with 50% overlap.

ALL LANDSCAPE DATA INC.

DERICK LANGE
Landscape Architect LA66705
www.alllandscapedata.net &
4459 NW 97 CT / Doral, FL 33178
Ph: 305.303.7059



REV# / DESCRIPTION DATE
#2 City Comments 10-03-25

This drawing, as an instrument of service, is and shall remain the property of the Architect and shall not be reproduced, published or used in any way without the permission of the Architect.

WAREHOUSE

1441 S.W. 29th Avenue, Pompano Beach, Florida 33069
2900 Gateway Drive, Pompano Beach, Florida 33069

SEAL

FELIPE A. MARTINEZ
11329 NW 55 Lane
Doral, FL 33118
954 240 3305
PEF 68402

DATE: 10-03-2025

SCALE: AS NOTED

DRAWN BY: ALD

DRAWING #

EXISTING TREE
DISPOSITION
PLAN
L-01