


C:\Users\CAD\Documents\1262 - BASE - Normal.dwg  
3/5/2024 4:28:38 PM

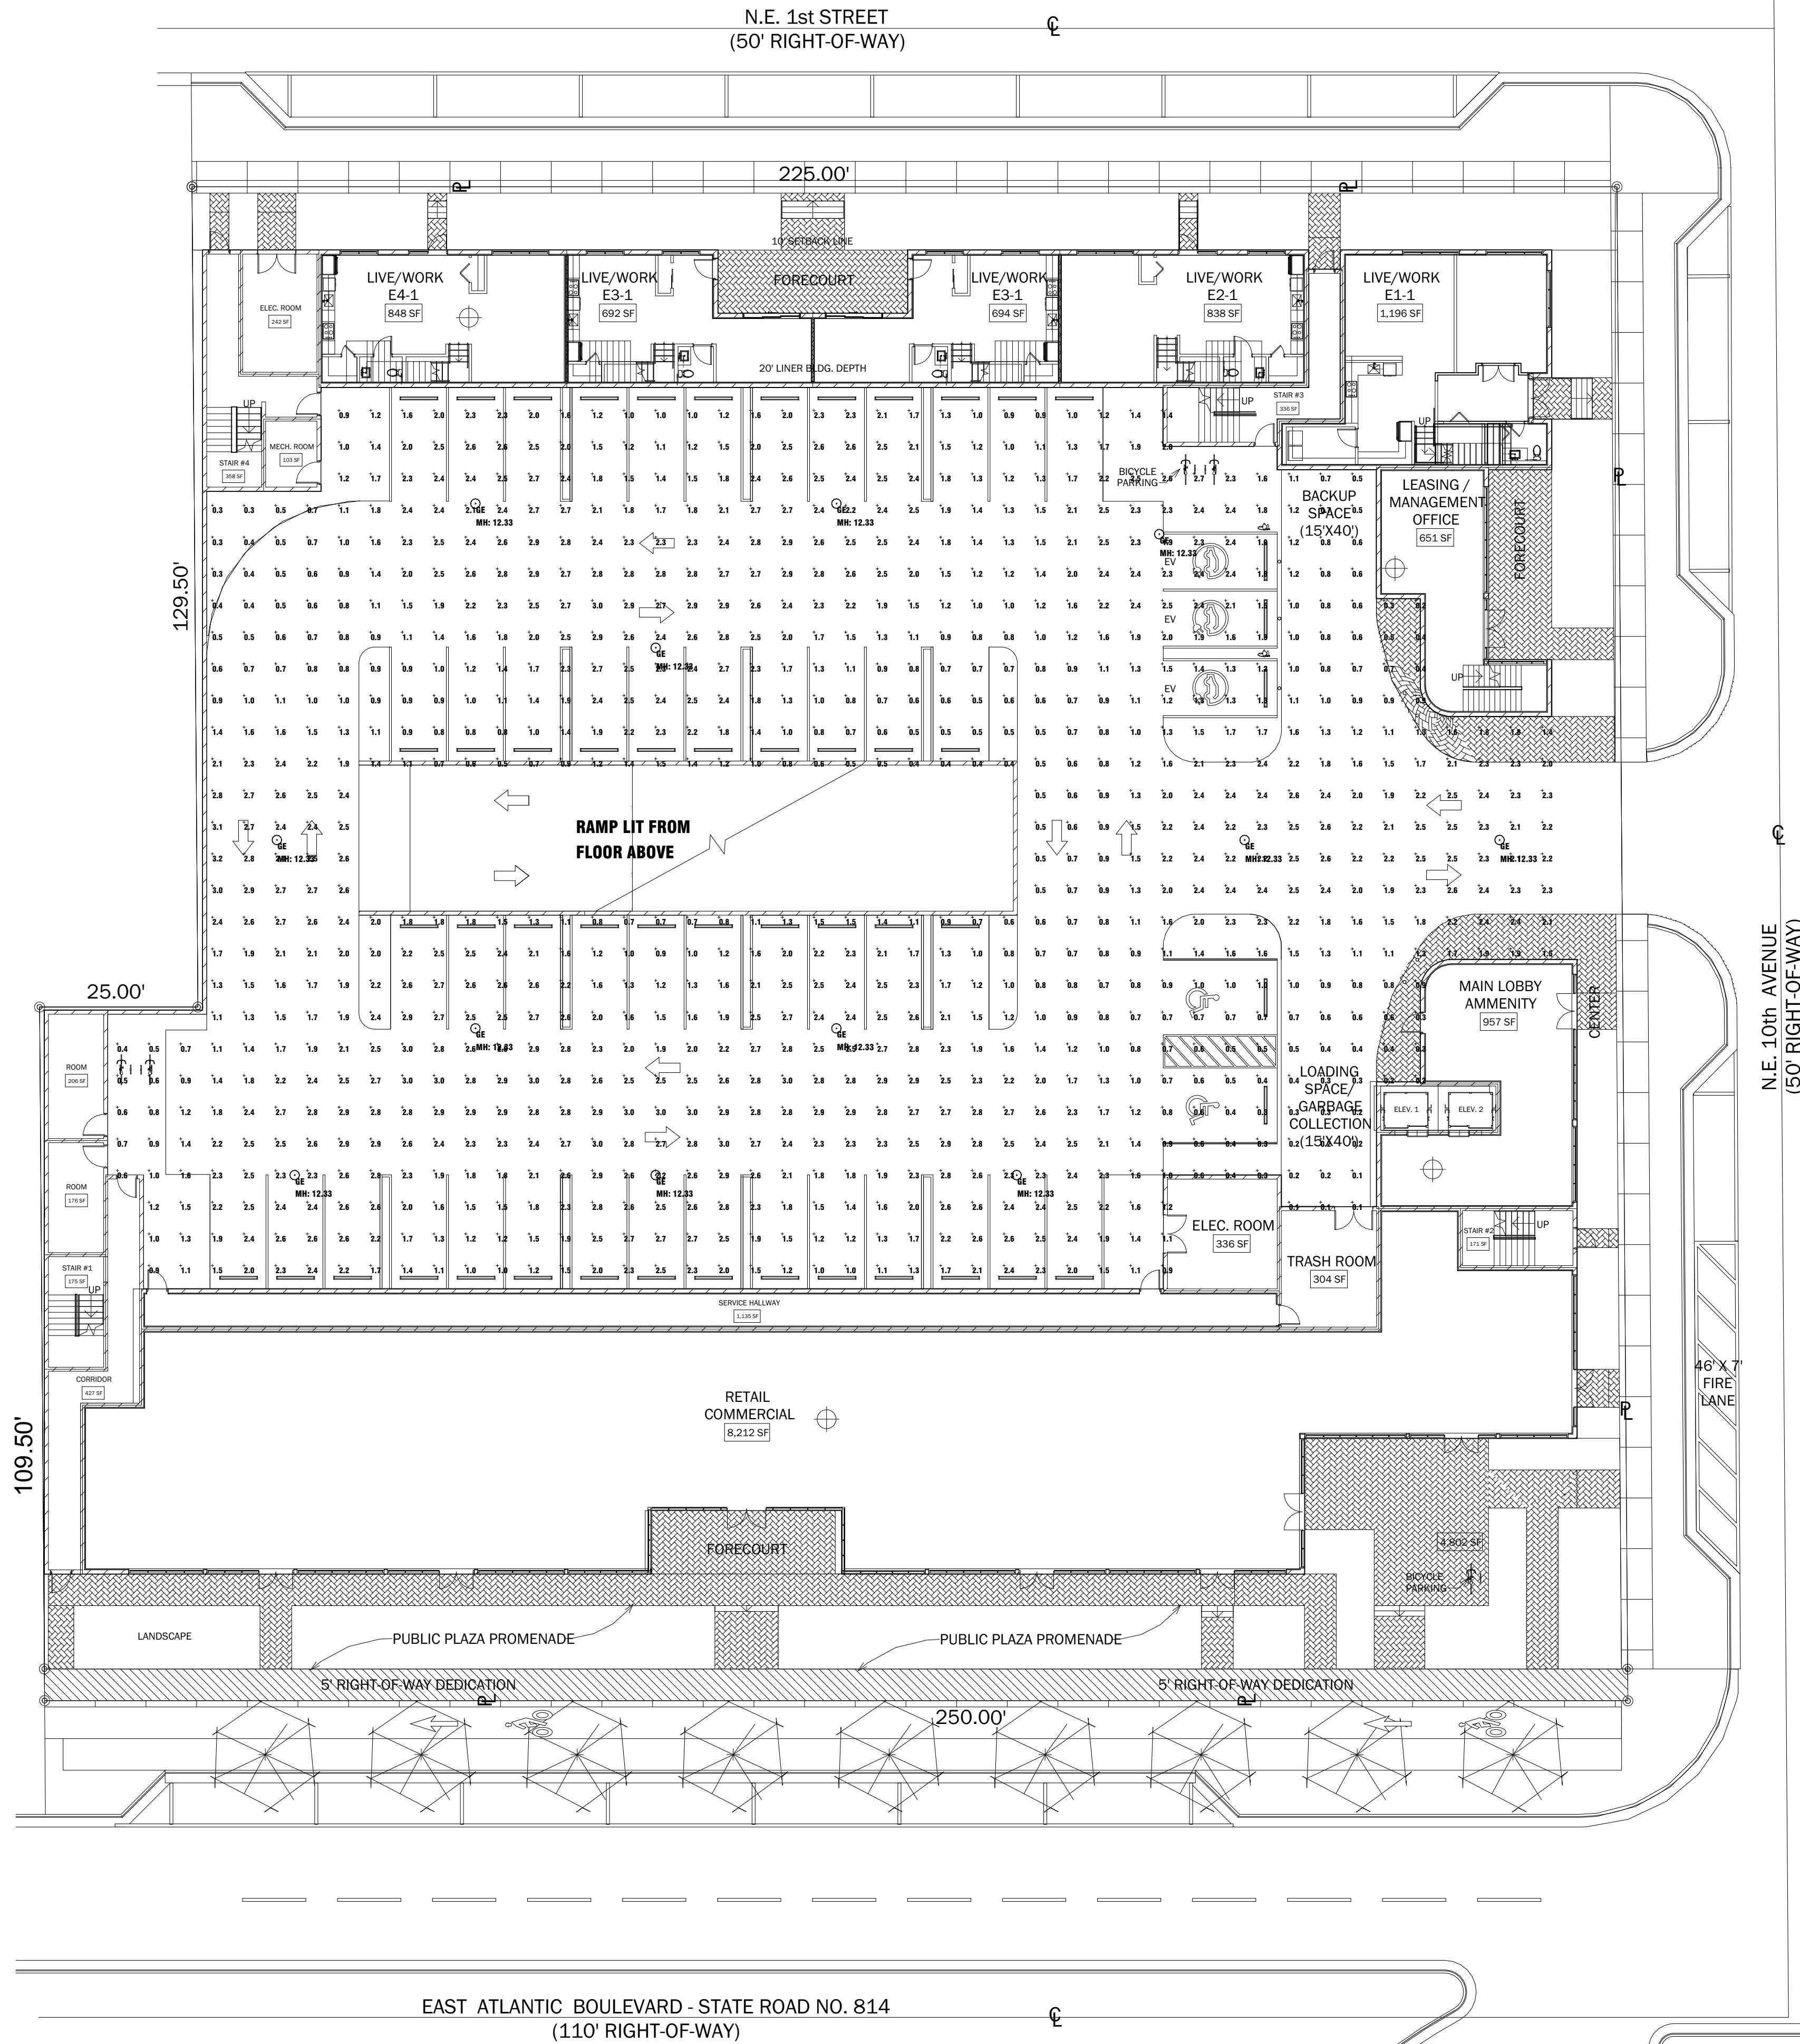

# GROUND LEVEL PHOTOMETRICS - EMERGENCY



**AAC**  
PZ23-12000043  
04/02/2024

SCALE: 1/16" = 1'-0"

1  
PH-1A

Luminaire Schedule							
Project: 10_3_2023 911 E. ATLANTIC, POMPANO BCH - GND FLR - EM							
Symbol	Qty	Label	Arrangement	Lum. Lumens	LLD	Luminaire Watts	Total Watts
⊙	12	GE	Single	4153	0.900	36	432
				Description			
				GARDCO SVPG-A02-840-62-5RD-EM CIRCUIT ON GENERATOR			

Calculation Summary							
Project: 10_3_2023 911 E. ATLANTIC, POMPANO BCH - GND FLR - EM							
Label	CalcType	Units	Avg	Max	Min	Avg/Min	Max/Min
PG - GND LVL	Illuminance	Fc	1.72	3.2	0.1	17.20	32.00
			Grid Z				
			0				

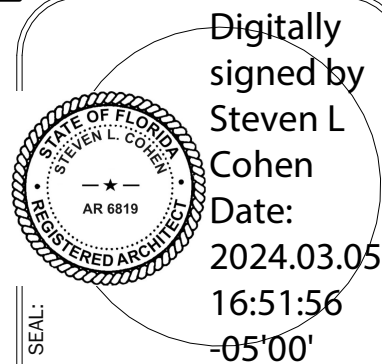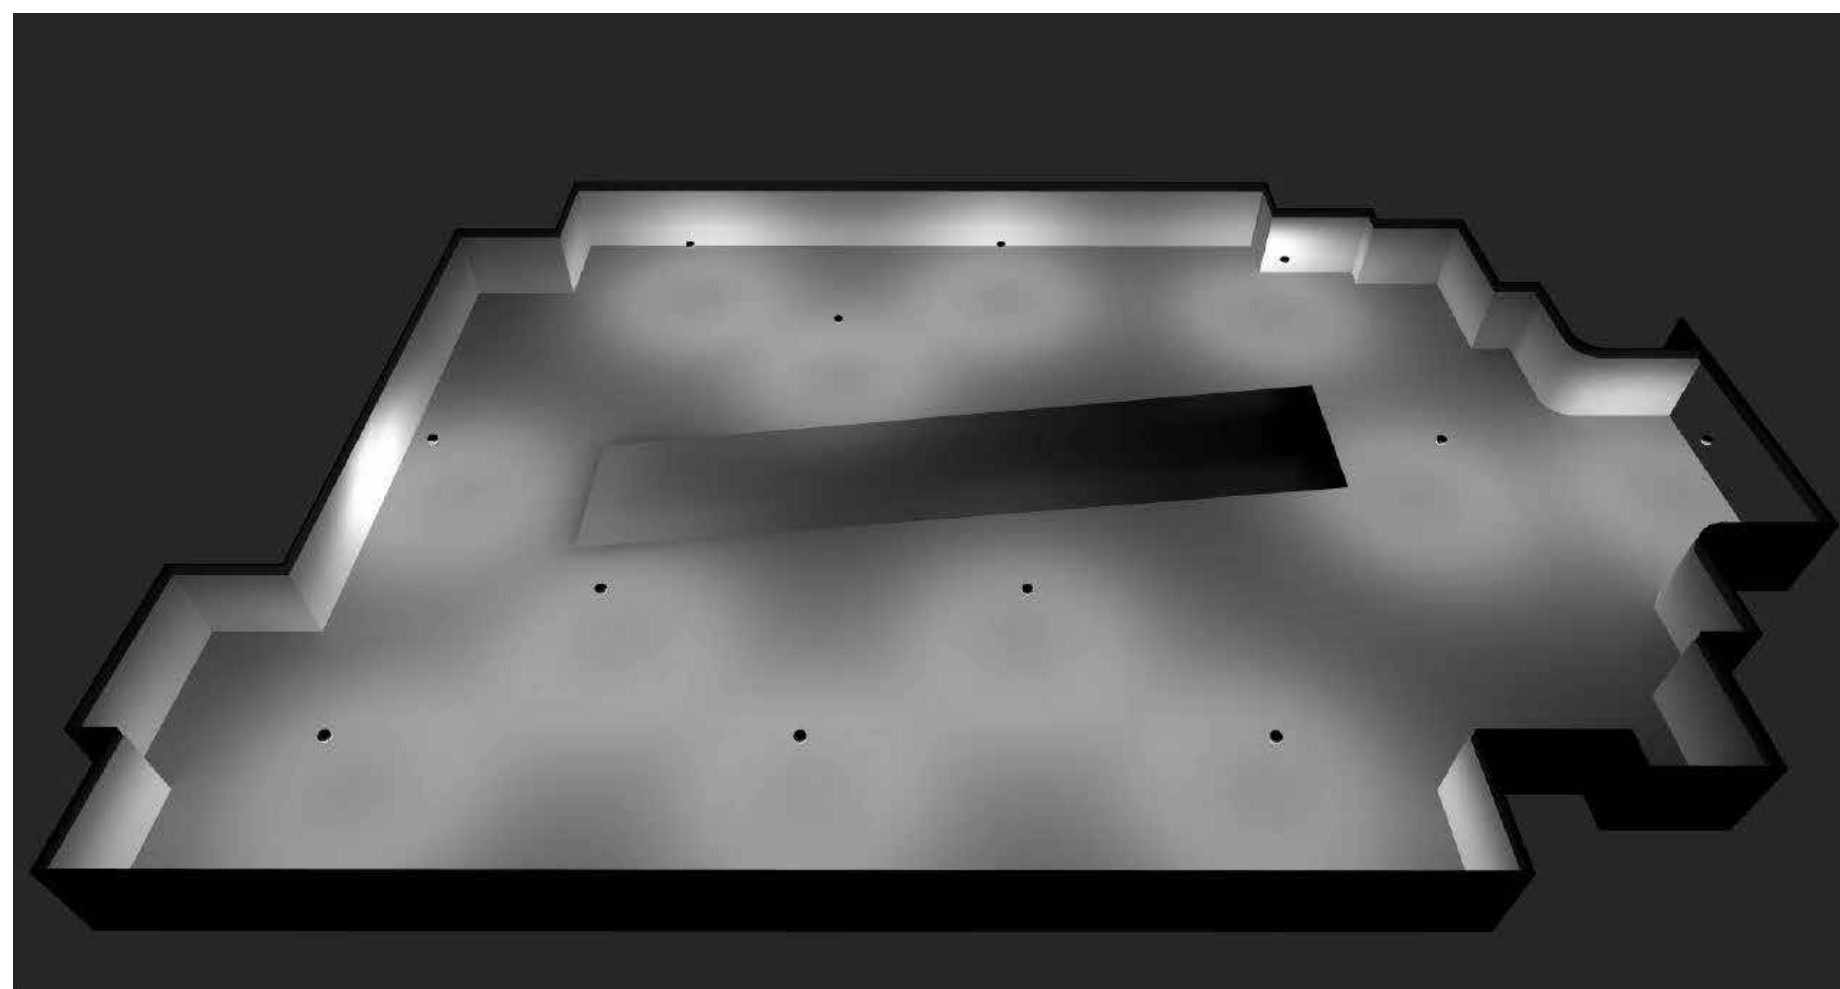

**Steven L. Cohen**  
and Associates, P.A.  
Architects - Interior Designers  
5905 TOWN CENTER ROAD, SUITE 202  
BOCA RATON, FLORIDA 33486  
(954) 971-1010  
E: info@slcarchitects.com

PROJECT NAME:  
**911 EAST ATLANTIC  
MIXED-USE PROJECT**  
PROJECT ADDRESS:  
**911 EAST ATLANTIC BLVD, POMPANO BEACH, FL 33060**

DRAWING NAME:  
**GROUND LEVEL PHOTOMETRICS -  
EMERGENCY**  
Principal: SLC  
Project Manager: SDY  
Drawn by: JQ/VB

REVISIONS  
No DATE DESCRIPTION

Project No: **12622**  
Issue Date: **03/05/2024**  
Drawing No: **PH-1A**

CONSTRUCTION DOCUMENTS - BID/PROGRESS SET