 



Scale: 1" = 20'-0"



Note: Visibility and unobstructed working space must be maintained from fire apparatus access routes to fire protection and life safety appliances/equipment. The only landscaping should be grass or mulch no plants or shrubs. These include but not limited to: Fire hydrants, fire department connections (FDC), post indicating valves (PIV), fire sprinkler risers, fire alarm control panels and electrical room locations require a minimum 36-inch clearance path to and on all sides. Fire hydrants require 36-inch clear space each side and rear with a 60-inch wide clear access from the fire apparatus access to fire hydrant. (NFPA 1-2021 Ch. 18 Sec. 18.5.7)

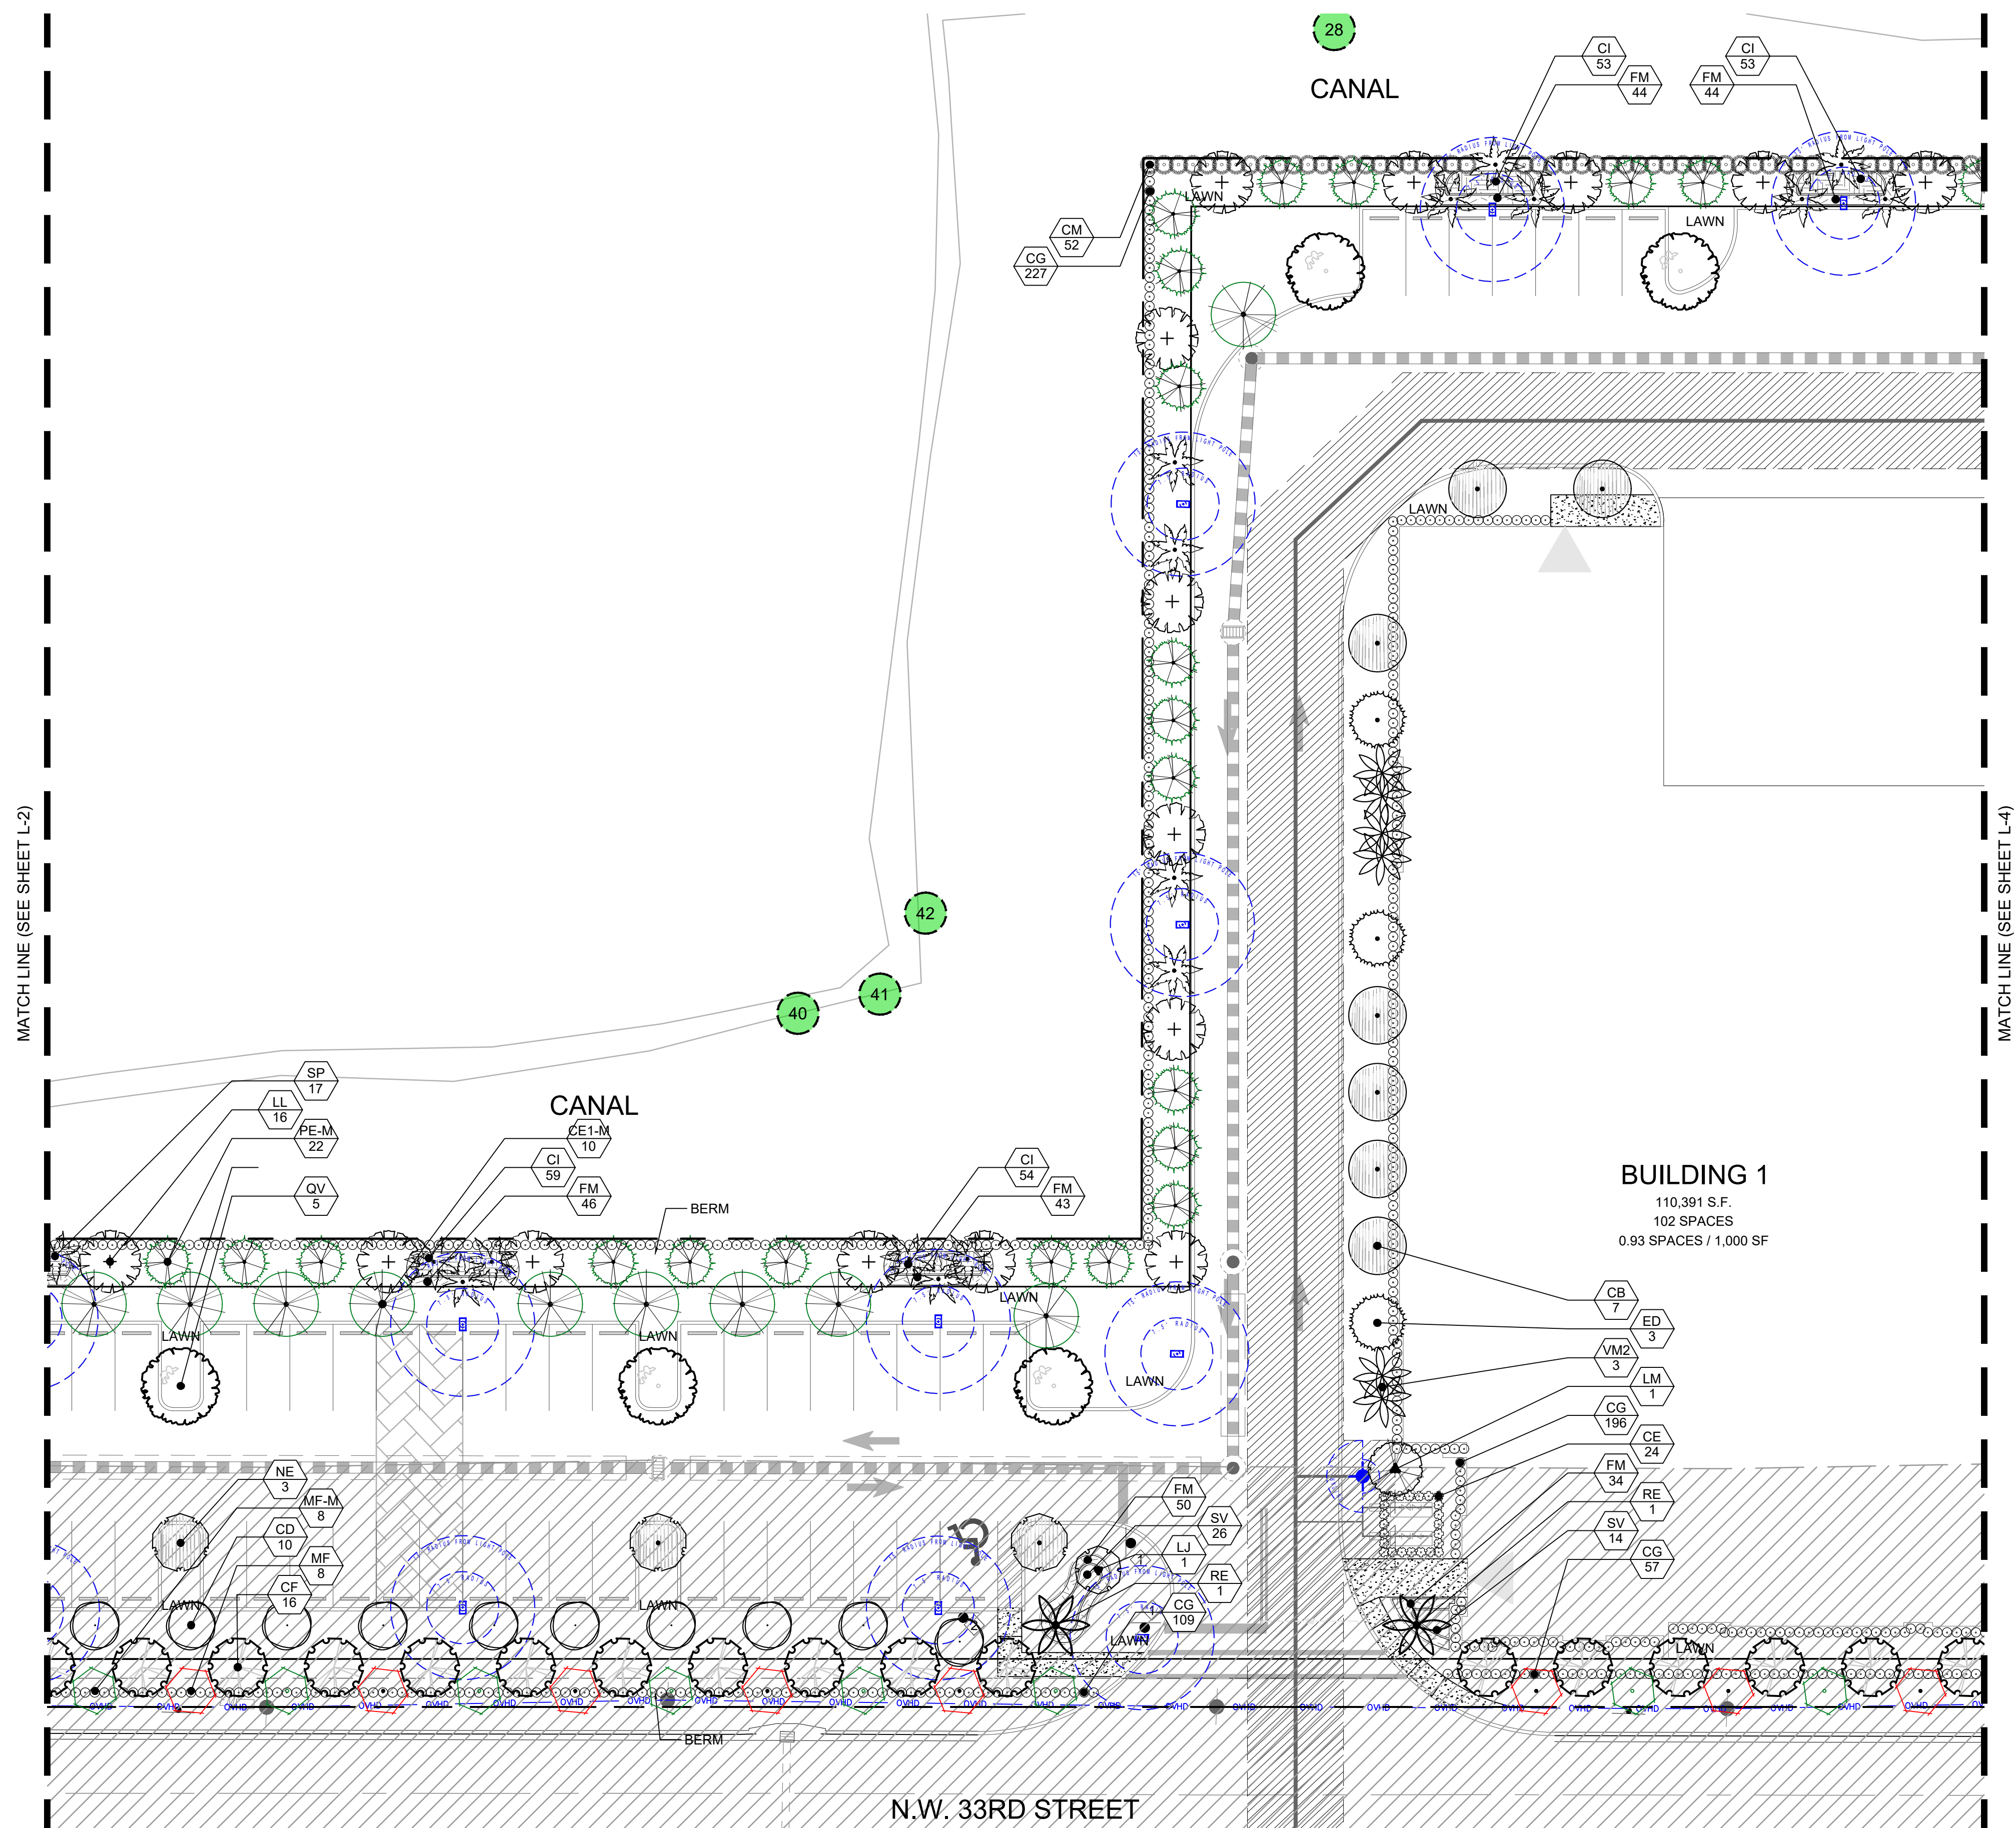

Project:

FESTIVAL FLEA MARKET SOUTH
NW 27TH AVE & NW 33RD STREET, POMPAHO BEACH, FL
LANDSCAPE PLAN

LANDSCAPE PLAN

[illegible]

Seal:

Lic. # LA6667290
Member: A.S.L.A.

Drawing: Landscape Plan

Da

Scale: See Left

Drawn by: MAV

Sheet No.

PZ25-12000043
05/27/2026

L-3

Cad Id.: 2025-060