


SHEET INDEX:

009.1 I-1
009.1.1 I-2
009.1.2 I-3
009.1.3 I-4
009.1.4 I-5

IRRIGATION SITE PLAN
IRRIGATION PLAN
IRRIGATION PLAN
IRRIGATION PLAN
IRRIGATION DETAILS

Control Precipitation
Design, Inc.
Irrigation Consultants
P.O. Box 2268
Boca Raton, FL 33427
Tel: (561) 391-3936
e-mail: midsn@bellsouth.net

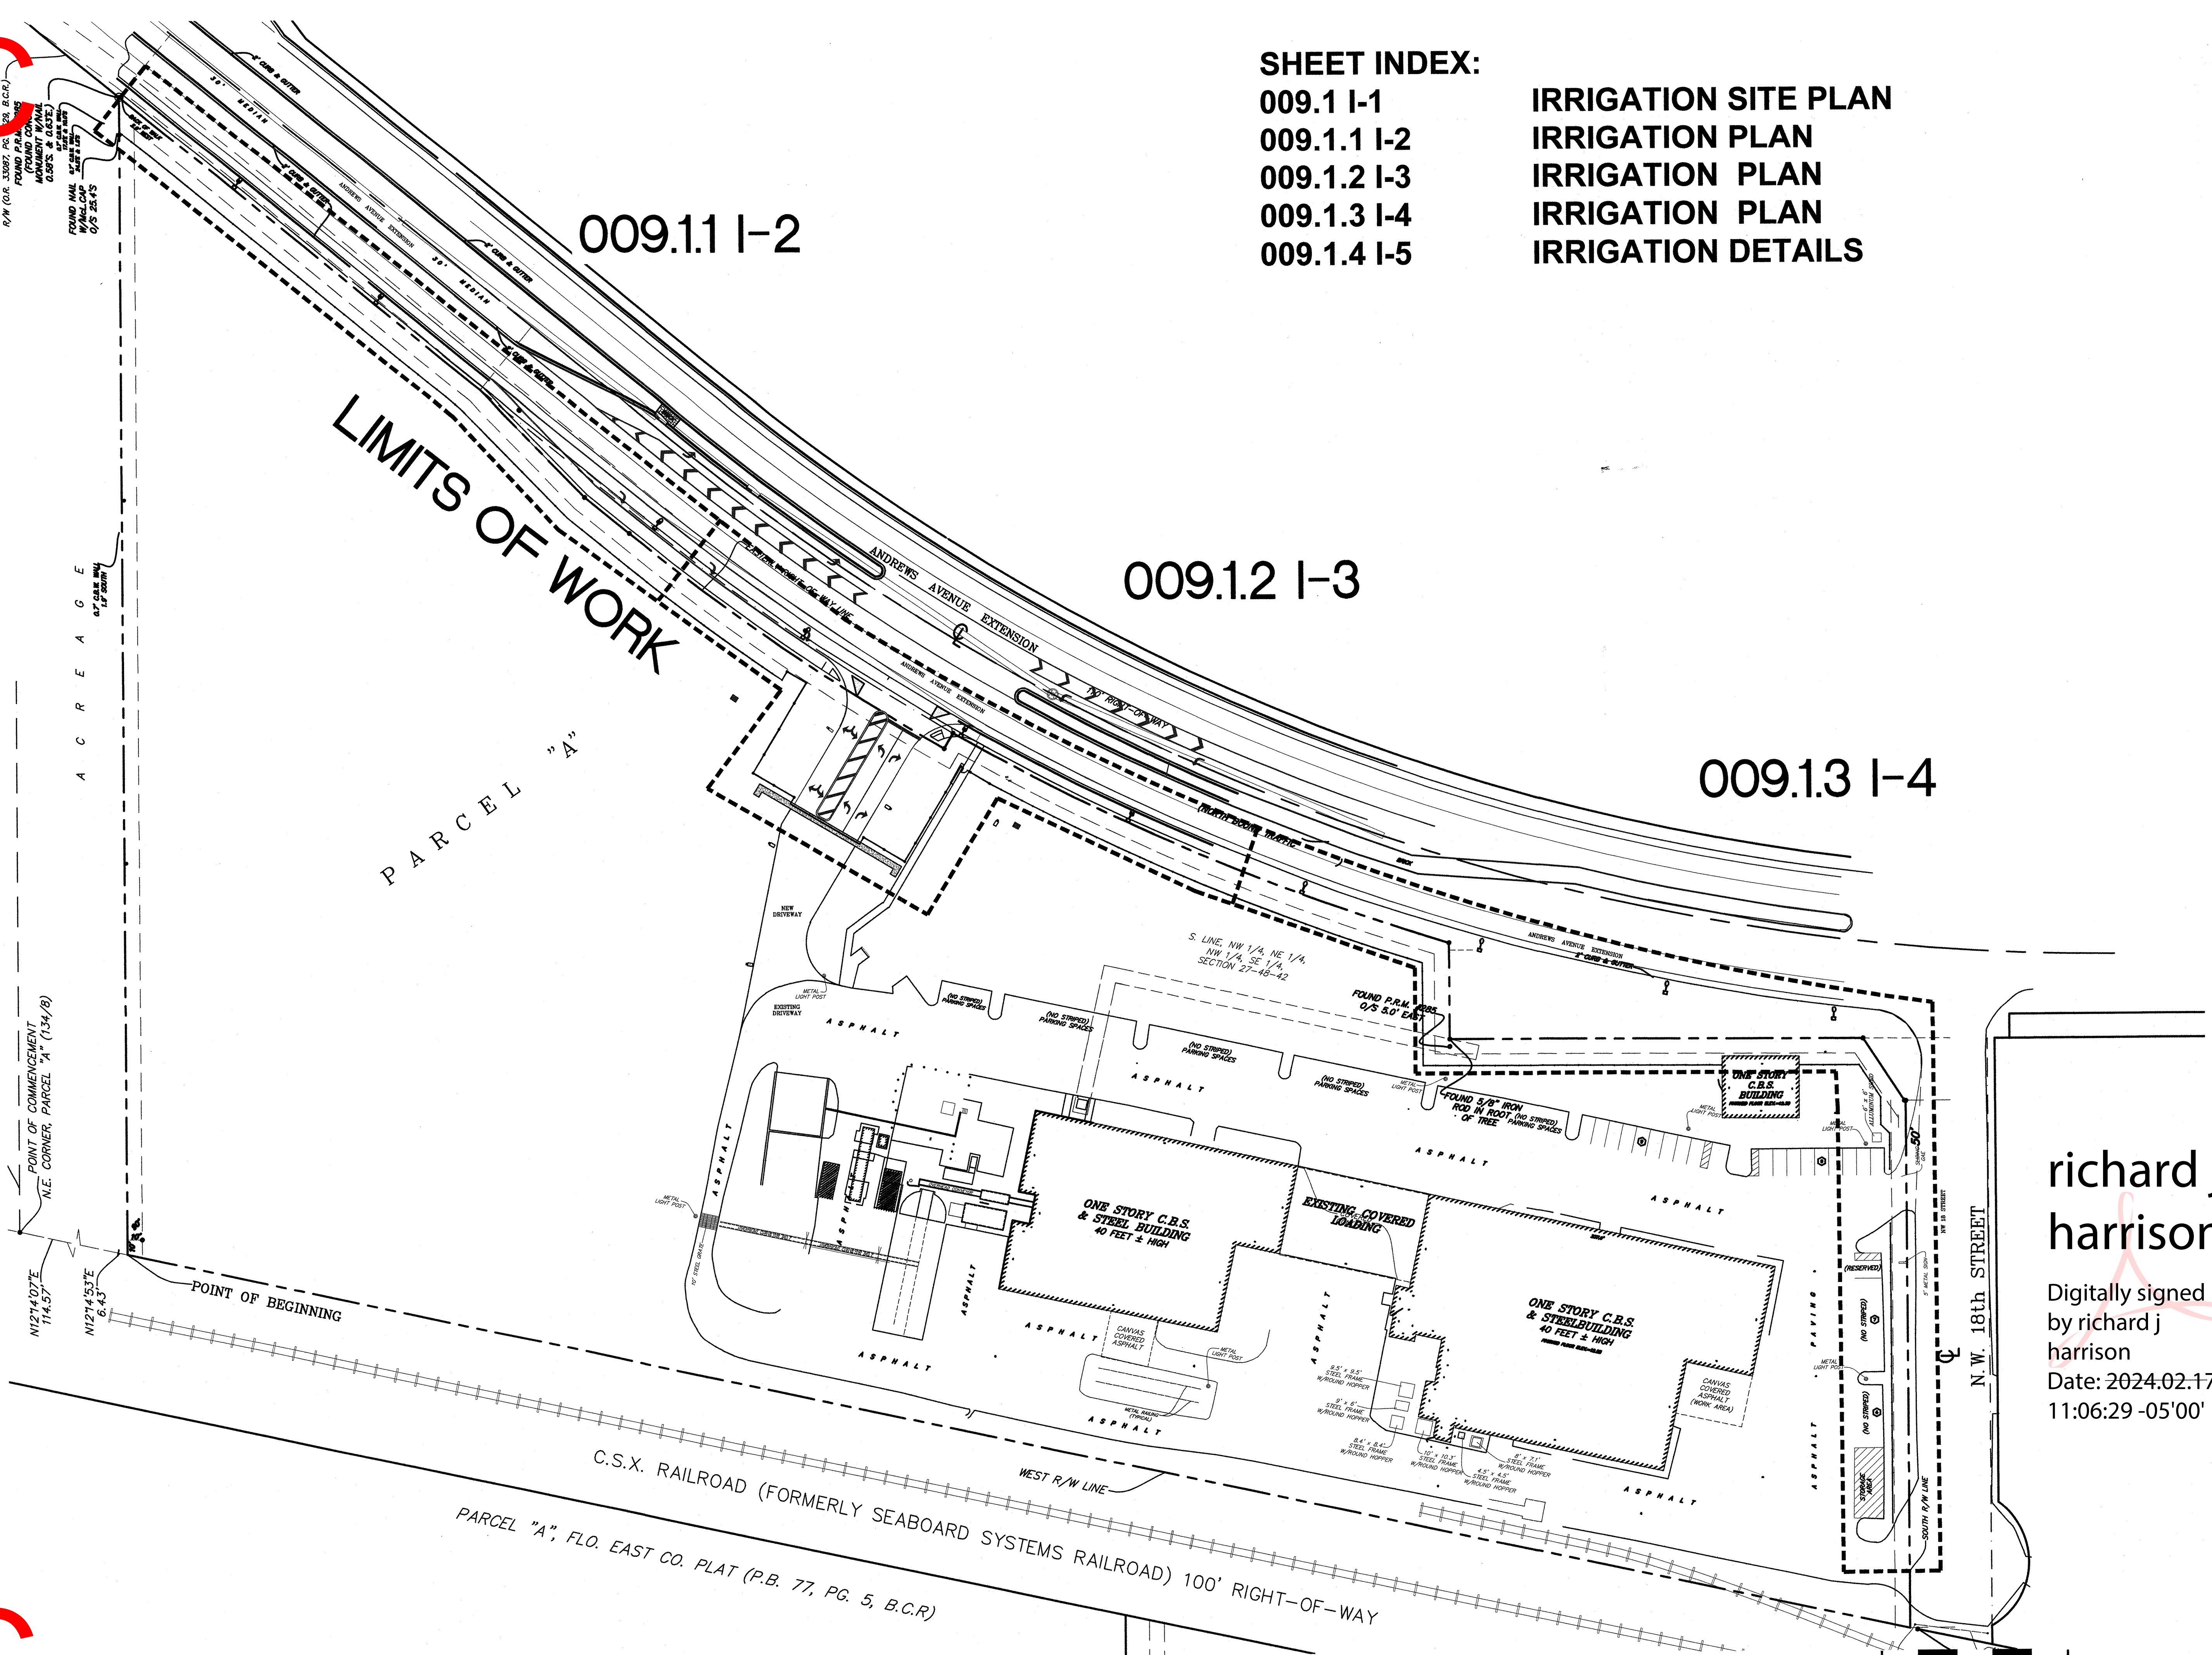

Bonsal Turn Lane
1200 NW 18th St.
Pompano Beach, FL 33069

**richard j
harrison**

Digitally signed
by richard j
harrison
Date: 2024.02.17
11:06:29 -05'00'

ISSUE HISTORY
PROJ NO: 23034A
PROJ MGR: DC
DRAWN BY: RH
CHECKED BY:

DRAWING TITLE:
**Irrigation
Site Plan**

SHEET:
009.1 I-1

SUBMISSION
02/14/24
NOT FOR CONSTRUCTION

