


Luminaire Schedule			LLF	Luminaire Lumens	Luminaire Watts
Symbol	Label	Description			
	P-Existing	Single	Lithonia Lighting LITHONIA HLF2 LED P1 40K WFL MVOLT IS DDBXD	0.900	45470
	SA	Single	Xtra Light VNTL-35000L-40K-DIM-4M-N-XX-XX-HSS, Pole Mount	0.900	23260
	SB	Single	Xtra Light VNTM-25000L-40K-DIM-3M-N-XX-XX, Pole Mount	0.900	24804
	W-Existing	Single	Existing 300W Wall Mounted Area Light, T3 Optic	0.900	44053
	WA	Single	Xtra Light VNTL-35000L-50K-DIM-4M-N-XX-XX, Wall Mount	0.900	34852
	WB	Single	Xtra Light VNTM-25000L-40K-DIM-4M-N-XX-XX, Wall Mount	0.900	24897


Calculation Summary						
Label	CalcType	Units	Avg	Max	Min	Avg/Min
Site	Illuminance	Fc	3.79	11.9	1.0	3.79
						11.90

2281 NW 16TH ST. SITE LIGHTING FIXTURE SCHEDULE							
TYPE	MANUFACTURER	CATALOG NUMBER	DESCRIPTION	LAMPS	VOLTS	MOUNTING	INPUT WATTS
				Type			
P-EXISTING		EXISTING SITE	SITE LUMINAIRE	LED INCLUDED	XX	POLE	330W
SA	XTRALIGHT	VNTL-35000L-40K-DIM-4M-N-XX-XX-HSS	LED SITE LUMINAIRE WITH HOUSESHIELD	LED INCLUDED	XX	POLE	250W
SB	XTRALIGHT	VNTM-25000L-40K-DIM-3M-N-XX-XX	LED SITE LUMINAIRE	LED INCLUDED	XX	POLE	170W
W-EXISTING		EXISTING WALL PACK	WALL PACK	LED INCLUDED	XX	WALL	300W
WA	XTRALIGHT	VNTL-35000L-50K-DIM-4M-N-XX-XX	LED WALL PACK	LED INCLUDED	XX	WALL	250W
WB	XTRALIGHT	VNTM-25000L-40K-DIM-4M-N-XX-XX	LED WALL PACK	LED INCLUDED	XX	WALL	170W
LIGHTING SCHEDULE NOTES:							
1. For pricing please email Genesis Lighting at quotes@genesislighting.net, for technical questions please contact Ryan McCarthy at 850-980-5708							

BROWARD COUNTY CANAL
(100' RIGHT OF WAY)

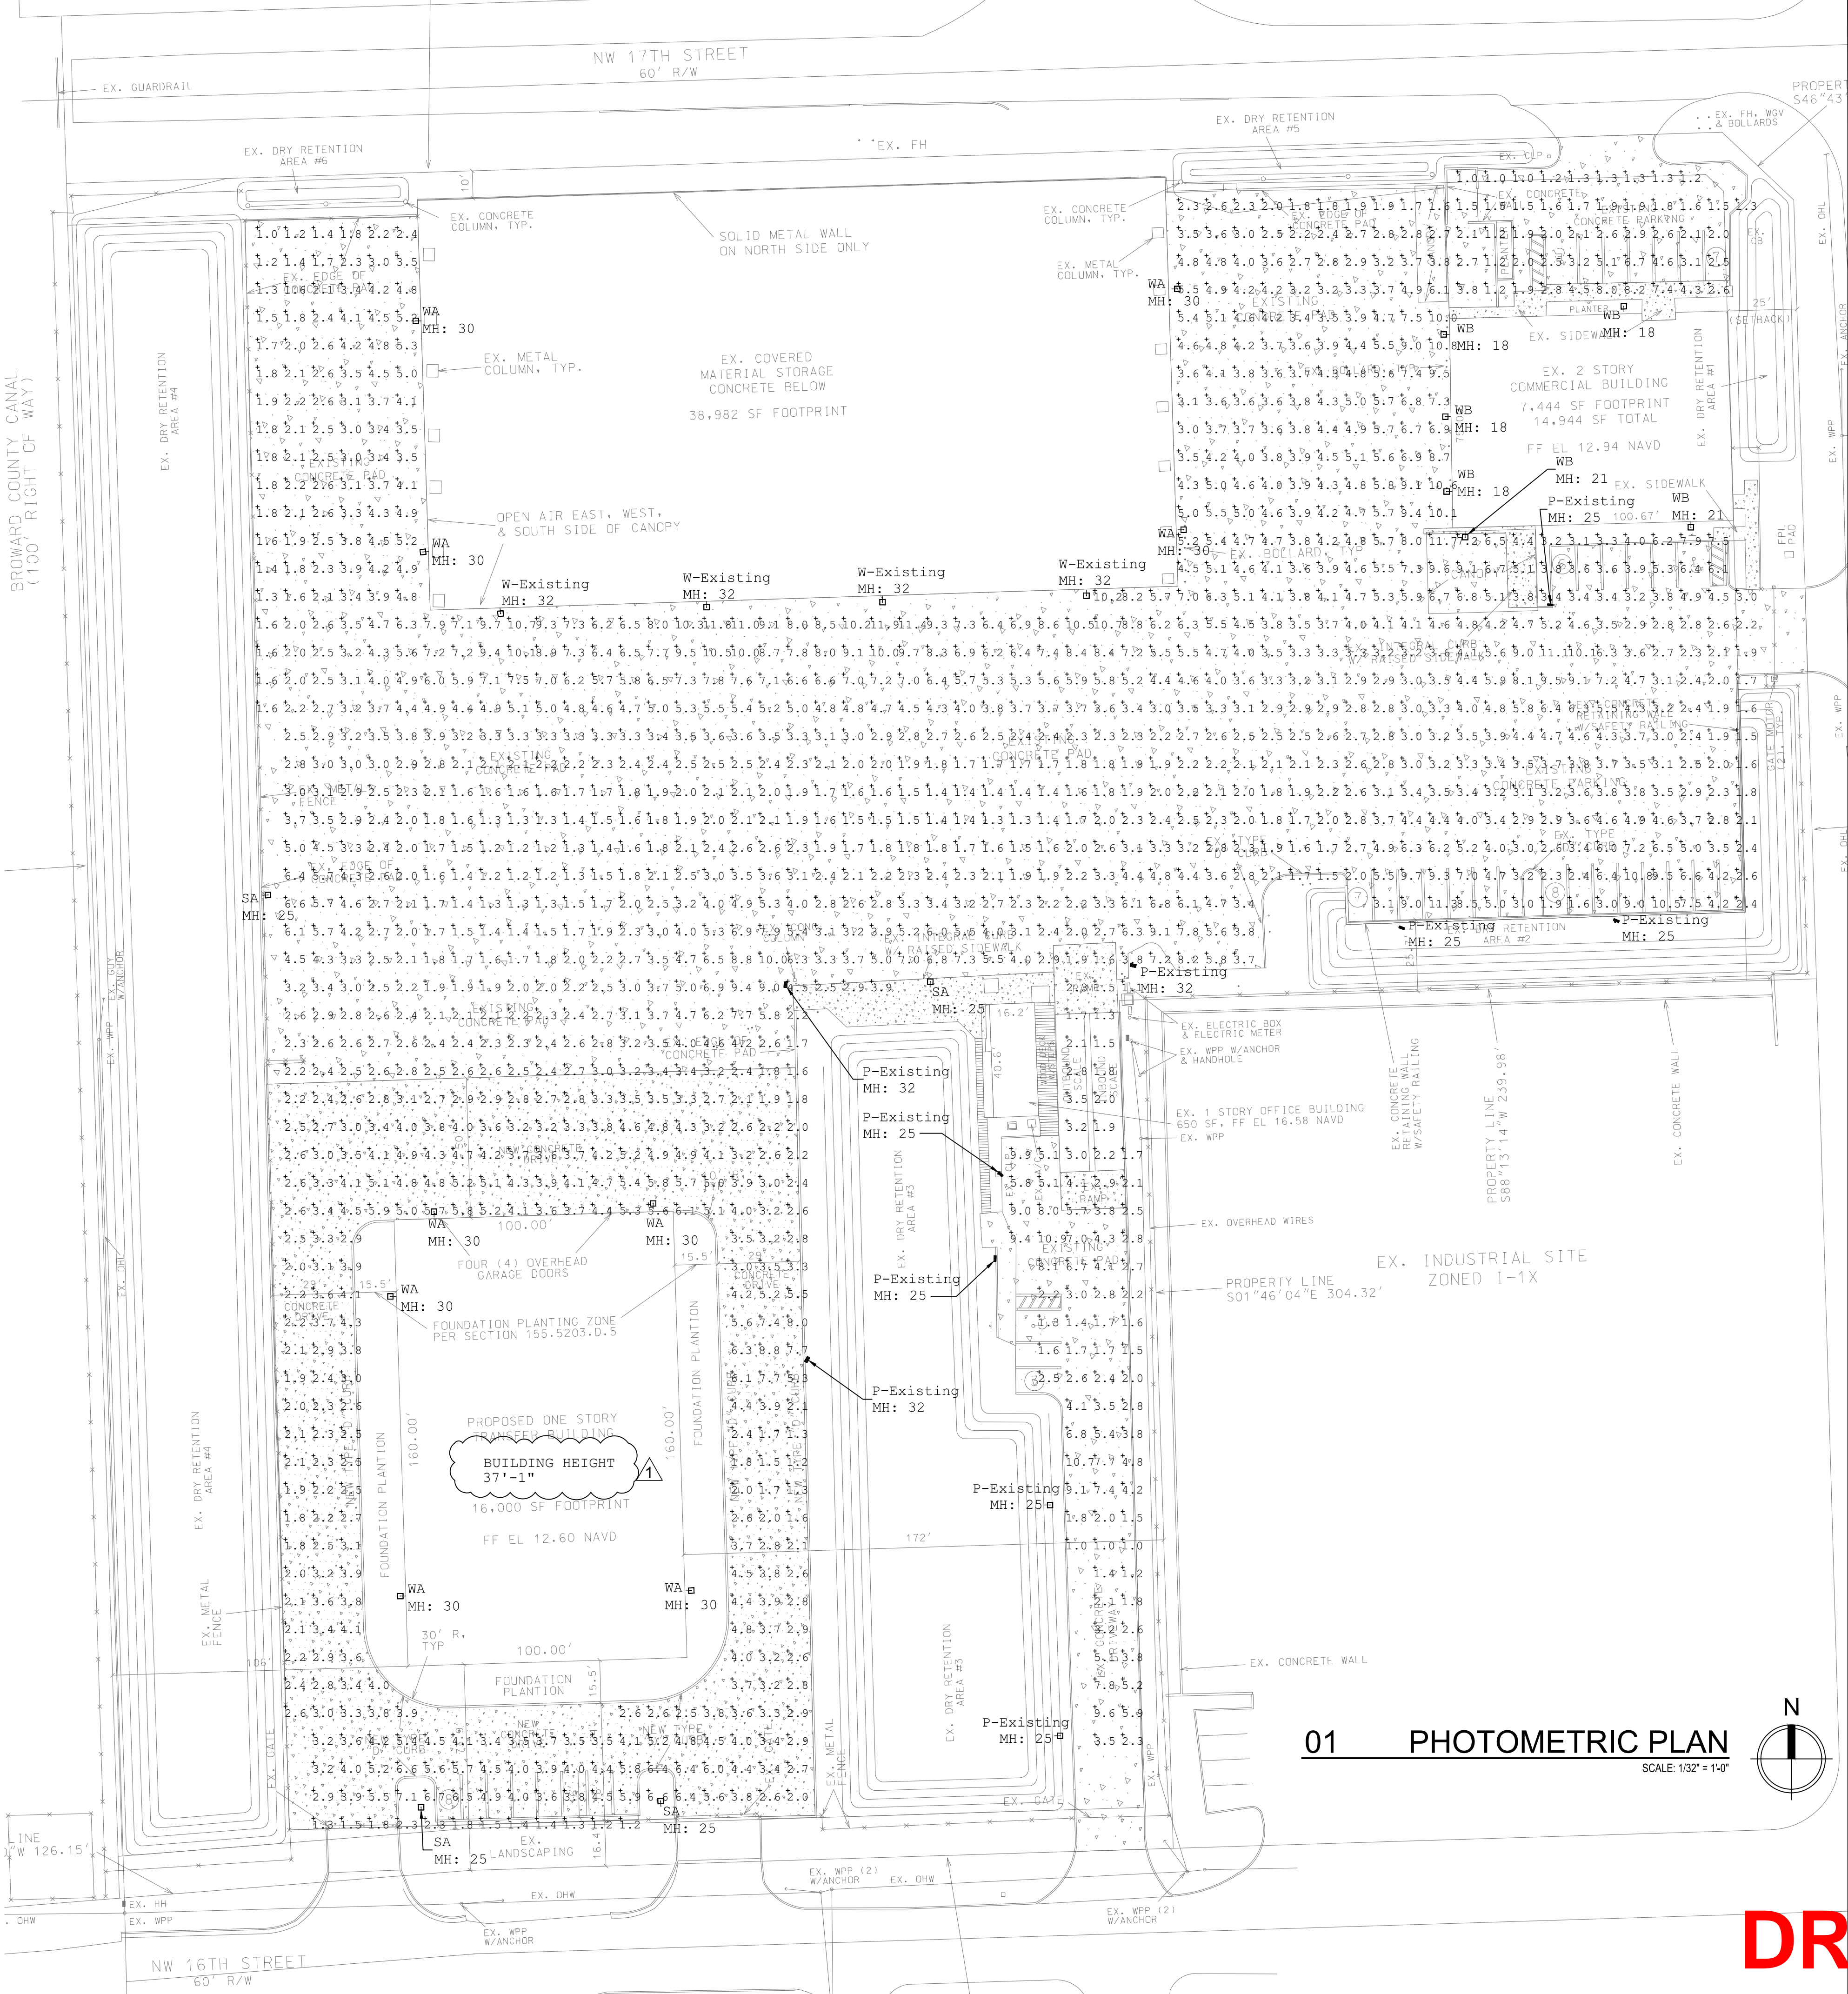

01 PHOTOMETRIC PLAN
SCALE: 1/32\"/>

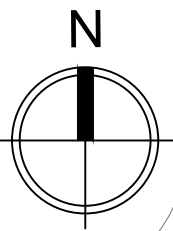

CONSULTANT

PREMIER
CONSULTING ENGINEERS, LLC

MECHANICAL | ELECTRICAL | PLUMBING
ENGINEERING + CONSULTING

DDA # 29969
2799 NW 2ND AVE., SUITE H-202, BOCA RATON, FL 33431
PH: 561.672.7344 | FAX: 561.892.2700
EMAIL: ME@PREMIERENGINEERS.COM

PROJECT:

2281 NW 16TH ST
POMPANO BEACH, FL

DRAWING ISSUES

NO.	ISSUE	DATE
1.	OWNER REVIEW	5/24/23
2.	OWNER REVIEW	5/24/23
3.	DRC COMMENTS	5/24/23

DRAWN BY: KH
CHECKED BY: KH

TITLE

SITE
PHOTOMETRIC
PLAN

PROJECT

SCALE

DATE

5/24/23

Copyright 2023

SHEET NUMBER

PH-1

DRC