


DESIGNED	DRAWN	CHECKED
NH	NH	JY

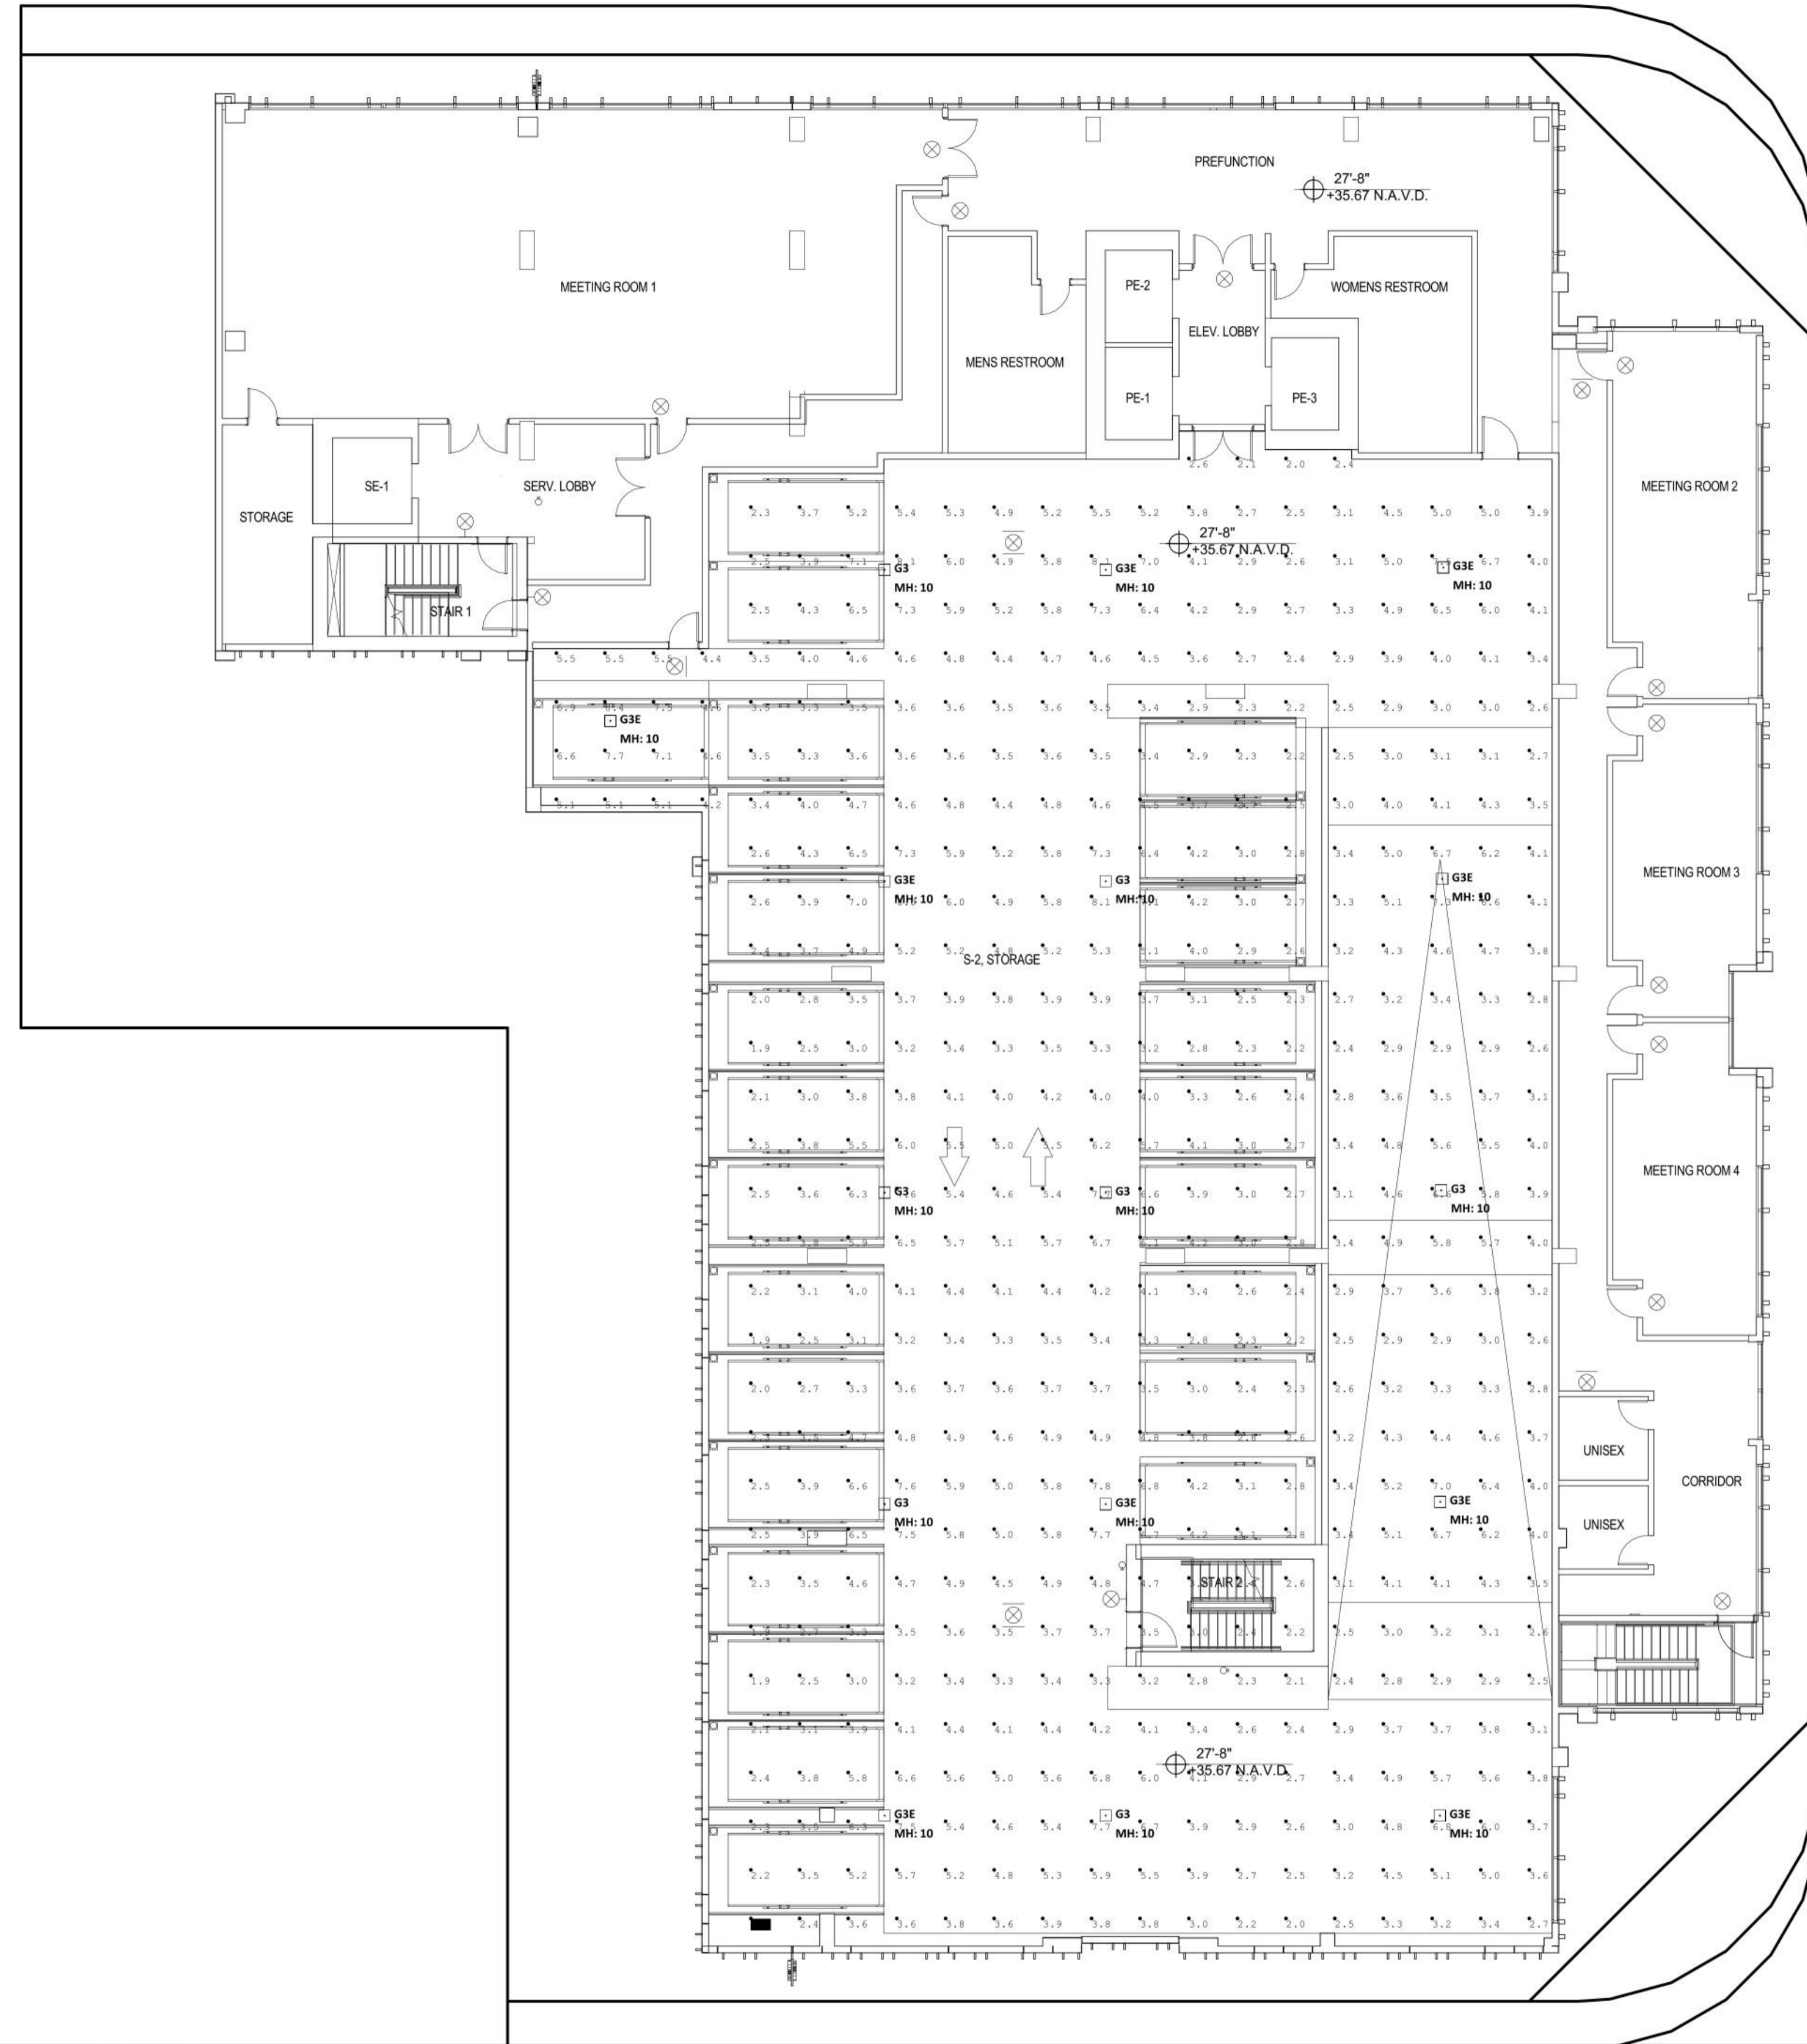

Luminaire Schedule								
Symbol	Qty	Label	Arrangement	Description	LLF	Luminaire Lumens	Luminaire Watts	Total Watts
•	7	G3	Single	Cree Lighting IG-B-NM-5S-4L-40K8-XX-WH	0.900	3860	33	231
•	9	G3E	Single	Cree Lighting IG-B-NM-5S-4L-40K8-XX-WH (Connected to Generator)	0.900	3860	35	297

Calculation Summary								
Label	CalcType	Units	Avg	Max	Min	Avg/Min	Max/Min	
Parking Garage_Floor	Illuminance	Fc	4.09	8.4	1.7	2.41	4.94	

REVISIONS

DATE:	COMM:
02.28.2024	23008

POMPAÑO HOTEL

101 S. OCEAN BLVD  
POMPAÑO BEACH, FL 33062

Digitally signed  
by Jiro Yates  
Date:  
2024.02.28  
10:47:01-05'00'

PHOTO METRIC THIRD FLOOR PLAN

P&Z  
AR-203  
PZ23-12000042  
05/22/2024