


DESIGNED	DRAWN	CHECKED
NH	NH	JY

REVISIONS

DATE:	COMM:
02.28.2024	23008


POMPANO HOTEL

101 S. OCEAN BLVD  
POMPANO BEACH, FL 33062

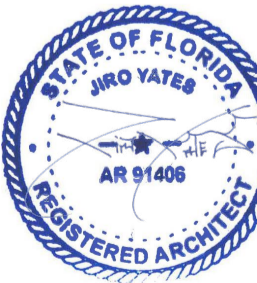

Digitally signed  
by Jiro Yates  
Date:  
2024.02.28  
09:57:47-05'00'

PHOTOGRAPHIC FOURTH FLOOR  
PLAN  
P&Z  
2024/02/28 09:27:18  
AR-504  
PZ23-12000042  
05/22/2024

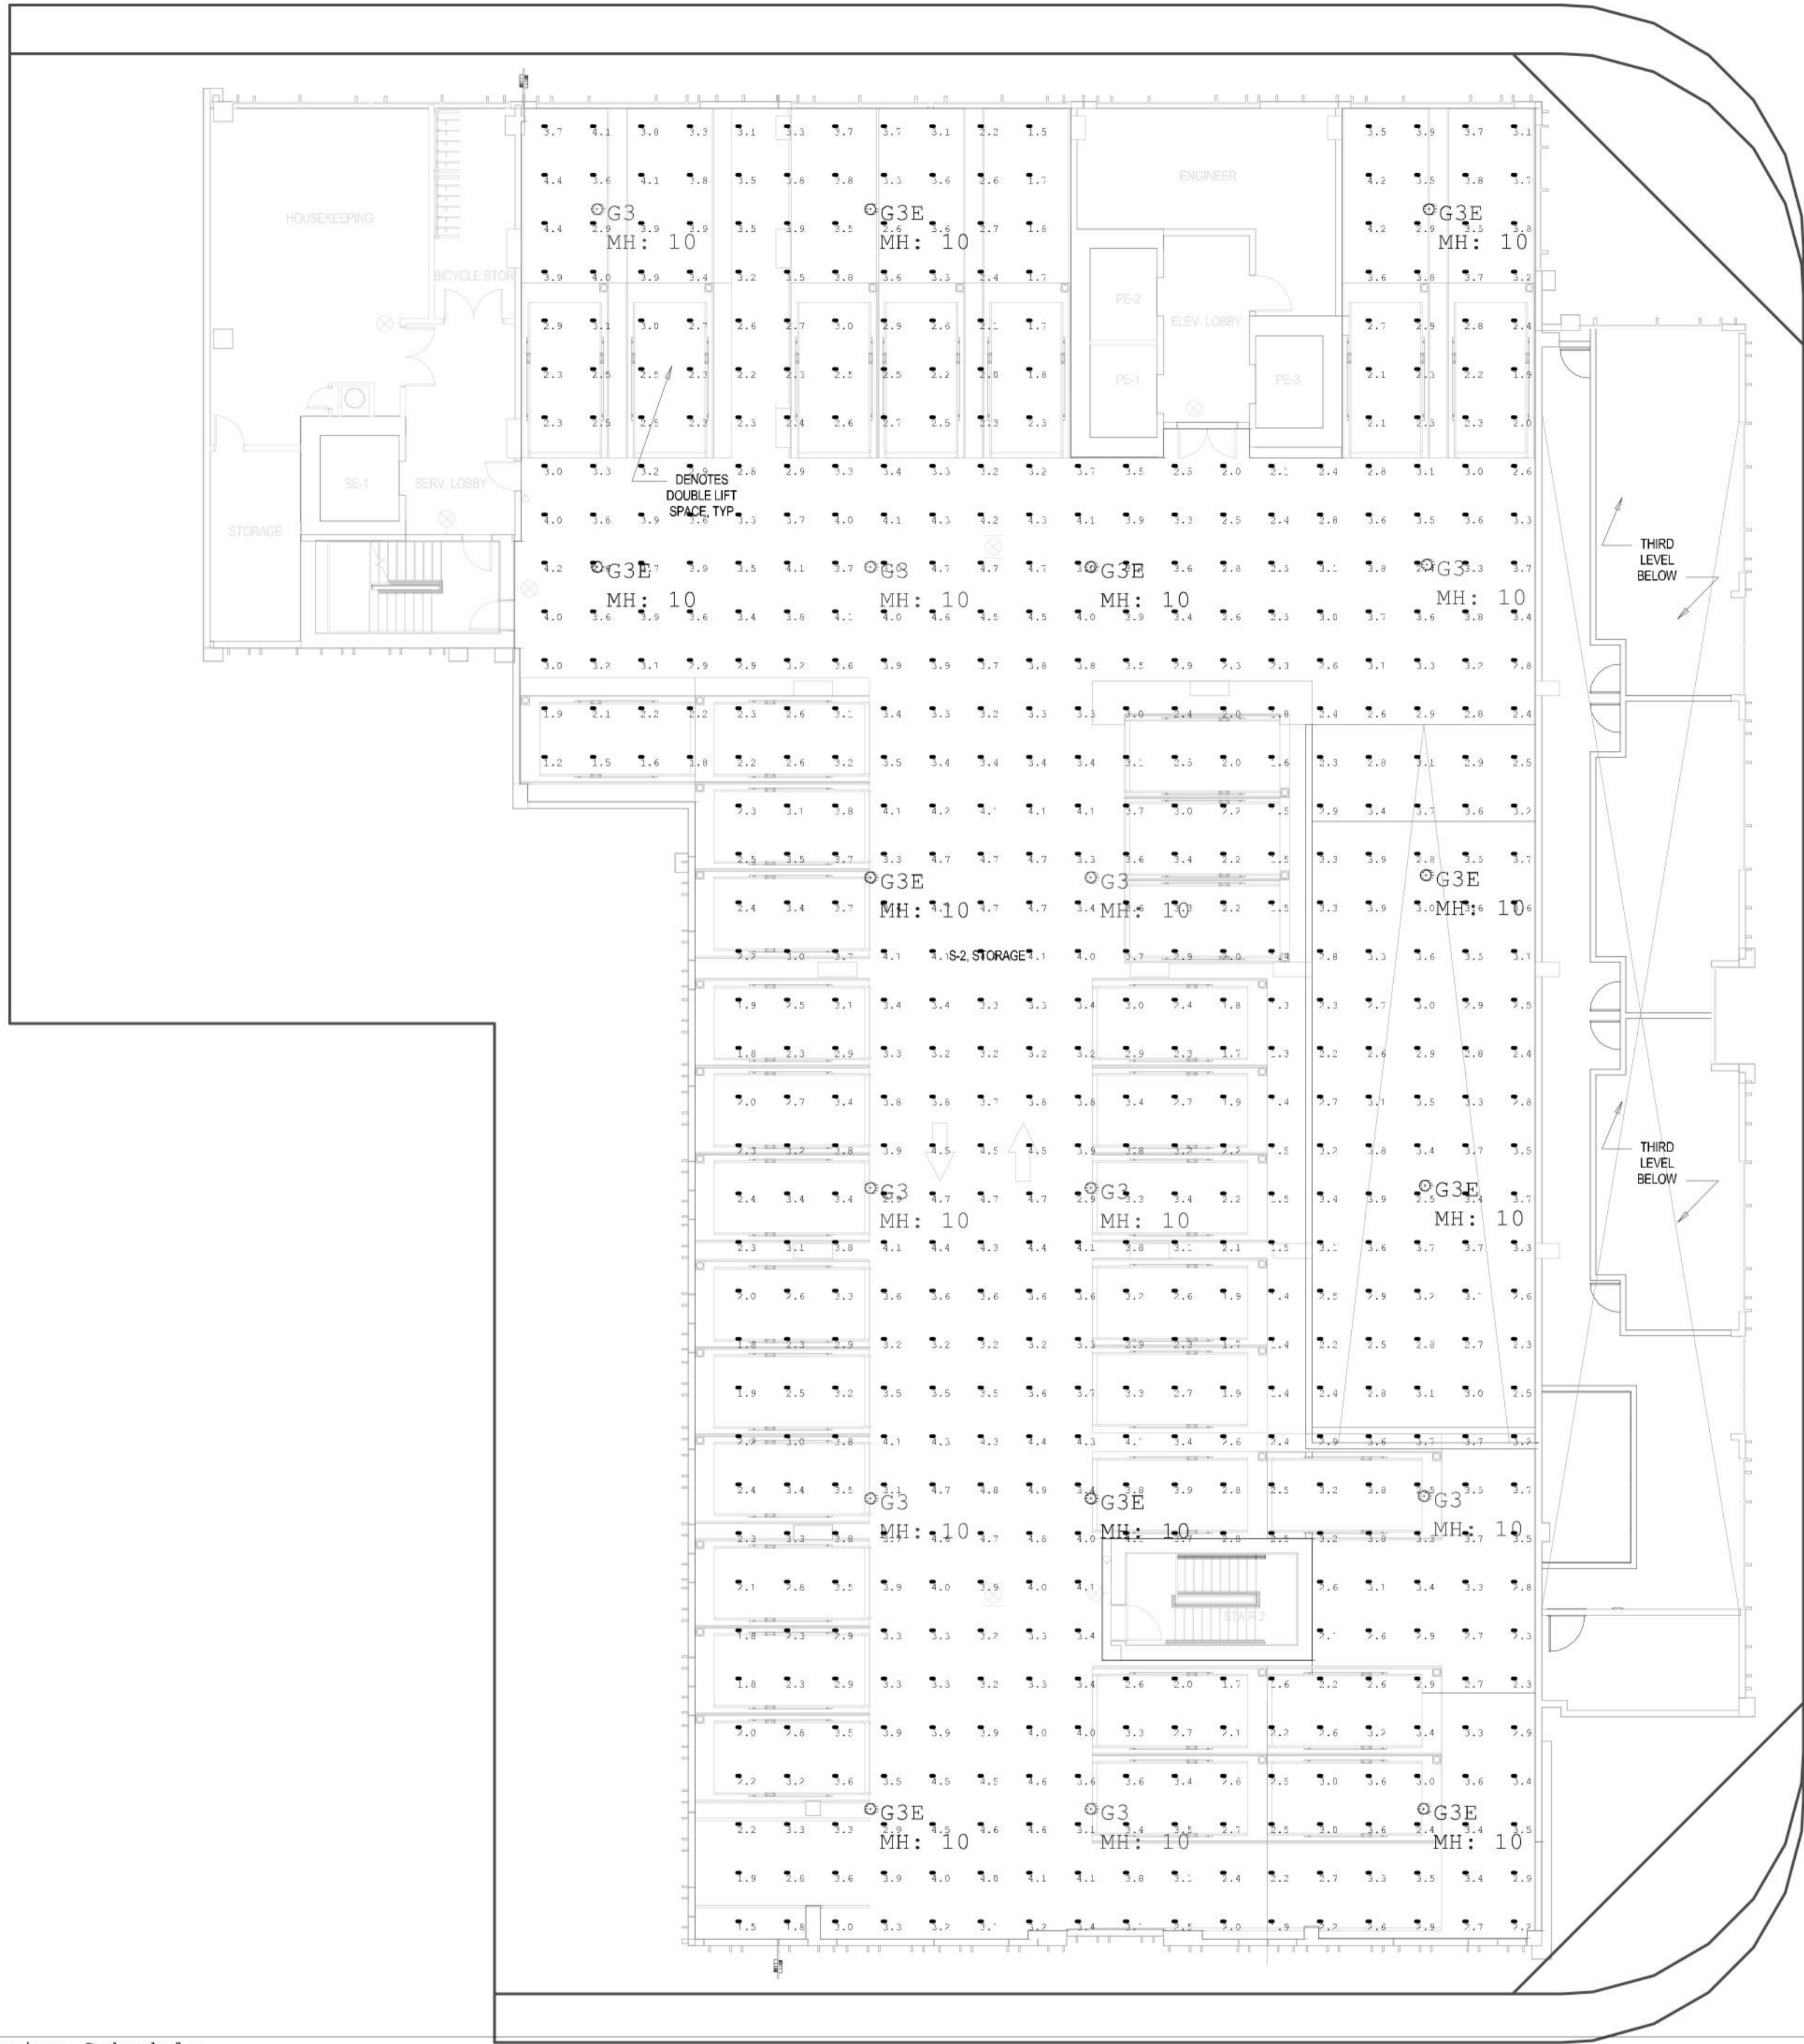

Luminaire Schedule								
Symbol	Qty	Label	Arrangement	Description	LLF	Luminaire Lumens	Luminaire Watts	Total Watts
⊙	10	G3E	Single	LSI Industries EXN-D-EGLED-03L-T5W-UNV-DIM-40-80CRI-XX (Connected To Generator)	0.900	3140	22	220
⊙	9	G3	Single	LSI Industries EXN-D-EGLED-03L-T5W-UNV-DIM-40-80CRI-XX	0.900	3140	22	198

Calculation Summary								
Label	CalcType	Units	Avg	Max	Min	Avg/Min	Max/Min	
Parking Garage_Floor	Illuminance	Fc	3.13	4.9	1.2	2.61	4.08	