
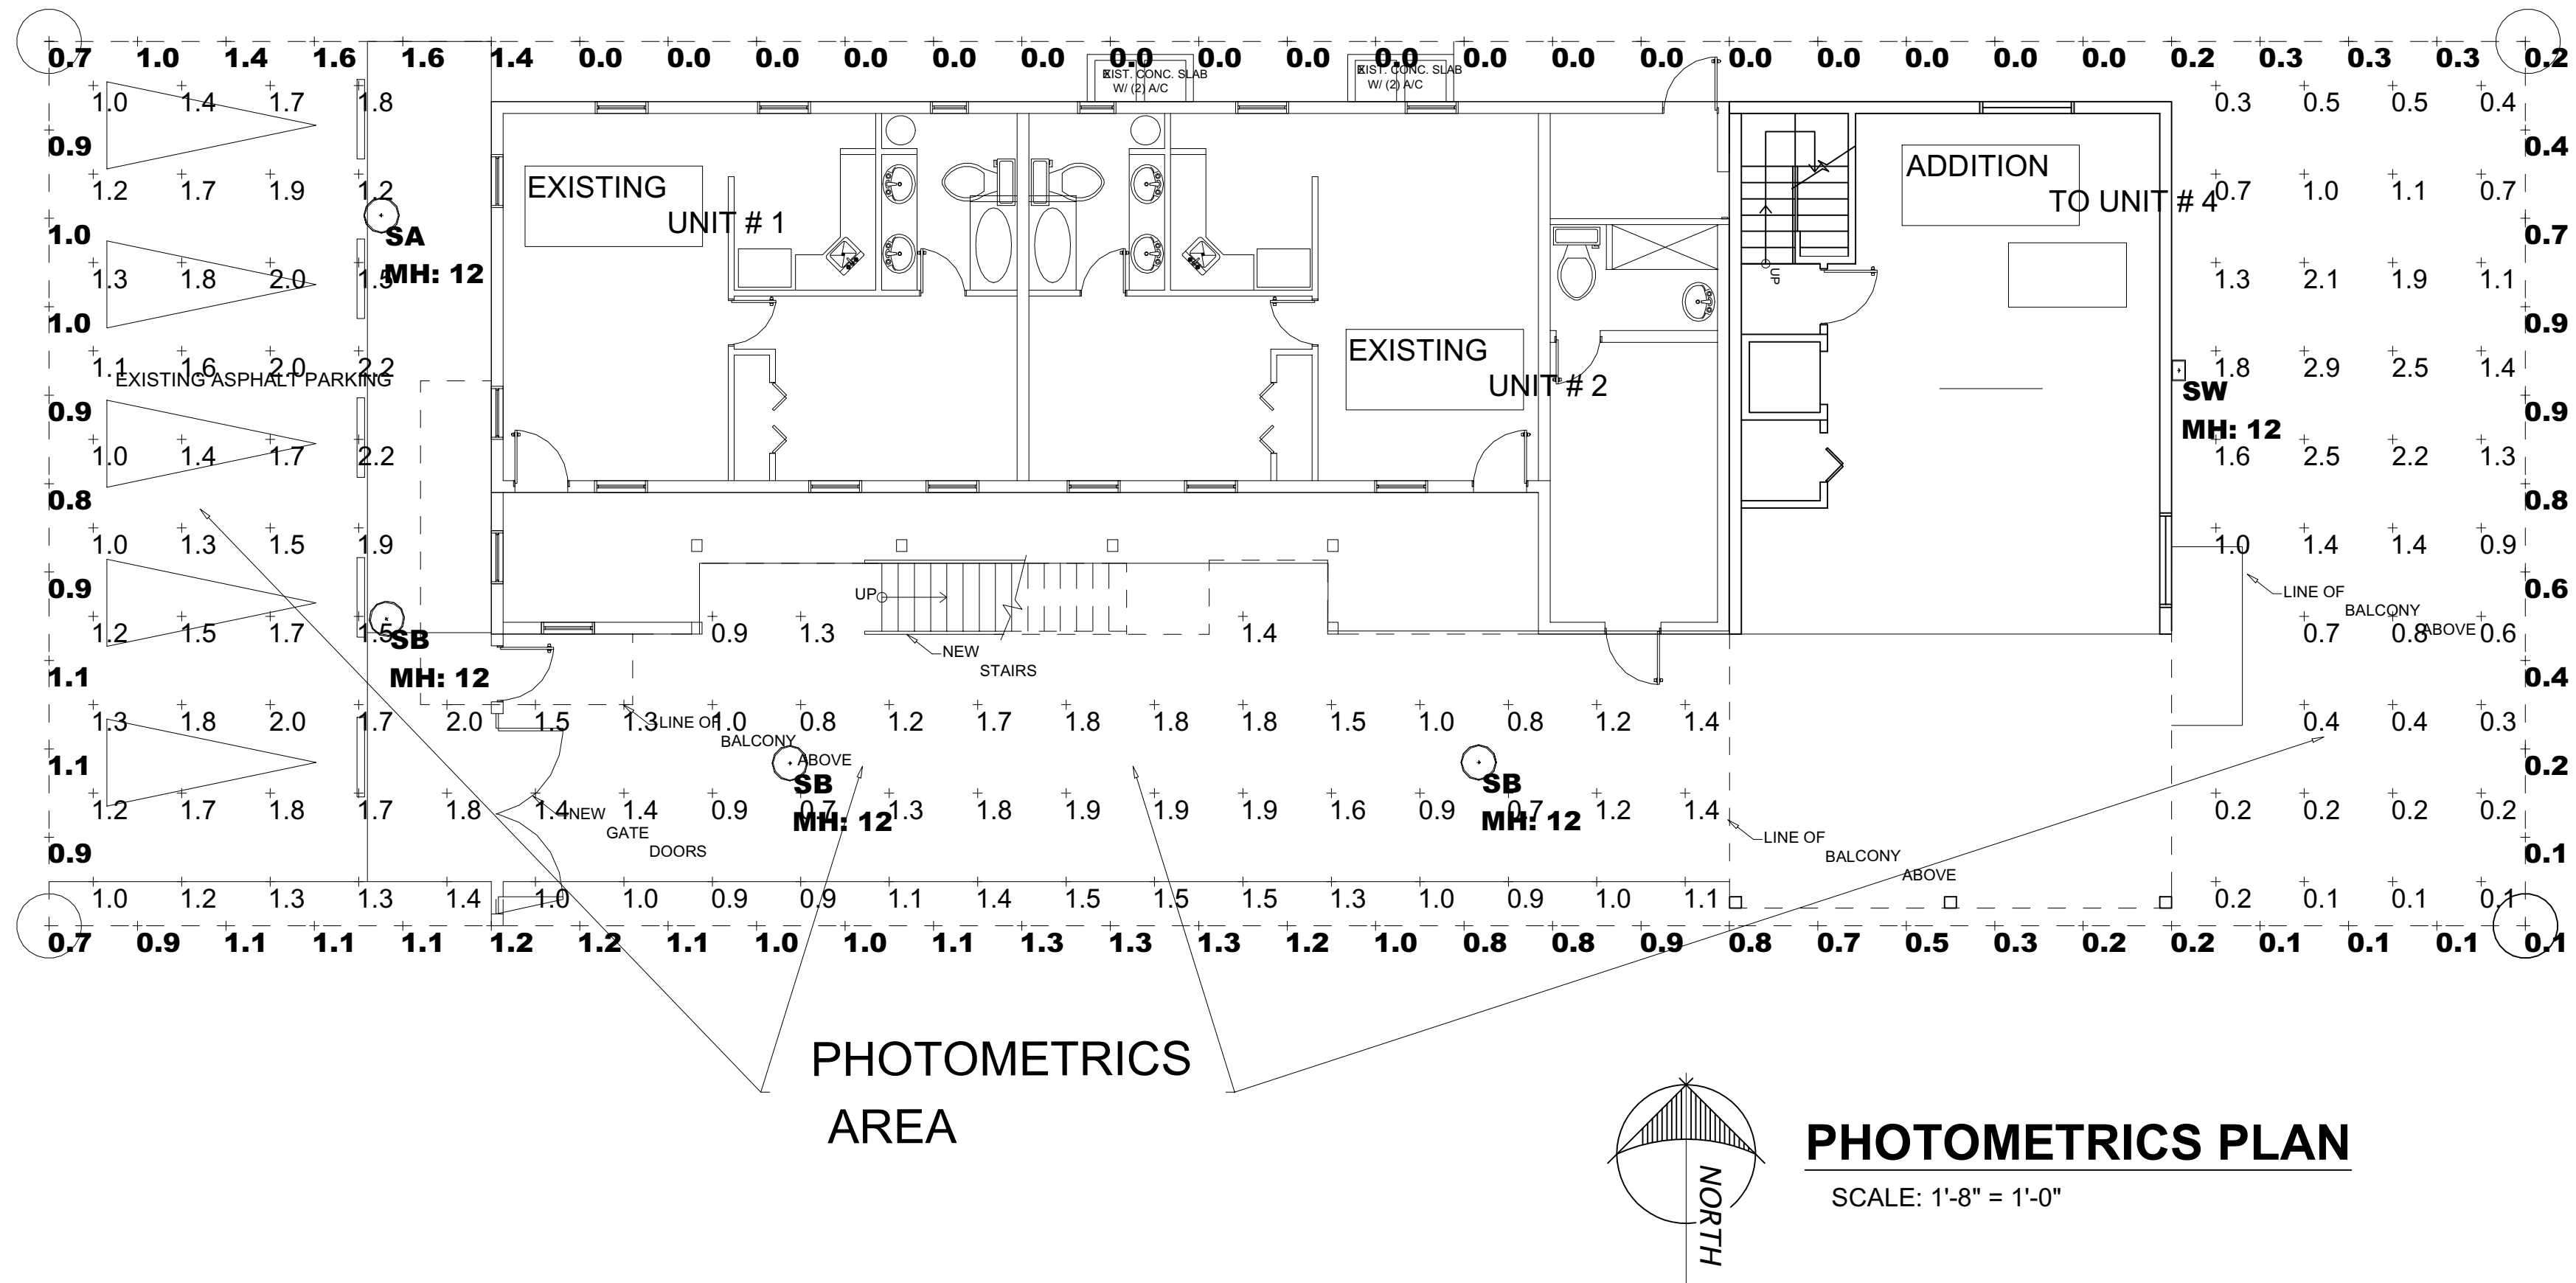
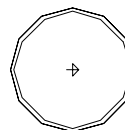
 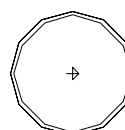


STATE ROAD NO. A-1-A
OCEAN BOULEVARD



Luminaire Schedule									
Project: 504 OCEAN BLVD - SITE POMPANO, FL 03/03/2021									
Symbol	Qty	Label	Arrangement	Manufacturer	Description	Luminaire Lumens	LLF	Luminaire Watts	Assembly Watts
	1	SA	SINGLE	Lithonia Lighting	RADPT P1 40K SYM MH: POST TOP MOUNT A.F.G	3343	0.855	25.4134	25.4134
	3	SB	SINGLE	Lithonia Lighting	RADPT P1 40K PATH MH: POST TOP MOUNT A.F.G	2592	0.855	25.4134	25.4134
	1	SW	SINGLE	Lithonia Lighting	ARC2 LED P1 40K MH: WALL MOUNT A.F.G	1587	0.855	10.6112	10.6112

Calculation Summary							
Project: 504 OCEAN BLVD - SITE POMPANO, FL 03/03/2021							
Label	CalcType	Units	Avg	Max	Min	Avg/Min	Max/Min
PROPERTY LINE	Illuminance	Fc	0.60	1.6	0.0	N.A.	N.A.
PARKING LOT	Illuminance	Fc	1.53	2.2	1.0	1.53	2.20
SITE	Illuminance	Fc	1.16	2.9	0.1	11.60	29.00

REVISIONS BY

PROPERTY OWNER:

ANAM USMAN

PROPERTY ADDRESS:

504 SOUTH OCEAN BLVD

POMPANO BEACH FL

TITLE SHEET
PHOTOMETRICS
FLOOR PLAN

Digitally signed by Luis E. Uriarte
DN: cn=Luis E. Uriarte, o=URIARTE ARCHITECT, ou=18100 ATLANTIC BOULEVARD, email=invusa@live.com, c=US
10D000000100000178195887819588292000001AE900001AE9

ARCHITECT:
LUIS E. URIARTE
Florida Architect
18100 ATLANTIC BOULEVARD
786 290 9807
Email: invusa@live.com

DRAWN BY:
LUIS URIARTE
DATE: 6.3.2021
SCALE: AS NOTED
PROJECT:

DRC
PZ21-12000018
7/7/2021