


NORTH

SCALE 1" = 20'-0"



GRAPHIC SCALE

SECTION 34, TOWNSHIP 48 SOUTH, RANGE 42 EAST

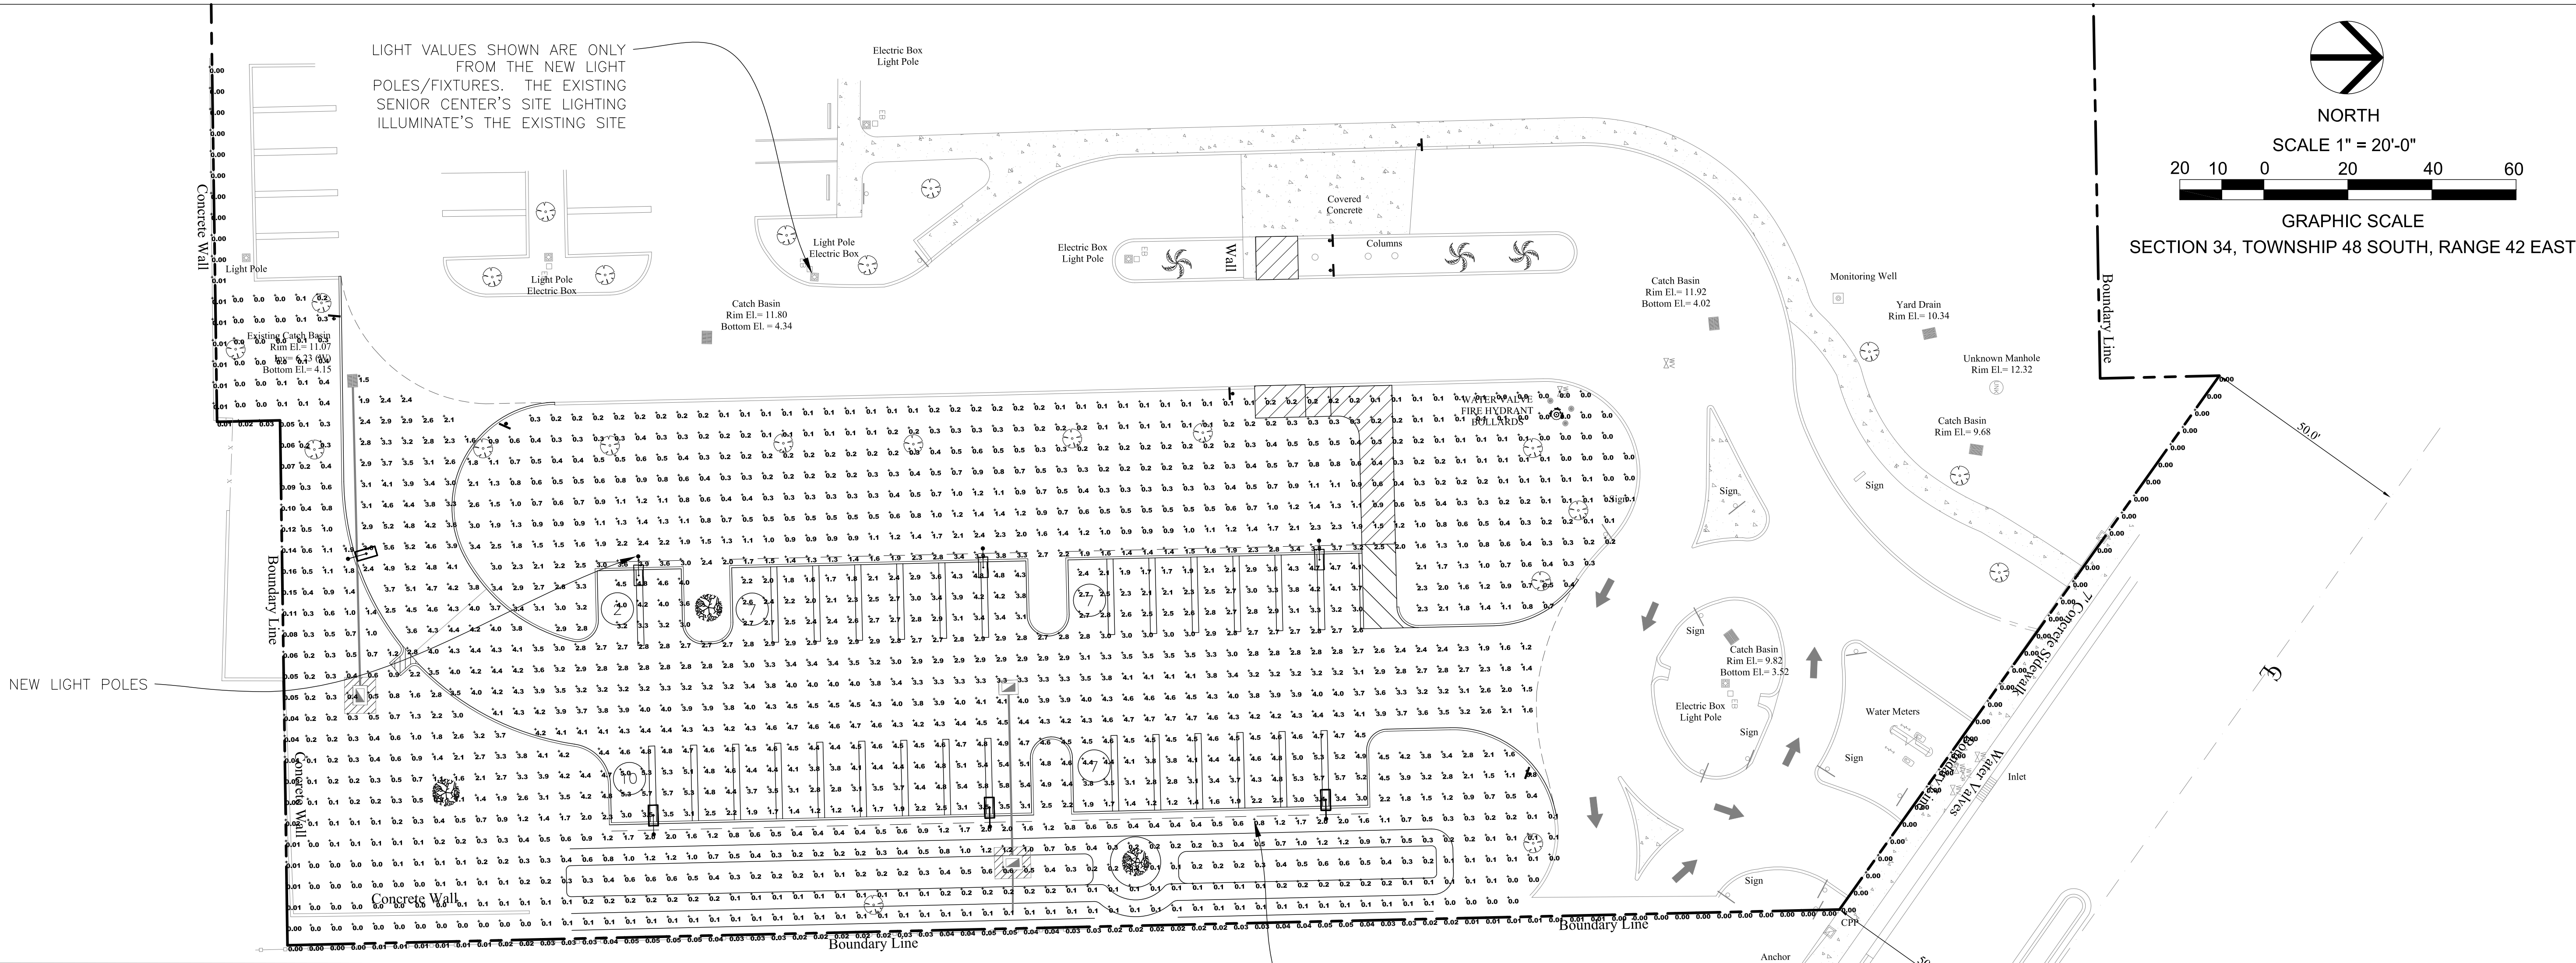

Luminaire Schedule: CITY OF POMPANO BEACH SENIOR ACTIVITY CENTER - SITE POMPANO BEACH, FL 05/10/2023								
Symbol	Qty	Label	Arrangement	Manufacturer	Catalog Number	Mounting	LLF	Luminaire Lumens
●	3	SA	Single	Lithonia Lighting	RSX2 LED P1 40K R3	POLE MOUNT A.F.G.	0.903	10991
●	4	SB	Single	Lithonia Lighting	RSX2 LED P2 40K R3 HS	POLE MOUNT A.F.G.	0.903	12072

Calculation Summary: CITY OF POMPANO BEACH SENIOR ACTIVITY CENTER - SITE POMPANO BEACH, FL 05/10/2023							
Label	Calc Type	Units	Avg	Max	Min	Avg/Min	Max/Min
PARKING LOT & DRIVE LANES	Illuminance	Fc	3.54	5.8	1.2	2.95	4.83
SPILL HORIZONTAL (6" above grade)	Illuminance	Fc	0.02	0.16	0.00	N.A.	N.A.
SPILL VERTICAL (6" above grade)	Illuminance	Fc	0.07	0.34	0.00	N.A.	N.A.

RSX2 LED Area Luminaire

Specifications
Size: 24.9" (626 mm)
Length: 29.3" (744 mm)
Width: 13.4" (340 mm)
Height: 3.0" (76 mm)
Weight: 30.0 lbs (13.6 kg)

Introduction
The new RSX2 LED Area family delivers maximum value by providing significant energy savings, long life and outstanding photometric performance at an affordable price. The RSX2 delivers 11,000 to 31,000 lumens allowing it to replace 250W to 1000W HID luminaires.

Ordering Information
EXAMPLE: RSX2 LED P6 40K R3 MV02 SP4 DDBXD

Options
Shipped Standard
Shipped Separately (purchase items sold separately)

RTA Round Tapered Aluminum Pole

Introduction
The new RTA Round Tapered Aluminum Pole family delivers maximum value by providing significant energy savings, long life and outstanding photometric performance at an affordable price. The RTA delivers 11,000 to 31,000 lumens allowing it to replace 250W to 1000W HID luminaires.

Ordering Information
EXAMPLE: RTA20B6BE


Options
Shipped Standard
Shipped Separately (purchase items sold separately)

RTA20B6BE

Introduction
The new RTA20B6BE Round Tapered Aluminum Pole family delivers maximum value by providing significant energy savings, long life and outstanding photometric performance at an affordable price. The RTA20B6BE delivers 11,000 to 31,000 lumens allowing it to replace 250W to 1000W HID luminaires.

Ordering Information
EXAMPLE: RTA20B6BE

Options
Shipped Standard
Shipped Separately (purchase items sold separately)

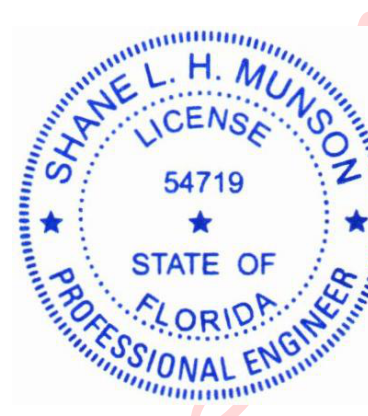

DATED: 05/11/2023
THIS ITEM HAS BEEN DIGITALLY SIGNED AND SEALED BY SHANE L. H. MUNSON ON THE DATE ADJACENT TO THE SEAL.

PRINTED COPIES OF THIS DOCUMENT ARE NOT CONSIDERED VALID UNLESS THE SIGNATURE MUST BE VERIFIED ON ANY ELECTRONIC COPIES.

DRC
PZ23-12000015
06/21/2023