

1 SECURITY FLOOR PLAN - LEVEL 5 - PARKING GARAGE
3/32" = 1'-0"



Heilmuth, Obata & Kassabaum, Inc.
124 Giralda Avenue, Suite 100
Coral Gables, FL 33134 USA
t +1 786 539 0800
www.hok.com/studios/miami

Qualifying Agent, Jonathan Rae - FL Reg. No. AR82342

All reproduction & related of property rights reserved © 2024
In Association with



THA Consulting, Inc.
Parking
40 NW 3rd Street, Suite 1102
Miami, FL 33128
T: 305 592 7123
www.tha-consulting.com



Hammond & Associates INC
Mechanical, Fire Protection
499 N.W. 10th Ave, Suite 215
Fort Lauderdale, FL 33311
PH: 954-327-7111
www.hammondengineers.com



 
Kugler Ning Lighting, Inc.
Lighting Design
247 West 17th Street Suite 1502
New York, NY 10018
www.kuglerlighting.com



SOCOTEC Life Safety, LLC
Life Safety
1380 W. Peachtree St NW Suite #1010
Atlanta, GA 30309
www.socotec.us




VDA, Inc.
Vertical Transportation
1000 West McAlister Road, Suite 209
Pompano Beach, FL 33069



Brooks Acoustics
Acoustics
49 N. Federal Highway #121
Pompano Beach, FL 33062

NOT FOR
CONSTRUCTION

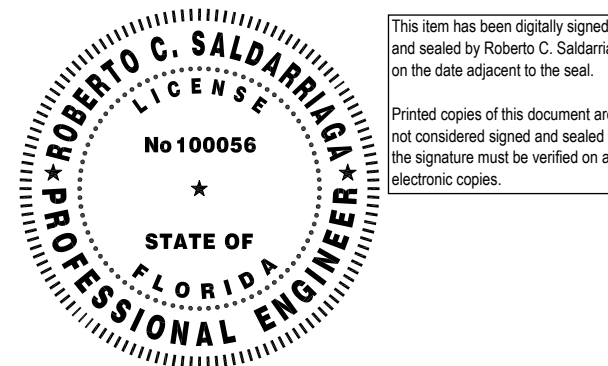

No.	Description	Date
100%	SCHEMATIC DESIGN	11/21/2023
90%	DESIGN DEVELOPMENT	01/23/2024
100%	DESIGN DEVELOPMENT	03/09/2024
PRC	SUBMISSION	03/11/2024
AMC	SUBMISSION	04/09/2024
PRC	RESUBMISSION	04/09/2024



SECURITY FLOOR PLAN -
LEVEL 5 - PARKING
GARAGE

Original: 05/27/2026 Scale: As Shown
Sheet Number