



Heilmuth, Obata & Kassabaum, Inc.
124 Giralda Avenue, Suite 100
Coral Gables, FL 33134 USA
t +1 786 539 0800
www.hok.com/studios/miami

Qualifying Agent, Jonathan Rae - FL Reg. No. AR82342

All reproduction & intellectual property rights reserved © 2025
In Association with



THA CONSULTING

THA Consulting, Inc.
Pompano
40 NW 3rd Street, Suite 1102
Miami, FL 33128
T: 305.592.7123
www.tha-consulting.com



Hammond & Associates INC
Mechanical, Fire Protection
499 N.W. 7th Ave, Suite 215
Fort Lauderdale, FL 33311
PH: 954-327-7111
www.hammondengineers.com



Kugler Ning Lighting

Kugler Ning Lighting, Inc.
Lighting Design
247 West 17th Street Suite 1502
New York, NY 10018
www.kuglerlighting.com



SOCOTEC

SOCOTEC Life Safety, LLC
Life Safety
1380 W. Peachtree St NW Suite #1010
Atlanta, GA 30309
www.socotec.us



VDA Inc

Vertical Transportation
1000 West McAlister Road, Suite 209
Pompano Beach, FL 33069



Brooks Acoustics

Acoustics
49 N. Federal Highway #121
Pompano Beach, FL 33062

NOT FOR
CONSTRUCTION

Professional Seals

Professional Seal

Professional Seal


Professional Seal

Professional Seal

Professional Seal



1 SECURITY FLOOR PLAN - LEVEL 4 - CITY HALL
1/8" = 1'-0"

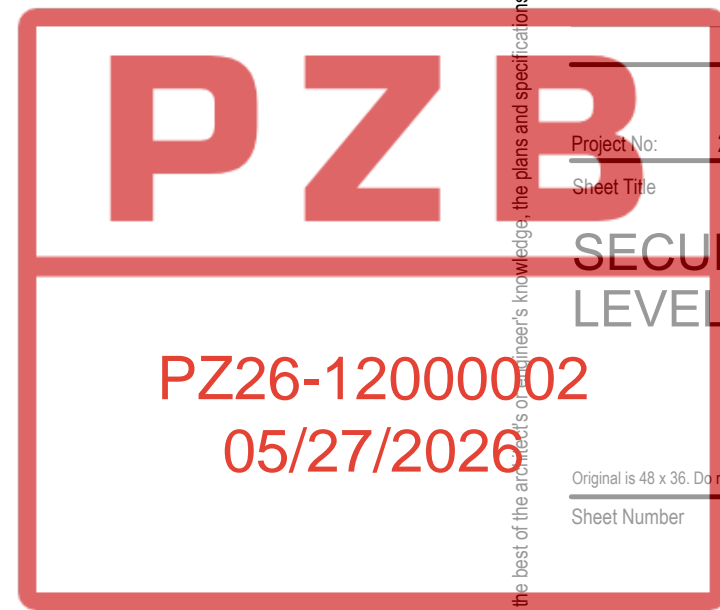

PZ26-12000002
05/27/2026

SECURITY FLOOR PLAN -
LEVEL 4 - CITY HALL

Original is 11x17. Scale contents of this drawing.
Sheet Number

TY104